


SECTION-VIII APPROPRIATE LAYOUT OF PROCESSING UNITS

101 CHIRONJEE PROCESSING UNIT

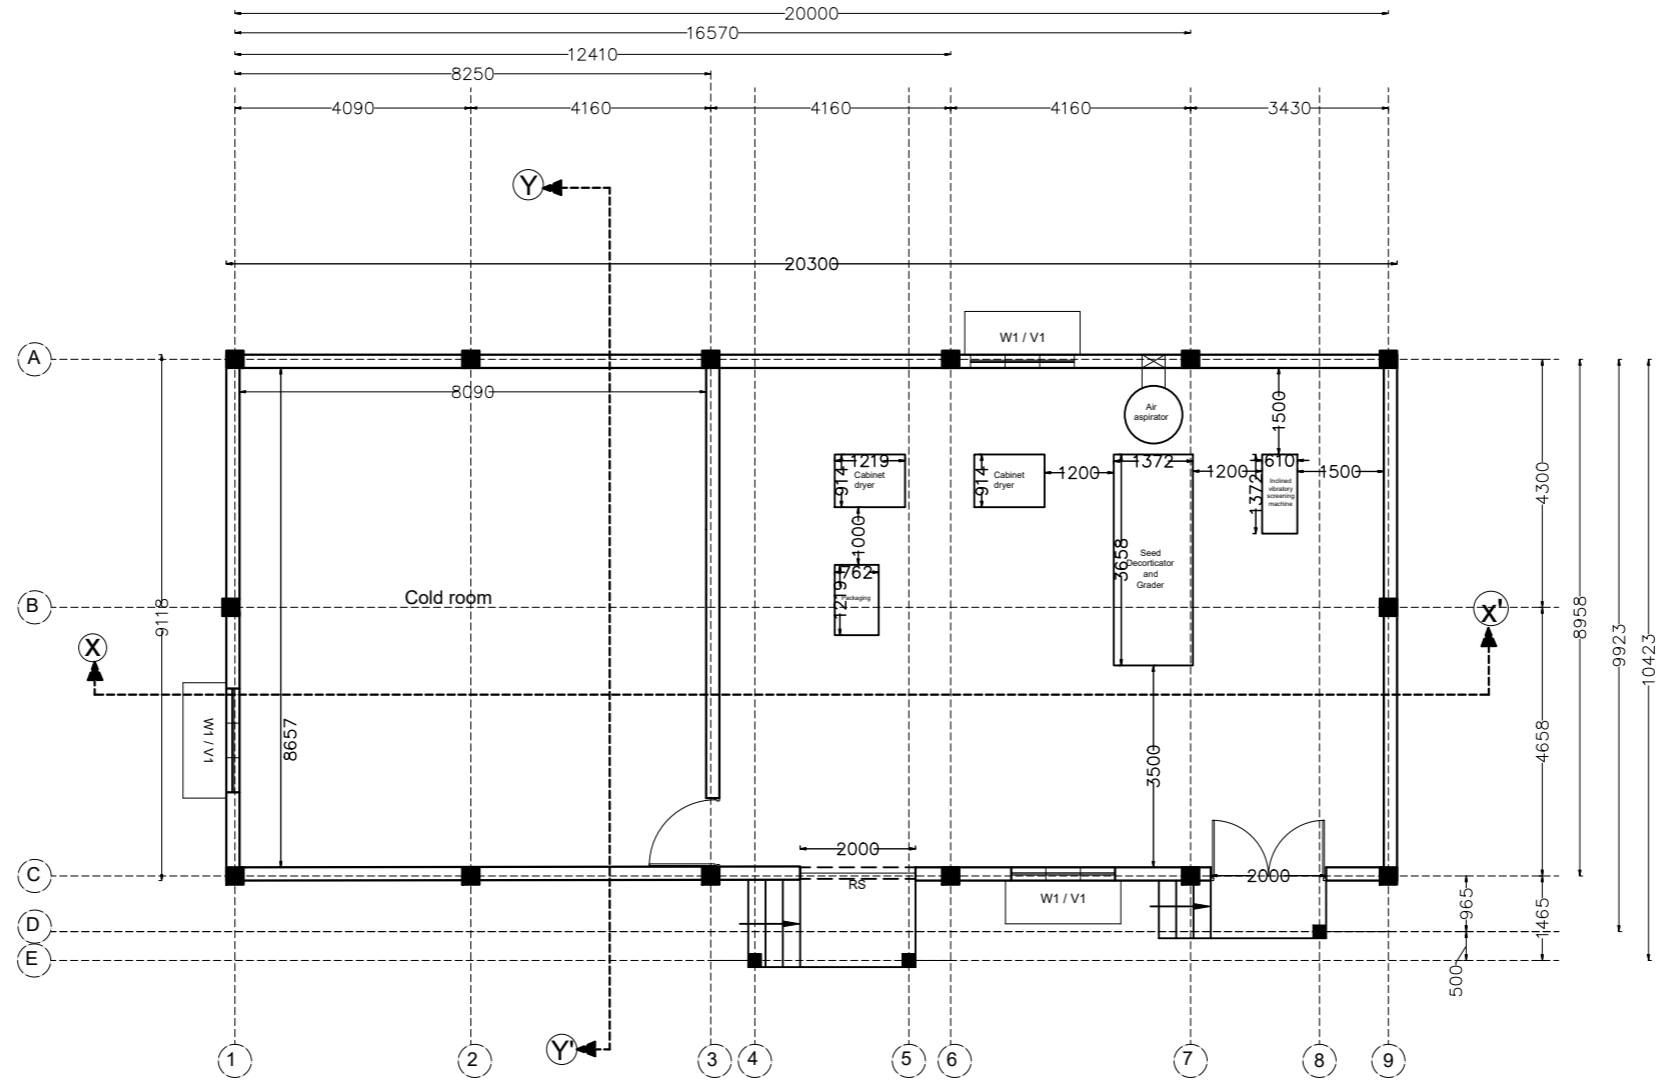

CHIRONJEE PROCESSING UNIT
BUILD UP AREA - 192 SQM

LIST OF DRAWING
CHIRONJEE PROCESSING UNIT
DP0001 DRG CL 01 100

- 1 - PLAN LAYOUT
- 2 - SECTION / ELEVATION
- 3 - COLUMN LAYOUT
- 4 - FOOTING LAYOUT
- 5 - GROUND BEAM LAYOUT
- 6 - BEAM LAYOUT (2.5 M ABOVE)
- 7 - BEAM LAYOUT (4.5 M ABOVE)
- 8 - TRUSS DETAIL
- 9 - ELECTRICAL LAYOUT

OPENING SCHEDULE

NAME	SAYMBOL
WINDOW	W1
VENTILATOR	V1
ROLLING SHUTTER	R1
DOOR	D1

SN	SAYMBOL	NOS	SIZE
01	W1	02	1.8M X 1.5M
02	V1	03	1.8 M X 1 M
03	R1	01	2M X 2.4 M
04	D2	01	2M X 2.1M

Designed by ZWCAD Academic Version

Designed by ZWCAD Academic Version

DRG NO: DP0001 DRG CL 01 100/01	SHEET NO: 1 OF 9	REV. R0	SCALE: NTS	SWATI Architecture landscape interior ARCHITECTS PLANERS ENGINEERING INTERIOR DESIGN 282 , tulip , A block , Talpuri International colony , Bhilai , C.G. Email - swati.arch@outlook.com
DESIGNED: UPENDRA SINGH	DRAWN: SIMRAN SONI	CHECKED: UPENDRA SINGH	APPROVED: ADMIN	
ISSUED FOR: GOOD FOR CONSTRUCTION		UNIT: MILIMETER	DATE: 12.05.2022	PROJECT: INCUBATION CENTER & RURAL INDUSTRIAL PARK DEOBHOG GARIYABAND C.G.
This drawing is the property of HUP DESIGN and is to be used only for the purpose for which it was lent and must not be in any way detrimental to the interest of the company and is subject to return on demand				TITLE: CHIRONJEE PROCESSING UNIT PLAN LAYOUT

102 NEEM / MAHUA / KUSUM /GROUNDNUT OIL/ CHIKKI MAKING UNIT


LIST OF DRAWING
NEEM / MAHUA / KUSUM /
GROUND NUT OIL EXTRACTION
DP0001 DRG CL 01 101

- 1 - PLAN LAYOUT
- 2 - SECTION / ELEVATION
- 3 - COLUMN LAYOUT
- 4 - FOOTING LAYOUT
- 5 - GROUND BEAM LAYOUT
- 6 - BEAM LAYOUT (2.5 M ABOVE)
- 7 - BEAM LAYOUT (4.5 M ABOVE)
- 8 - TRUSS DETAIL
- 9 - ELECTRICAL LAYOUT

OPENING SCHEDULE

NAME	SAYMBOL
WINDOW	W1
VENTILATOR	V1
ROLLING SHUTTER	R1
DOOR	D1

SN	SAYMBOL	NOS	SIZE
01	W1	11	1.8M X 1.5M
02	V1	15	1.8 M X 1 M
03	D2	03	1.2 M X 2.1M
04	D1	07	1M X 2.1 M
05	R1	02	2.0 M X 2.5 M

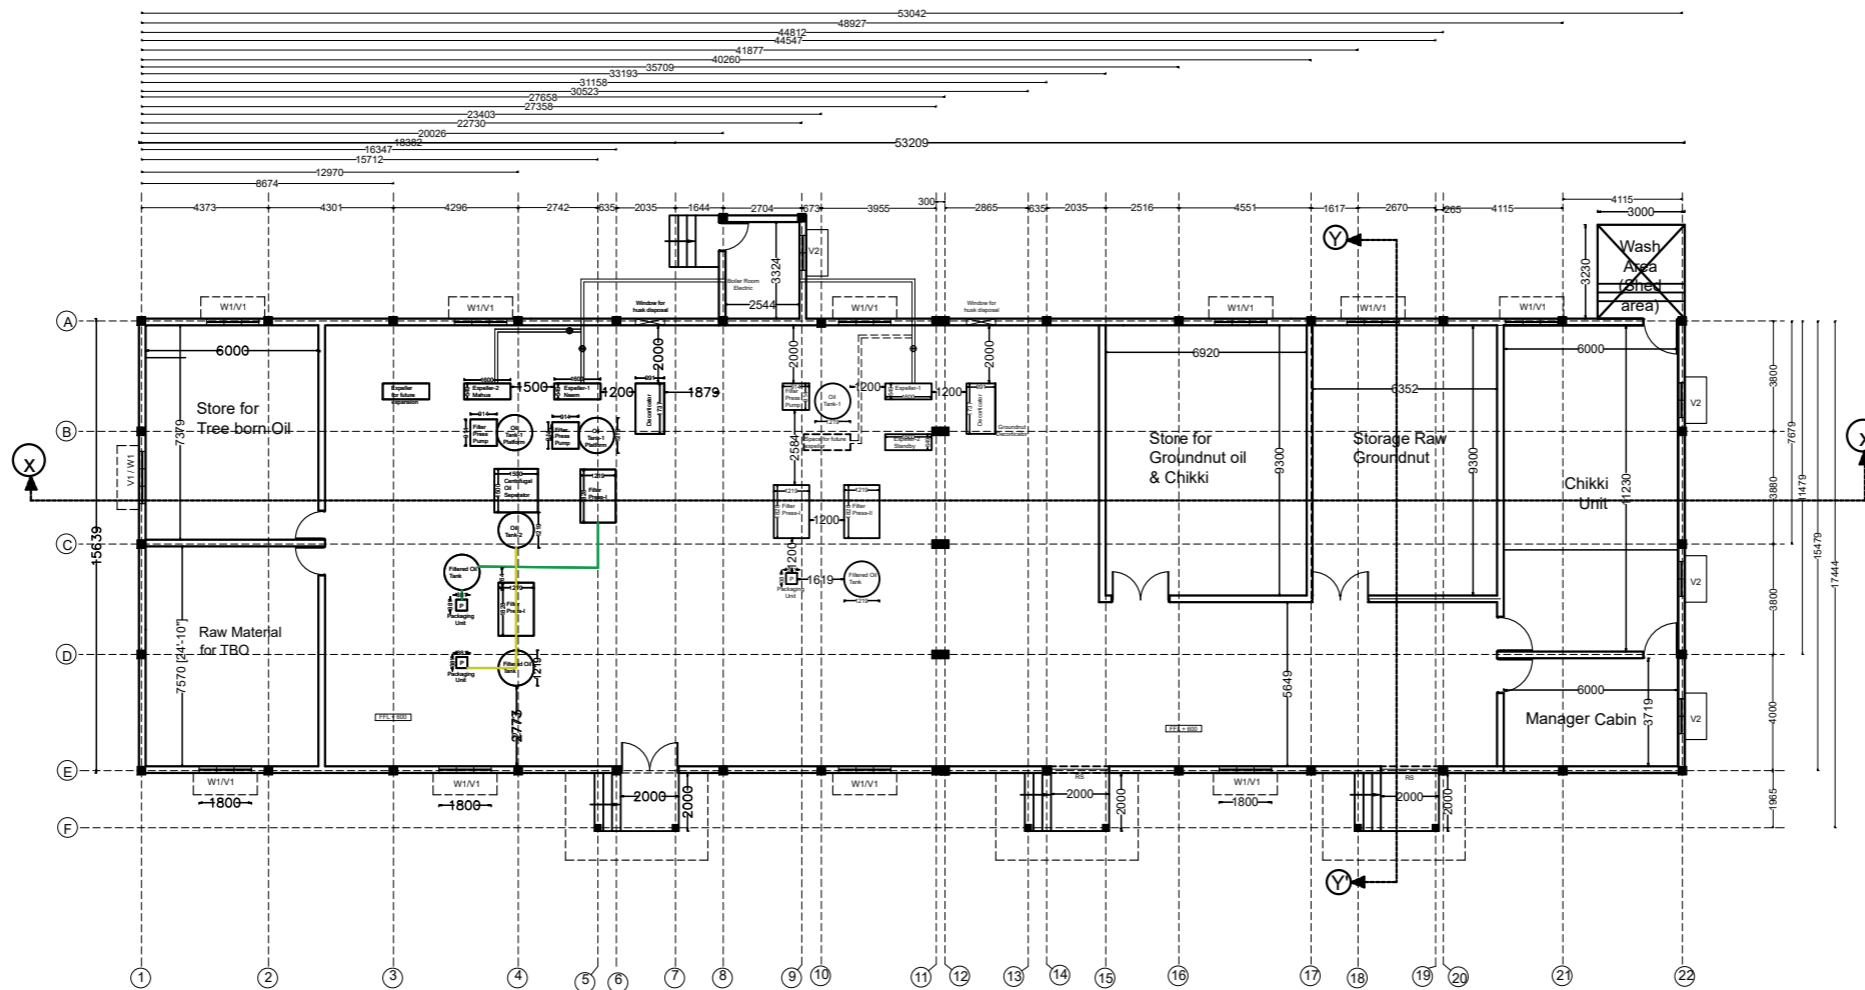


NEEM / MAHUA / KUSUM /GROUNDNUT OIL/ CHIKKI UNIT
 BUILD UP AREA - 866 SQM

DRG NO: DP0001 DRG CL 01 101/01	SHEET NO: 1 OF 9	REV. R0	SCALE: NTS	SWATI Architecture landscape interior ARCHITECTS PLANERS ENGINEERING INTERIOR DESIGN 282 , tulip , A block , Talpuri International colony , Bhilai , C.G. Email - swati.arch@outlook.com
DESIGNED: UPENDRA SINGH	DRAWN: SIMRAN SONI	CHECKED: UPENDRA SINGH	APPROVED: ADMIN	
ISSUED FOR: GOOD FOR CONSTRUCTION		UNIT: MILIMETER	DATE: 12.05.2022	PROJECT: INCUBATION CENTER & RURAL INDUSTRIAL PARK DEOBHOG GARIYABAND C.G.
This drawing is the property of HUP DESIGN and is to be used only for the purpose for which it was lent and must not be in any way detrimental to the interest of the company and is subject to return on demand				TITLE: NEEM / MAHUA / KUSUM /GROUNDNUT OIL EXTRACTION UNIT PLAN LAYOUT

Designed by ZWCAD Academic Version

Designed by ZWCAD Academic Version

103 MASALA PROCESSING UNIT

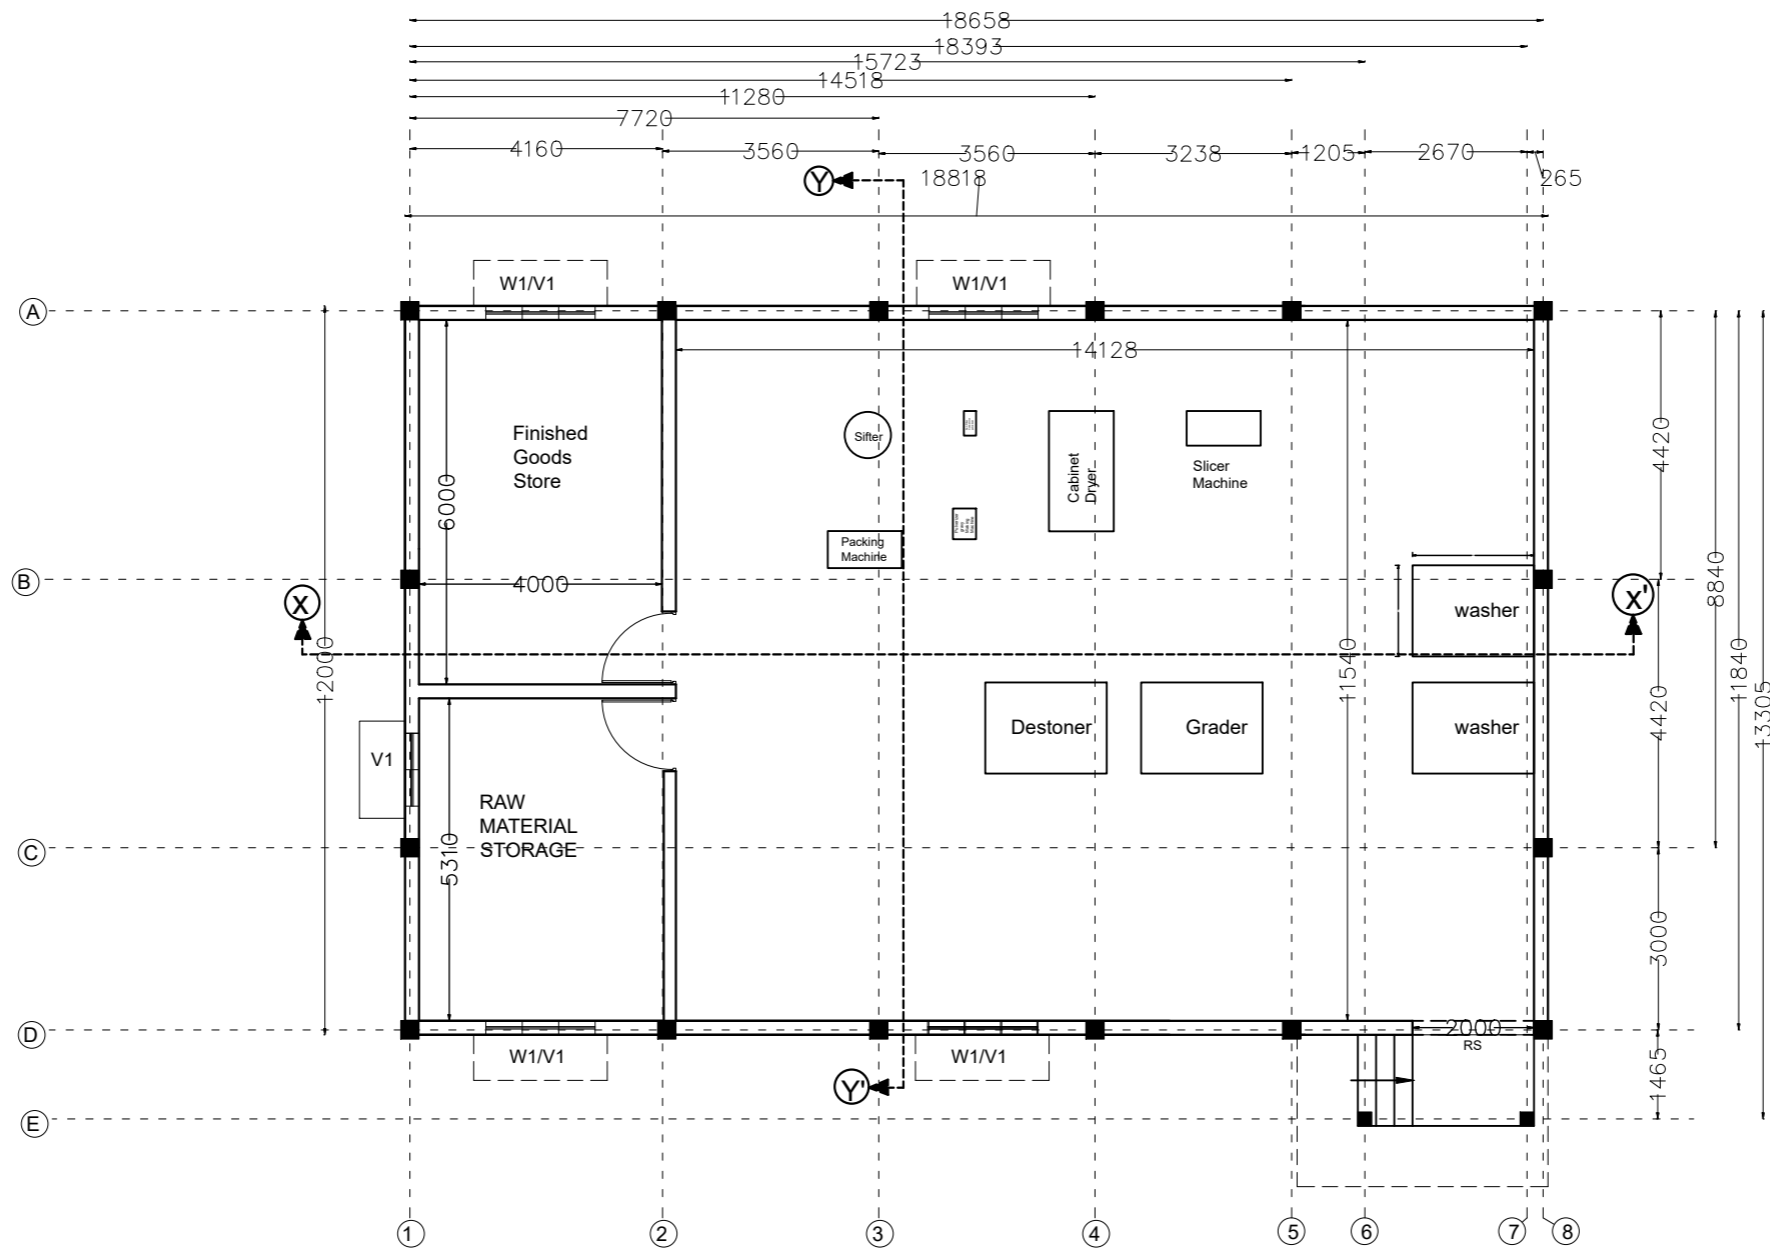

MASALA PROCESSING UNIT
BUILD UP AREA - 230 SQM

LIST OF DRAWING
MASALA PROCESSING UNIT
DP0001 DRG CL 01 102

- 1 - PLAN LAYOUT
- 2 - SECTION / ELEVATION
- 3 - COLUMN LAYOUT
- 4 - FOOTING LAYOUT
- 5 - GROUND BEAM LAYOUT
- 6 - BEAM LAYOUT (2.5 M ABOVE)
- 7 - BEAM LAYOUT (4.5 M ABOVE)
- 8 - TRUSS DETAIL
- 9 - ELECTRICAL LAYOUT


OPENING SCHEDULE

NAME		SAYMBOL	
WINDOW	W1	W1	
VENTILATOR	V1	V1	
ROLLING SHUTTER	R1	R1	
DOOR	D1	D1	
SN	SAYMBOL	NOS	SIZE
01	W1	04	1.8M X 1.5M
02	V1	05	1.8 M X 1 M
03	D1	02	1 M X 2.1M
04	R1	01	2M X 2.1 M

DRG NO: DP0001 DRG CL 01 102/01	SHEET NO: 1 OF 9	REV. R0	SCALE: NTS	SWATI Architecture landscape interior ARCHITECTS PLANERS ENGINEERING INTERIOR DESIGN 282 , tulip , A block , Talpuri International colony , Bhilai , C.G. Email - swati.arch@outlook.com	
DESIGNED: UPENDRA SINGH	DRAWN: SIMRAN SONI	CHECKED: UPENDRA SINGH	VERIFIED: ADMIN		
ISSUED FOR: GOOD FOR CONSTRUCTION		UNIT: MILIMETER	DATE: 12.05.2022	PROJECT: INCUBATION CENTER & RURAL INDUSTRIAL PARK DEOBHOG GARIYABAND C.G.	TITLE: MASALA PROCESSING UNIT PLAN LAYOUT

This drawing is the property of HUP DESIGN and is to be used only for the purpose for which it was lent and must not be in any way detrimental to the interest of the company and is subject to return on demand

104 PRIMARY PROCESSING UNIT

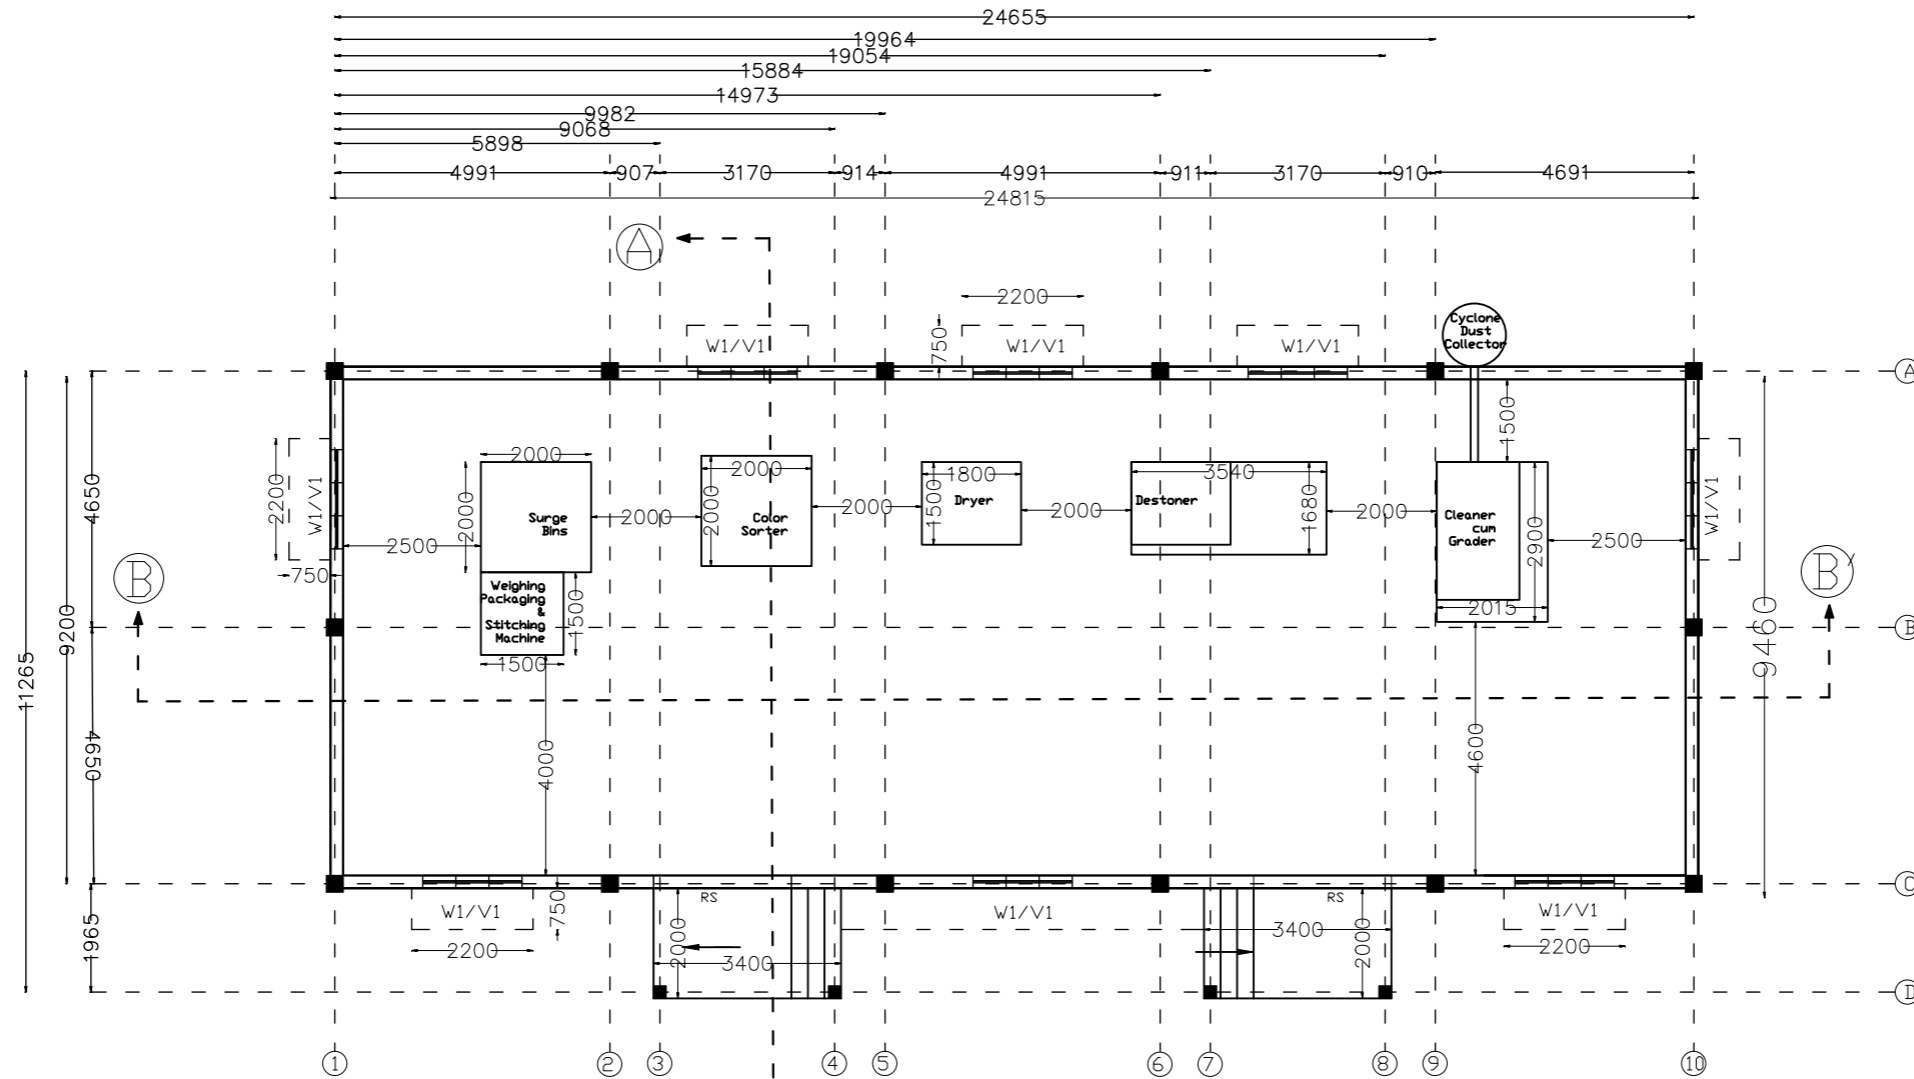

PRIMARY PROCESSING UNIT – 4 TONNE
BUILTUP AREA – 235 SQM

LIST OF DRAWING
PRIMARY PROCESSING UNIT
DP0001 DRG CL 01 103

- 1 - PLAN LAYOUT
- 2 - SECTION / ELEVATION
- 3 - COLUMN LAYOUT
- 4 - FOOTING LAYOUT
- 5 - GROUND BEAM LAYOUT
- 6 - BEAM LAYOUT (2.5 M ABOVE)
- 7 - BEAM LAYOUT (4.5 M ABOVE)
- 8 - TRUSS DETAIL
- 9 - ELECTRICAL LAYOUT

OPENING SCHEDULE


NAME		SAYMBOL	
WINDOW	W1		
VENTILATOR	V1		
ROLLING SHUTTER	R1		
DOOR	D1		
SN	SAYMBOL	NOS	SIZE
01	W1	08	1.8M X 1.5M
02	V1	08	1.8 M X 1 M
03	R1	02	2.0M X 2.4 M

DRG NO: DP0001 DRG CL 01 103 / 01	SHEET NO: 1 OF 9	REV. R0	SCALE: NTS
DESIGNED: UPENDRA SINGH	DRAWN: SIMRAN SONI	CHECKED: UPENDRA SINGH	VERIFIED: ADMIN
ISSUED FOR: GOOD FOR CONSTRUCTION DRAWING		UNIT: MILIMETER	DATE: 12.05.2022

<p>SWATI Architecture landscape interior ARCHITECTS PLANERS ENGINEERING INTERIOR DESIGN 282 , tulip , A block , Talpuri International colony , Bhilai , C.G. Email - swati.arch@outlook.com</p>	
CLIENT:	CHHATTISGARH STATE MINOR FOREST PRODUCE
PROJECT:	INCUBATION CENTER & RURAL INDUSTRIAL PARK DEOBHOG GARIYABAND C.G.
TITLE:	PRIMARY PROCESSING UNIT PLAN LAYOUT

This drawing is the property of HUP DESIGN and is to be used only for the purpose for which it was lent and must not be in any way detrimental to the interest of the company and is subject to return on demand

105 LAC PROCESSING UNIT

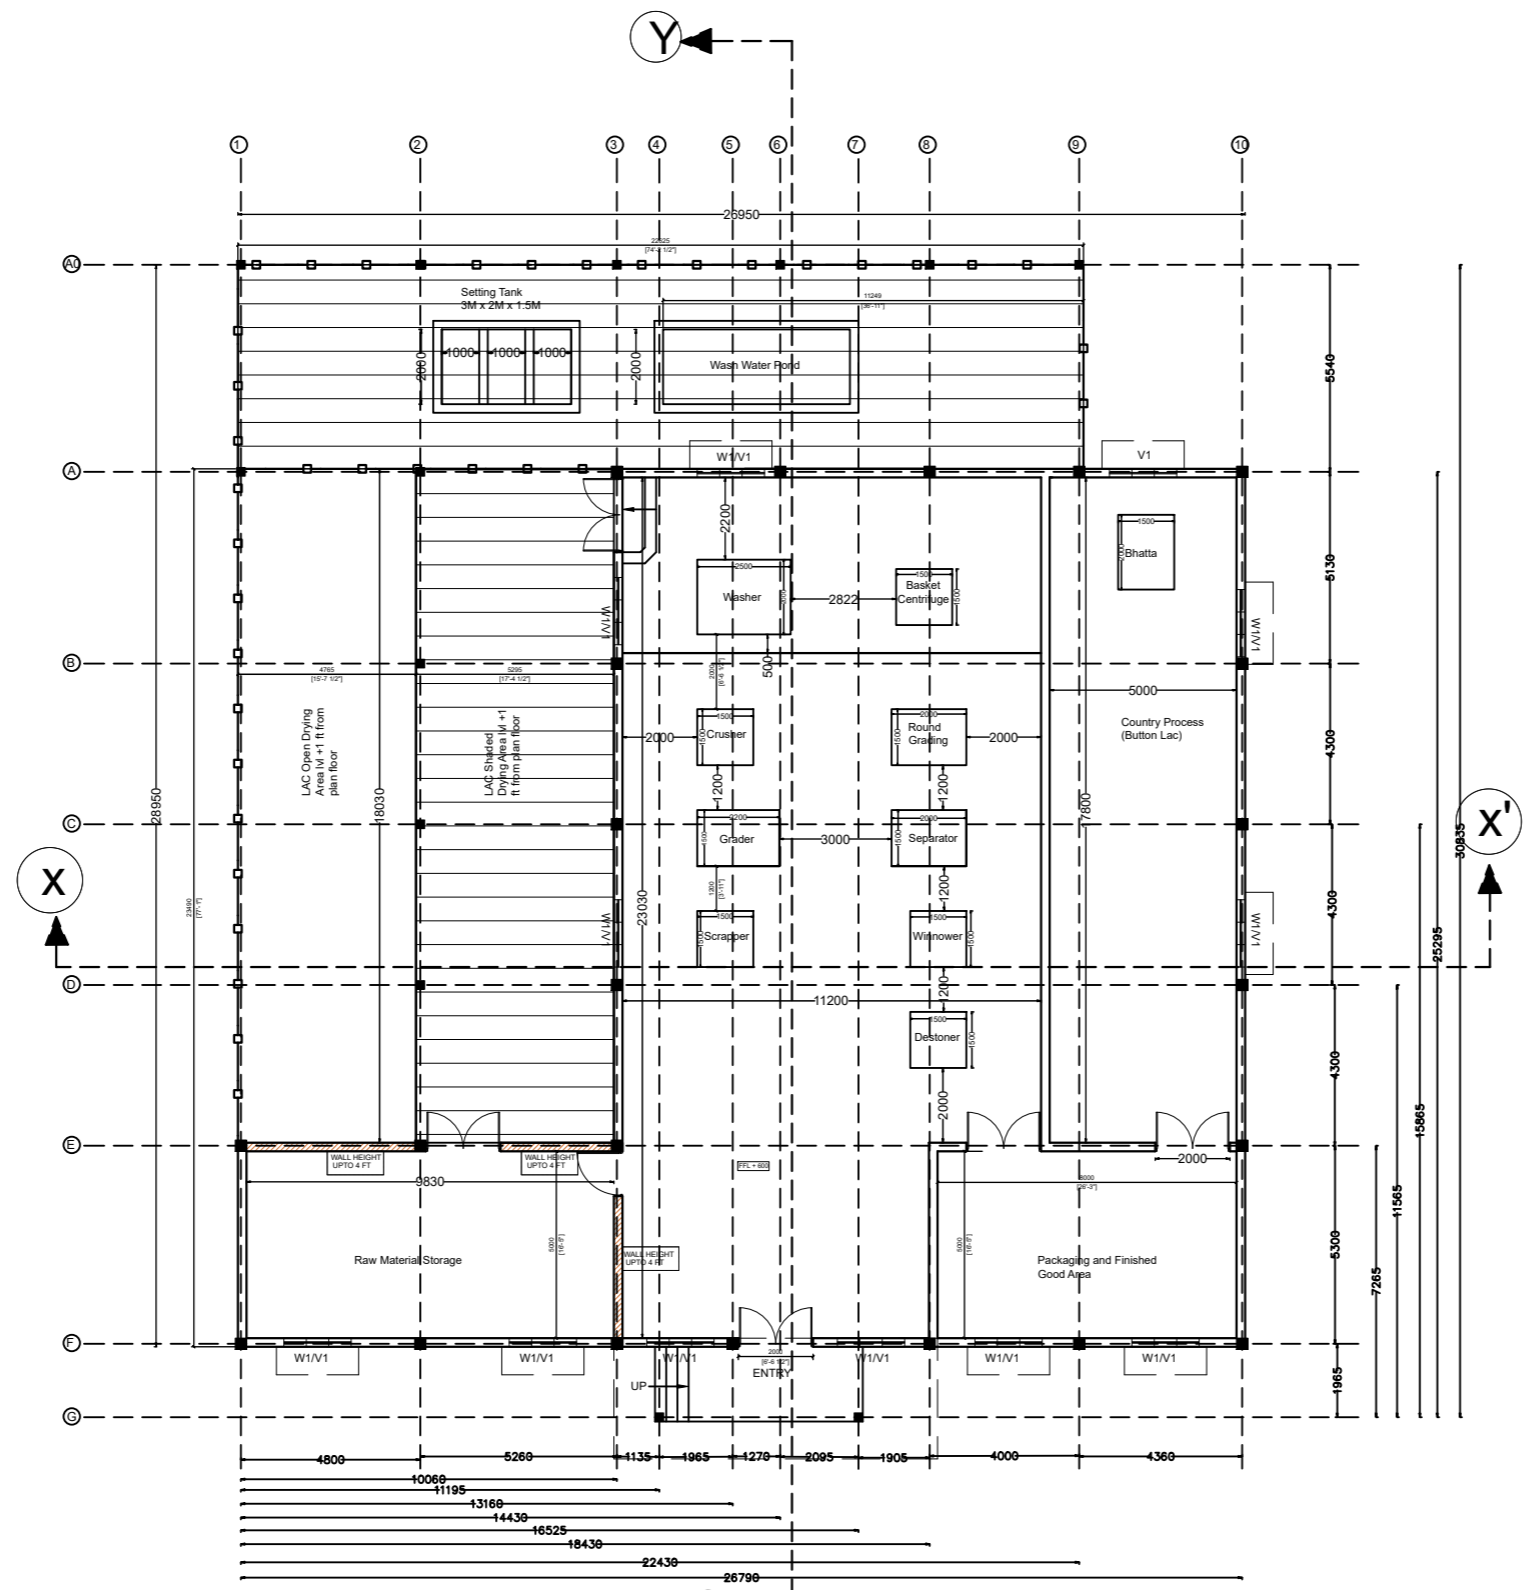

LAC PROCESSING UNIT
 BUILTUP AREA - 452 SQM
 OPEN DRYING AREA - 90 SQM
 SHADED DRYING AREA - 90 SQM
 FILTRATION TANK - 15 SQM

LIST OF DRAWING
LAC PROCESSING UNIT
DP0001 DRG CL 01 104

- 1 - PLAN LAYOUT
- 2 - SECTION / ELEVATION
- 3 - COLUMN LAYOUT
- 4 - FOOTING LAYOUT
- 5 - GROUND BEAM LAYOUT
- 6 - BEAM LAYOUT (2.5 M ABOVE)
- 7 - BEAM LAYOUT (4.5 M ABOVE)
- 8 - TRUSS DETAIL
- 9 - ELECTRICAL LAYOUT

OPENING SCHEDULE

NAME	SAYMBOL	NOS	SIZE
WINDOW	W1		
VENTILATOR	V1		
ROLLING SHUTTER	R1		
DOOR	D1		

SN	SAYMBOL	NOS	SIZE
01	W1	10	1.8M X 1.5M
02	V1	10	1.8 M X 1 M
03	D1	01	1M X 2.1 M
04	D2	05	2M X 2.1M

DRG NO: DP0001 DRG CL 01 104/01	SHEET NO: 1 OF 9	REV. R0	SCALE: NTS
DESIGNED: UPENDRA SINGH	DRAWN: SIMRAN SONI	CHECKED: UPENDRA SINGH	VERIFIED: ADMIN
ISSUED FOR: GOOD FOR CONSTRUCTION	UNIT: MILIMETER	DATE: 12.05.2022	APPROVED: ADMIN


SWATI Architecture landscape interior ARCHITECTS PLANERS ENGINEERING INTERIOR DESIGN 282 , tulip , A block , Talpuri International colony , Bhillai , C.G. Email - swati.arch@outlook.com	
CLIENT:	CHHATTISGARH STATE MINOR FOREST PRODUCE
PROJECT:	INCUBATION CENTER & RURAL INDUSTRIAL PARK DEOBHOG GARIYABAND C.G.
TITLE:	LAC PROCESSING UNIT PLAN

This drawing is the property of HUP DESIGN and is to be used only for the purpose for which it was lent and must not be in any way detrimental to the interest of the company and is subject to return on demand

Designed by ZWCAD Academic Version

Designed by ZWCAD Academic Version

106 PULSE MILLING UNIT

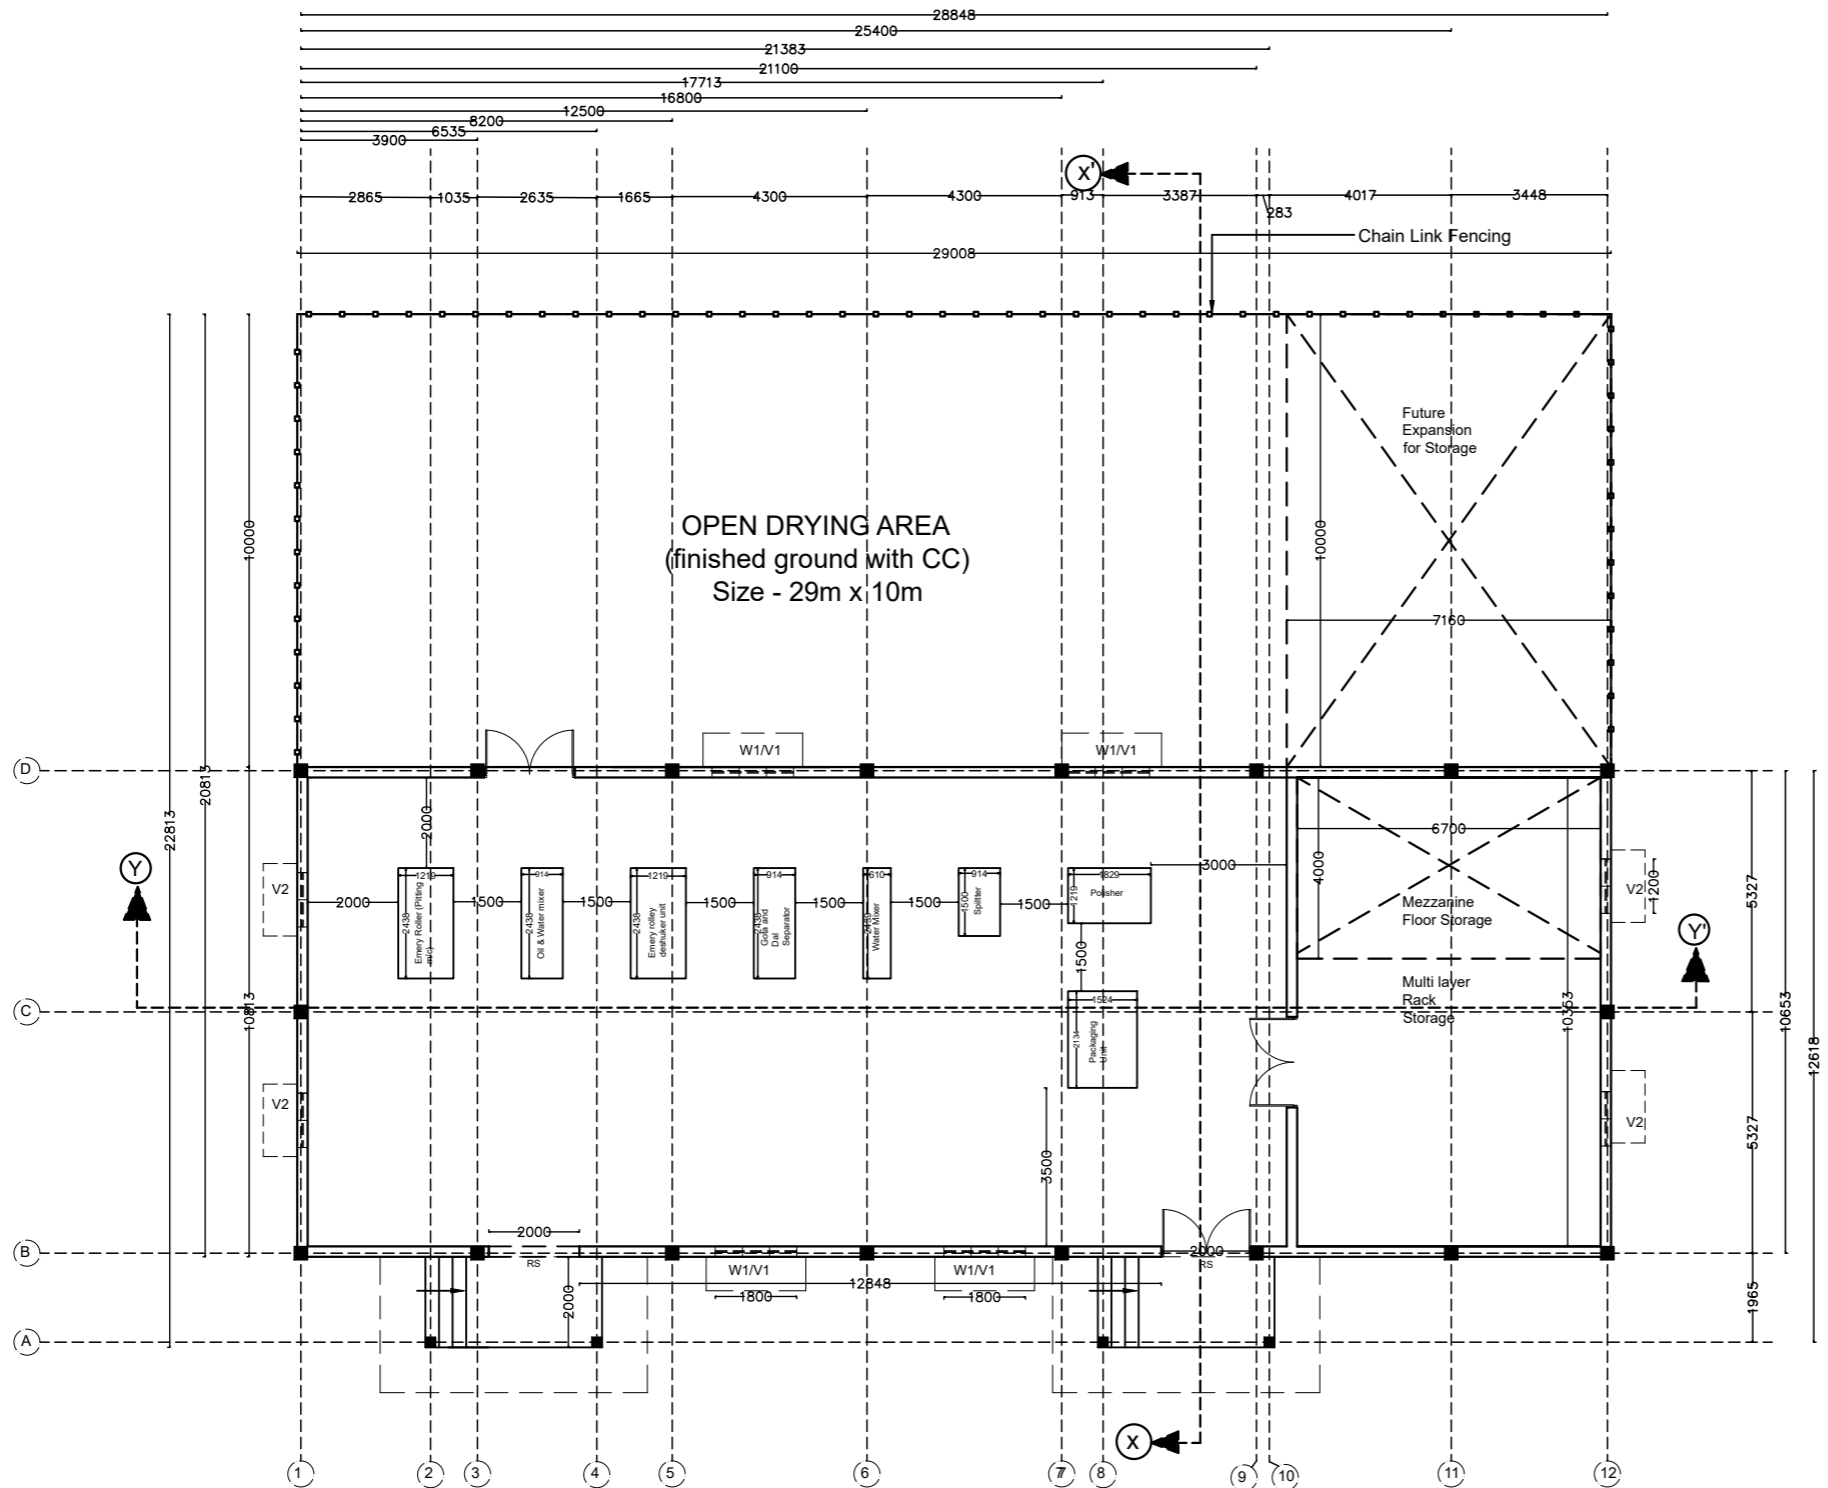

PULSE MILLING UNIT
 BUILTUP AREA - 314 SQM
 DRYING PLATFORM AREA - 290 SQM

LIST OF DRAWING
PULSE MILLING UNIT
DP0001 DRG CL 01 105

- 1 - PLAN LAYOUT
- 2 - SECTION / ELEVATION
- 3 - COLUMN LAYOUT
- 4 - FOOTING LAYOUT
- 5 - GROUND BEAM LAYOUT
- 6 - BEAM LAYOUT (2.5 M ABOVE)
- 7 - BEAM LAYOUT (4.5 M ABOVE)
- 8 - TRUSS DETAIL
- 9 - ELECTRICAL LAYOUT

OPENING SCHEDULE

NAME		SAYMBOL	
WINDOW		W1	
VENTILATOR		V1	
ROLLING SHUTTER		R1	
DOOR		D1	

SN	SAYMBOL	NOS	SIZE
01	W1	04	1.8M X 1.5M
02	V1	08	1.8 M X 1 M
03	D2	03	2M X 2.1M
04	R1	01	2.0M X 2.4 M

Designed by ZWCAD Academic Version

Designed by ZWCAD Academic Version

DRG NO: DP0001 DRG CL 01 105/01	SHEET NO: 1 OF 9	REV. R0	SCALE: NTS	SWATI Architecture landscape interior ARCHITECTS PLANERS ENGINEERING INTERIOR DESIGN 282 , tulip , A block , Talpuri International colony , Bhilai , C.G. Email - swati.arch@outlook.com
DESIGNED: UPENDRA SINGH	DRAWN: SIMRAN SONI	CHECKED: UPENDRA SINGH	APPROVED: ADMIN	
ISSUED FOR: GOOD FOR CONSTRUCTION		UNIT: MILIMETER	DATE: 12.05.2022	PROJECT: INCUBATION CENTER & RURAL INDUSTRIAL PARK DEOBHOG GARIYABAND C.G.
This drawing is the property of HUP DESIGN and is to be used only for the purpose for which it was lent and must not be in any way detrimental to the interest of the company and is subject to return on demand				TITLE: PULSE MILLING UNIT PLAN LAYOUT