


Annexure – “C”

LIST OF DRAWING		
DRAWING TITLE		
SL.NO.	PACKAGE - A	PAGE NO .
A	CHIRONJEE PROCESSING UNIT	
1	Architectural plan of chironjee processing unit	1
2	Elevation and section of chironjee processing unit	2
3	Structural detail of chironjee processing unit	3 - 8
4	Electrical layout of chironjee processing unit	9
B	NEEM / MAHUA / KUSUM / GROUND- NUT OIL PROCESSING UNIT	
5	Architectural plan of neem / mahua / kusum / ground - nut oil processing unit	10
6	Elevation and section of neem / mahua / kusum / ground - nut oil processing unit	11
7	Structural detail of neem / mahua / kusum / ground - nut oil processing unit	12 - 17
8	Electrical layout of neem / mahua / kusum / ground - nut oil processing unit	18
C	MASALA PROCESSING UNIT	
9	Architectural plan of masala processing unit	19
10	Elevation and section of masala processing unit	20
11	Structural detail of masala processing unit	21 - 26
12	Electrical layout of masala processing unit	27
D	PRIMARY PROCESSING UNIT	
13	Architectural plan of primary processing unit	28
14	Elevation and section of primary processing unit	29
15	Structural detail of primary processing unit	30 - 35
16	Electrical layout of primary processing unit	36
	PACKAGE - B	
E	LAC PROCESSING UNIT	
17	Architectural plan of lac processing unit	37
18	Elevation and section of lac processing unit	38
19	Structural detail of lac processing unit	39 - 44
20	Electrical layout of lac processing unit	45
F	PULSE MILLING UNIT	
21	Architectural plan of pulse milling unit	46
22	Elevation and section of pulse milling unit	47
23	Structural detail of pulse milling unit	48 - 53
24	Electrical layout of pulse milling unit	54
G	OHT - 50 KL CAPACITY	
25	Architectural plan of oht - 50kl capacity	55
26	section of oht - 50kl capacity	56
27	Structural detail of oht - 50kl capacity	57
H	EXTERNAL ELECTRIFICATION	

28	Electrical layout of external electrification	58
	PACKAGE - C	
I	WAREHOUSE	
29	Architectural plan of warehouse	59
30	Elevation and section of warehouse	60
31	Structural detail of warehouse	61 - 66
32	Electrical layout of warehouse	67
J	ENTRANCE GATE	
33	Architectural plan / Elevation of entrance gate	68
K	TOILET BLOCK , SEPTIC TANK & SOAK PIT	
34	Architectural plan of toilet	69
35	Elevation and section of toilet	70
36	Structural detail of toilet	71 - 75
37	Electrical layout of toilet	76
38	Architectural plan / section / structural detail of septic tank & soak pit	77

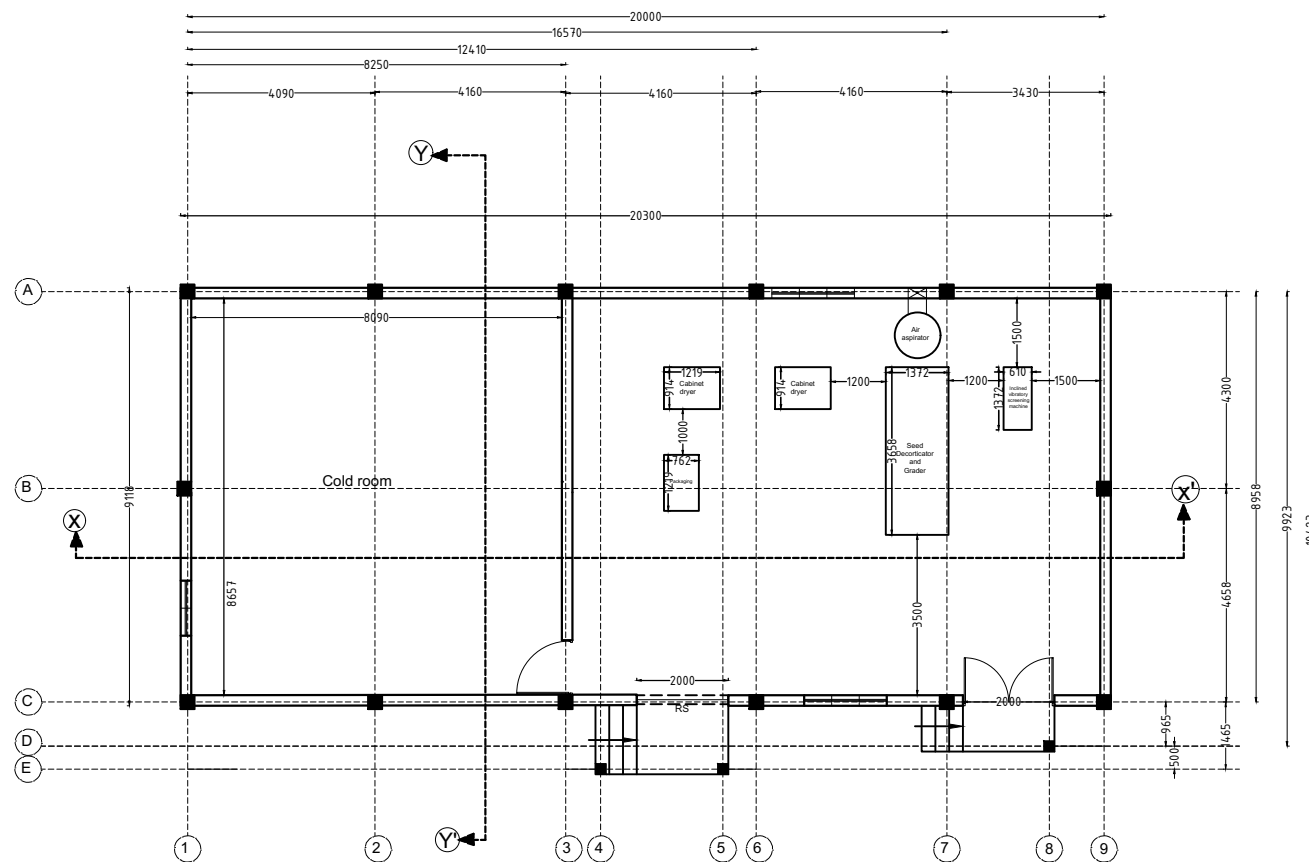

CHIRONJEE PROCESSING UNIT
BUILD UP AREA - 192 SQM

- LIST OF DRAWING
PULSE MILLING UNIT
DP0001 DRG CL 01 102**
- 1 - PLAN LAYOUT
 - 2 - SECTION / ELEVATION
 - 3 - COLUMN LAYOUT
 - 4 - FOOTING LAYOUT
 - 5 - GROUND BEAM LAYOUT
 - 6 - BEAM LAYOUT (2.5 M ABOVE)
 - 7 - BEAM LAYOUT (4.5 M ABOVE)
 - 8 - TRUSS DETAIL
 - 9 - ELECTRICAL LAYOUT

OPENING SCHEDULE

NAME	SAYMBOL
WINDOW	- W1
VENTILATOR	- V1
ROLLING SHUTTER	- R1
DOOR	- D1





SN	SAYMBOL	NOS	SIZE
01	W1	02	1.8M X 1.5M
02	V1	03	1.8 M X 1 M
03	R1	01	2.5M X 2.4 M
04	D2	01	2M X 2.1M

DRG NO:	SHEET NO:	REV.	SCALE:
DP0001 DRG CL 01 102	1 OF 9	R0	NTS
DESIGNED:	DRAWN:	CHECKED:	VERIFIED:
UPENDRA SINGH	SIMRAN SONI	UPENDRA SINGH	ADMIN
ISSUED FOR:	UNIT:	DATE:	
TENDOR PURPOSE	MILIMETER	12.05.2022	


SWATI Architecture landscape interior ARCHITECTS PLANERS ENGINEERING INTERIOR DESIGN 282 , tulip , A block , Talpuri International colony , Bhilai , C.G. Email - swati.arch@outlook.com
CLIENT: CHHATTISGARH STATE MINOR FOREST PRODUCE
PROJECT: INCUBATION CENTER AT DEOBHOG GARIYABAND

This drawing is the property of HUP DESIGN and is to be used only for the purpose for which it was lent and must not be in any way detrimental to the interest of the company and is subject to return on demand


TITLE: CHIRONJEE PROCESSING UNIT PLAN LAYOUT	1
--	----------

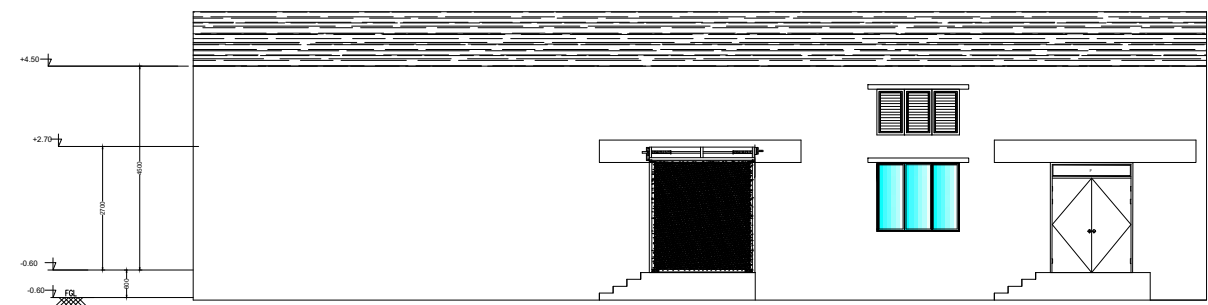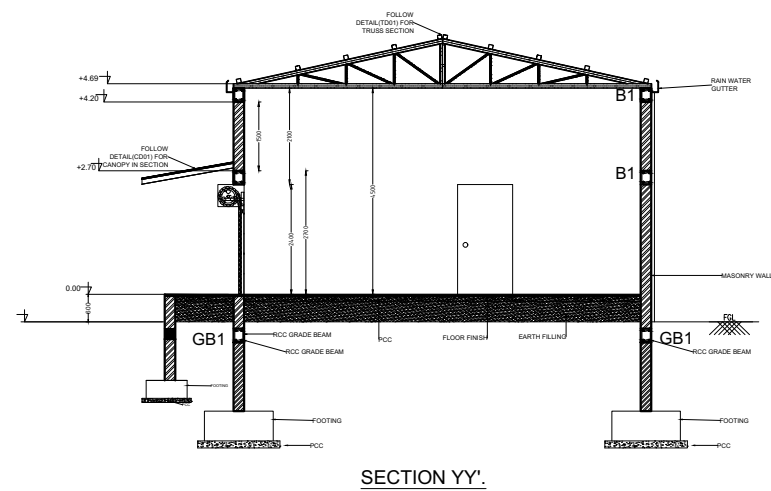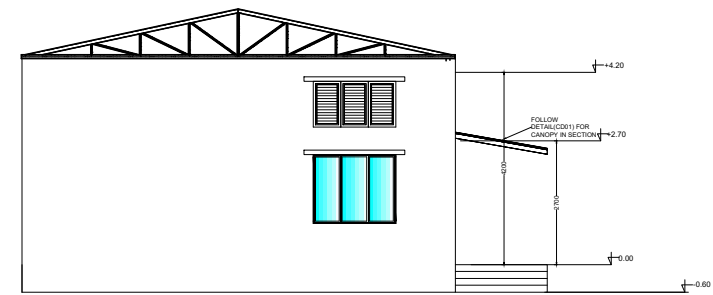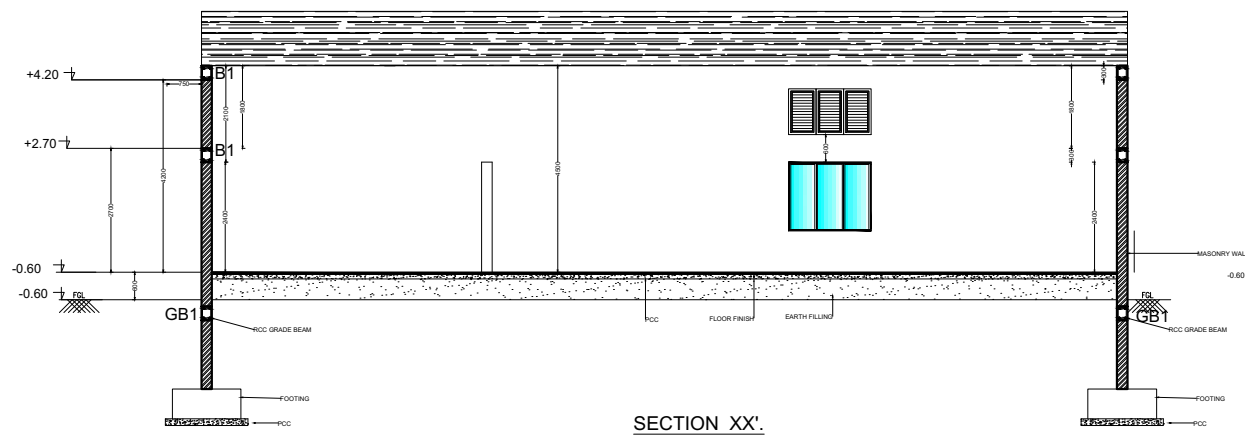

DRG NO: DP0001 DRG CL 01 102	SHEET NO: 2 OF 9	REV. R0	SCALE: NTS	SWATI Architecture landscape interior ARCHITECTS PLANERS ENGINEERING INTERIOR DESIGN 282 , tulip , A block , Talpuri International colony , Bhilai , C.G. Email - swati.arch@outlook.com	
DESIGNED: UPENDRA SINGH	DRAWN: SIMRAN SONI	CHECKED: UPENDRA SINGH	VERIFIED: ADMIN	APPROVED: ADMIN	CLIENT: CHHATTISGARH STATE MINOR FOREST PRODUCE
ISSUED FOR: TENDOR PURPOSE		UNIT: MILIMETER	DATE: 12.05.2022	PROJECT: INCUBATION CENTER AT DEOBHOG GARIYABAND	TITLE: CHIRONJEE PROCESSING UNIT SECTION/ ELEVATION
This drawing is the property of HUP DESIGN and is to be used only for the purpose for which it was lent and must not be in any way detrimental to the interest of the company and is subject to return on demand					2

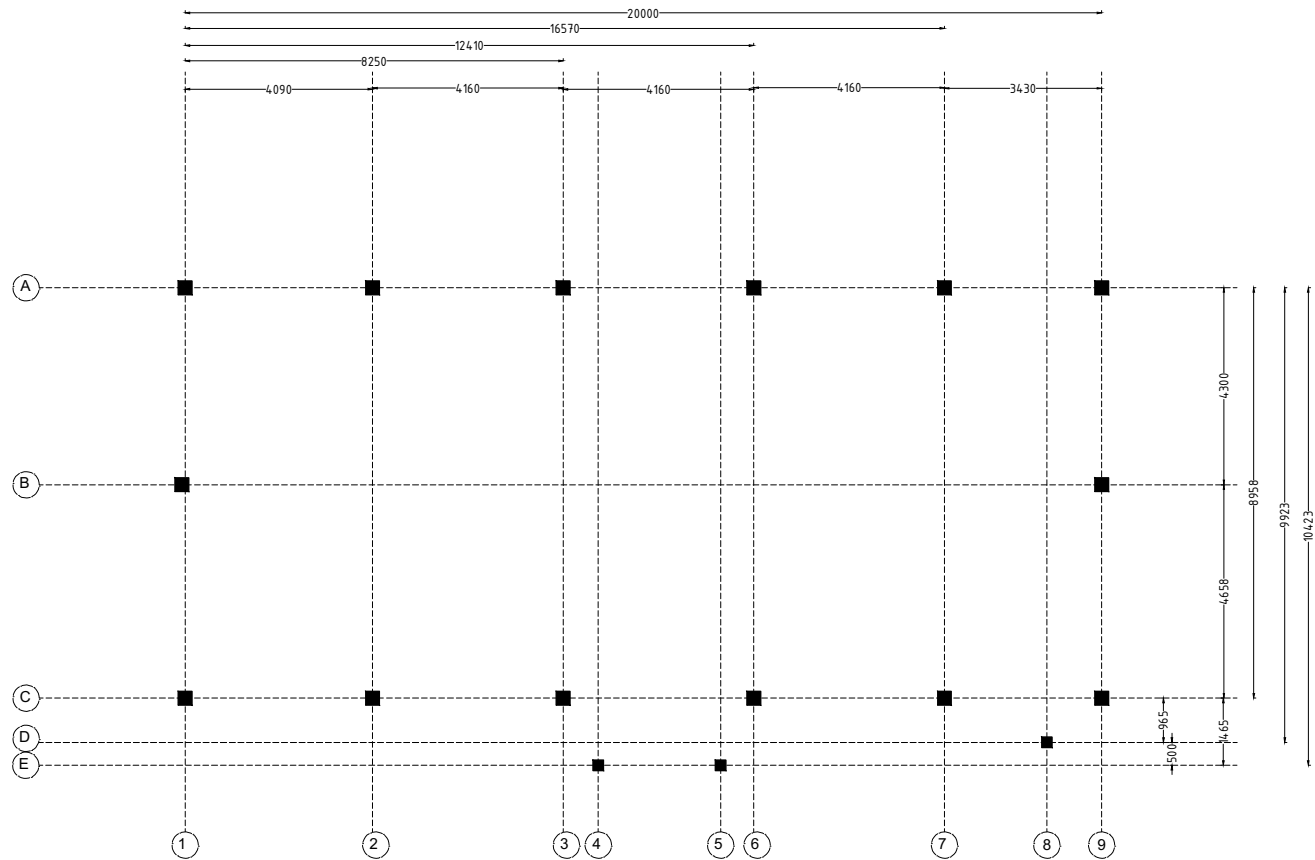

COLUMN LAYOUT PLAN

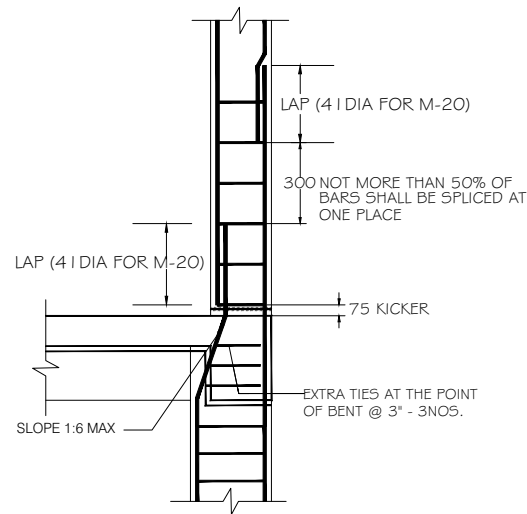

COLUMN DETAIL


GENERAL NOTES

- NOTES-
- USE - M 20 GRADE OF CONC. AS/IS 426-5000
 - USE - FE 500 GRADE OF REINF. BY CLIENT
 - PROVIDE CLEAR COVER TO MAIN REINF.
- FOUNDATION- 50MM
COLUMN - 40MM
BEAM - 25MM
SLAB - 20MM OR DIA OF BAR, WHICHEVER IS MORE,
R.C.C. WALL - 25MM
- 4.TIES SHOULD BE BEND INSIDE WITH 10# LENGTH IN BEAM & COLUMN
- 5.FOLLOW - IS-456-2000 FOR R.C.C. WORK
- 6.STRIPPING TIME FOR SHUTTERING / FORMWORK UNDER NORMAL CONDITION.
- | TYPE OF WORK | MINIMUM PERIOD BEFORE STRIKING FORM WORK |
|--|--|
| a) VERTICAL FORMWORK TO COLUMN, WALLS, BEAM | 16-24 HOUR |
| b) SOFFITS FORMWORK TO SLABS (PROPS TO BE REFIXED- IMMEDIATELY AFTER REMOVAL OF FORMWORK) | 3 DAYS |
| c) SOFFIT FORMWORK TO BEAMS (PROPS TO BE REFIXED IMMEDIATELY AFTER REMOVAL OF FORMWORK) | 7DAYS |
| d) PROPS TO SLABS: | |
| 1) SPANNING UP TO 4.5M | 7DAYS |
| 2) SPANNING OVER 4.5M | 14 DAYS |
| e) PROPS TO BEAMS & ARCHES: | |
| 1) SPANNING UP TO 6M | 14DAYS |
| 2) SPANNING OVER 6M | 21DAYS |
- CURING FOR R.C.C. MEMBER MINIMUM 14 DAYS CONTINOUSELY PREFERABLE - 28 DAYS.
 - START EARLY CURING TO AVOID SRINKAGE CRACKS, WHEN CONCRETE APPEARS TO HARDEN.
 - PROVIDE FOLLOWING SLUMP IN CONCRETE GEN-ERALLY.
- | | |
|---|---------|
| a) SHALLOW SECTIONS, PAVMENTS, MASS CONC. LIGTH REINFORCEMENT | |
| SECTION IN SLAB, BEAM, WALL, COLUMN | 25-75 |
| b) HEAVILY REINFORCEMENT SECTION IN SLAB | 50-100 |
| c) HEAVILY REINFORCEMENT SECTION IN BEAMS, WALLS, COLUMNS SLIPFORM, OR PUMPED CONC. | 75-100 |
| d) TRENCH FILL, PILLING, PUMPED CONC. | 100-150 |
- 10) PROVIDE LAP/ DEVELOPEMENT LENGTH IN REINFORCEMENT BARS GRADE OF CONC.
- M20- 47Ø
M25-41Ø
M30-38Ø
- REFER RELEVANT DRG. WITH THIS DRG.
 - AVOID CORE CUTING.

TYPICAL COLUMN DETAIL'S

COLUMN NAME	Pile/col detail	STIRRUPS	REMARKS
C1	 8-T12 T8@ 200 c/c 2-Tie		FOUNDATION TO TERRACE
C1	 4-T12 T8@ 200 c/c 1-Tie		TERMINATE AT GROUND LVL


DRG NO: DP0001 DRG CL 01 102		SHEET NO: 3 OF 9	REV. R0	SCALE: NTS	SWATI Architecture landscape interior ARCHITECTS PLANERS ENGINEERING INTERIOR DESIGN 282 , tulip , A block , Talpuri International colony , Bhilai , C.G. Email - swati.arch@outlook.com	
DESIGNED:	DRAWN:	CHECKED:	VERIFIED:	APPROVED:	CLIENT:	CHHATTISGARH STATE MINOR FOREST PRODUSE
UPENDRA SINGH	SIMRAN SONI	UPENDRA SINGH	ADMIN	ADMIN		
ISSUED FOR: TENDOR PURPOSE		UNIT: MILIMETER	DATE: 12.05.2022	PROJECT:	INCUBATION CENTER AT DEOBHOG GARIYABAND	
This drawing is the property of HUP.DESIGN and is to be used only for the purpose for which it was lent and must not be in any way detrimental to the interest of the company and is subject to return on demand				TITLE:	CHIRONJEE PROCESSING UNIT COLUMN LAYOUT	
						3

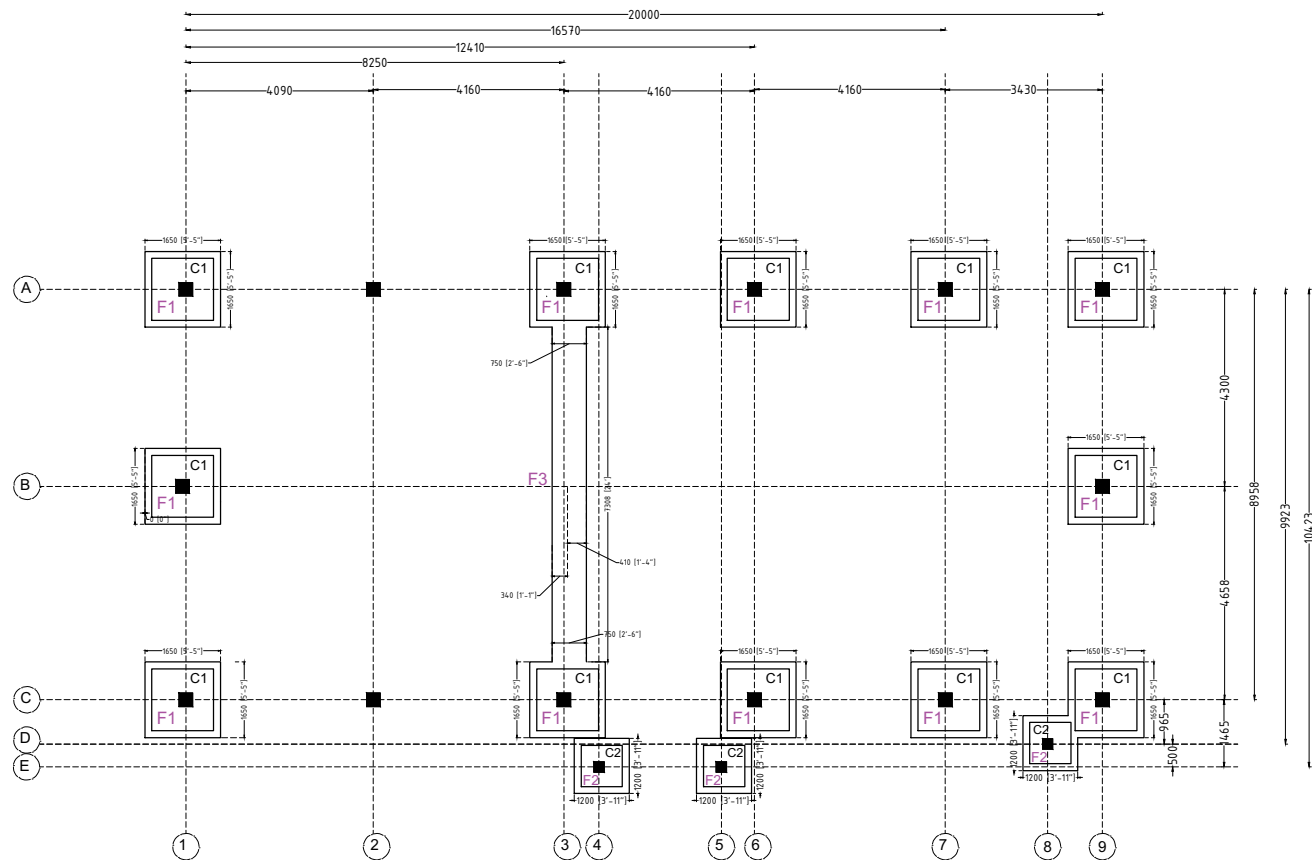


FOOTING LAYOUT

FOOTING SCHEDULE

FE500 AND M20							
Footing	Column	PCC Size	Footing Size	Total	Steel	Steel	Remarks
	Nos	X - Y mm	X - Y mm	Depth mm	to X mm	to Y mm	
F1	C1	1650 X 1650	1350 X 1350	400	T10@ 175C/C	T10@ 175 C/C	Bottom bars only
F2	C2	1200 X 1200	900 X 900	230	T8@200C/C	T8@ 200 C/C	Bottom bars only

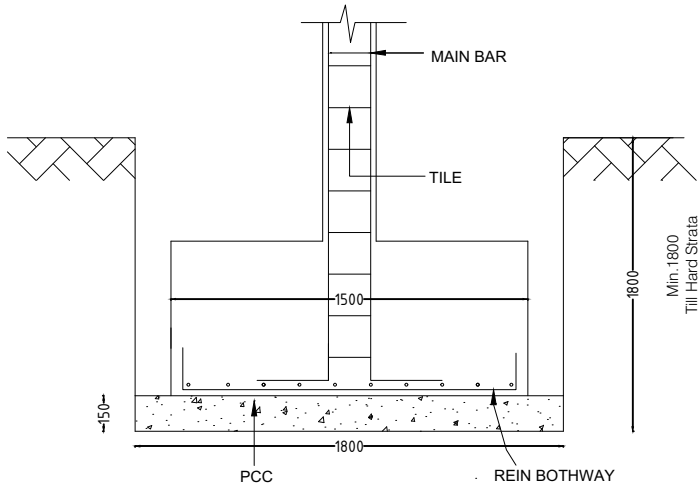

TYPICAL FOOTING SECTION (1-1')

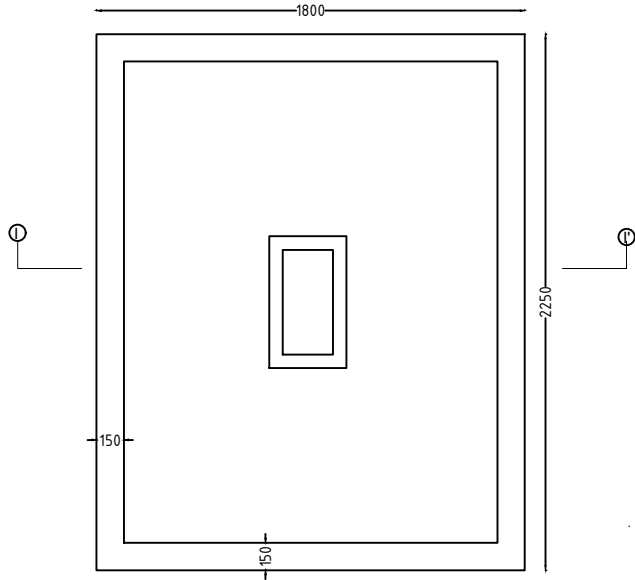

TYPICAL FOOTING PLAN

GENERAL NOTES

NOTES-

1. USE - M 20 GRADE OF CONC. AS/IS 426-5000

2. USE - FE 500 GRADE OF REINF. BY CLIENT

3. PROVIDE CLEAR COVER TO MAIN REINF.

FOUNDATION- 50MM

COLUMN - 40MM

BEAM - 25MM

SLAB - 20MM OR DIA OF BAR, WHICHEVER IS MORE,

R.C.C. WALL - 25MM

4.TIES SHOULD BE BEND INSIDE WITH 10# LENGTH IN BEAM & COLUMN

5.FOLLOW - IS-456-2000 FOR R.C.C. WORK

6.STRIPPING TIME FOR SHUTTERING / FORMWORK UNDER NORMAL CONDITION.

TYPE OF WORK

MINIMUM PERIOD BEFORE STRIKING FORM WORK

a) VERTICAL FORMWORK TO COLUMN, WALLS, BEAM

16-24 HOUR

b) SOFFITS FORMWORK TO SLABS (PROPS TO BE REFIXED- - IMMEDIATELY AFTER REMOVAL OF FORMWORK)

3 DAYS

c) SOFFIT FORMWORK TO BEAMS (PROPS TO BE REFIXED IMMEDIATELY AFTER REMOVAL OF FORMWORK)

7DAYS

d) PROPS TO SLABS:

1) SPANNING UP TO 4.5M 7DAYS

2) SPANNING OVER 4.5M 14 DAYS

e) PROPS TO BEAMS & ARCHES:

1) SPANNING UP TO 6M 14DAYS

2) SPANNING OVER 6M 21DAYS

7. CURING FOR R.C.C. MEMBER MINIMUM 14 DAYS CONTINOUSELY PREFERABLE - 28 DAYS.

8. START EARLY CURING TO AVOID SRINKAGE CRACKS, WHEN CONCRETE APPEARS TO HARDEN.

9) PROVIDE FOLLOWING SLUMP IN CONCRETE GEN- -ERALLY.

a) SHALLOW SECTIONS, PAYMENTS, MASS CONC. LIGTH REINFORCEMENT SECTION IN SLAB, BEAM, WALL, COLUMN 25-75

b) HEAVILY REINFORCEMENT SECTION IN SLAB 50-100

c) HEAVILY REINFORCEMENT SECTION IN BEAMS, WALLS, COLUMNS SLIPFORM, OR PUMPED CONC. 75-100

d) TRENCH FILL, PILLING, PUMPED CONC. 100-150

10) PROVIDE LAP/ DEVELOPEMENT LENGTH IN REINFORCEMENT BARS GRADE OF CONC.

M20- 47Ø

M25-41Ø

M30-38Ø

11) REFER RELEVANT DRG. WITH THIS DRG.

12) AVOID CORE CUTING.

DRG NO: DP0001 DRG CL 01 102

SHEET NO: 3 OF 9

REV. R0

SCALE: NTS

DESIGNED: UPENDRA SINGH

DRAWN: SIMRAN SONI

CHECKED: UPENDRA SINGH

VERIFIED: ADMIN

APPROVED: ADMIN

ISSUED FOR: TENDOR PURPOSE

UNIT: MILIMETER

DATE: 12.05.2022

CLIENT: CHHATTISGARH STATE MINOR FOREST PRODUSE

PROJECT: INCUBATION CENTER AT DEOBHOG GARIYABAND

TITLE: CHIRONJEE PROCESSING UNIT FOOTING LAYOUT


SWATI Architecture landscape interior

ARCHITECTS | PLANERS | ENGINEERING | INTERIOR DESIGN

282 , tulip , A block , Talpuri International colony , Bhilai , C.G. Email - swati.arch@outlook.com

This drawing is the property of HUP DESIGN and is to be used only for the purpose for which it was lent and must not be in any way detrimental to the interest of the company and is subject to return on demand

4

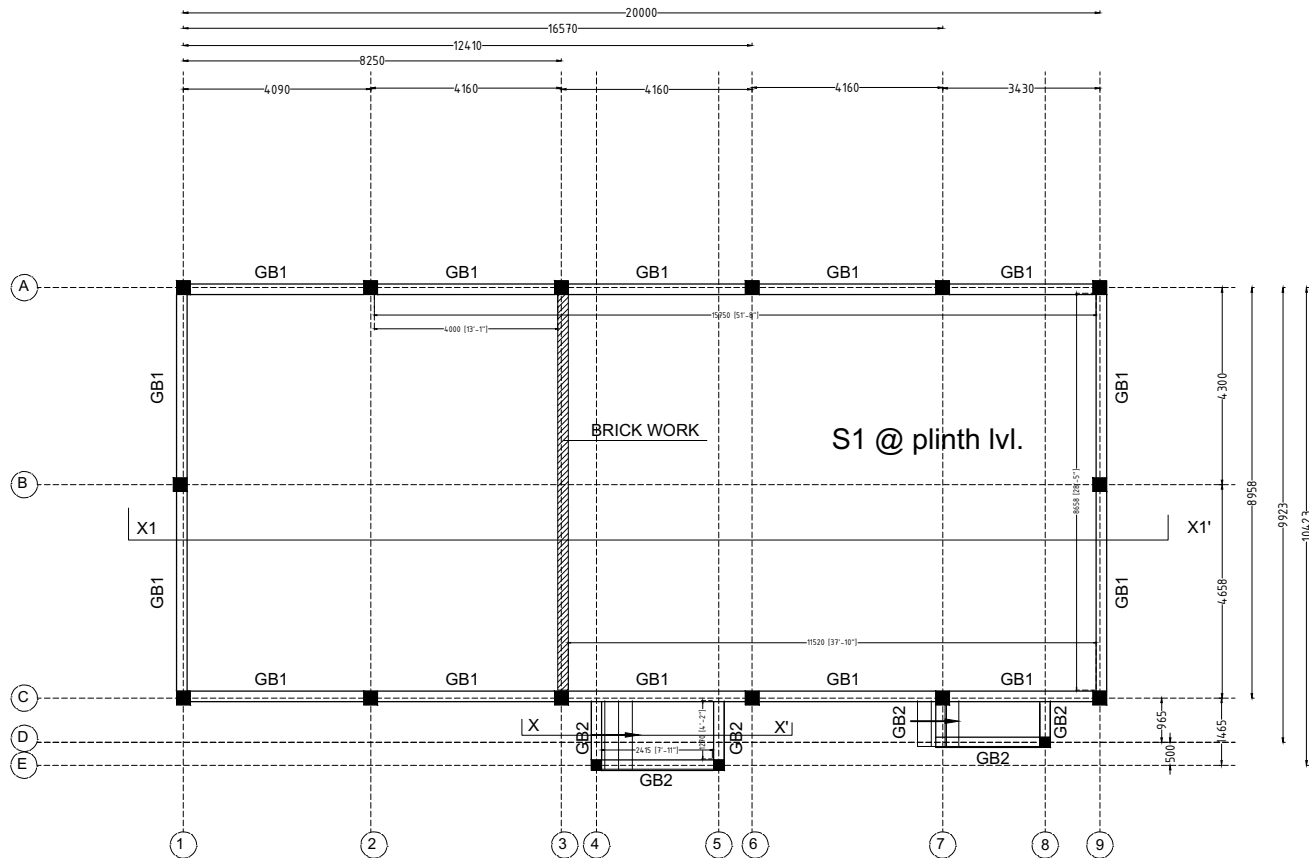


GROUND BEAM LAYOUT

BEAM SCHEDULE FOR GROUND/ PLINTH LVL.

GB1	230X375	2-T16	2-T12	2-T16	2-T12	2-T12	T8 @200C/C	T8 @175C/C	T8 @175C/C	SLAB THK. INCLUDED
GB2	230X230	2-T12	-	2-T10	-	-	T8 @200C/C	T8 @200C/C	T8 @200C/C	SLAB THK. INCLUDED

SLAB SCHEDULE FOR GROUND FLOOR LVL.

SLAB NAME	THICKNESS (mm)			remarks
		Main Steel	Other Steel	
S1	150 (MESH)	T8 @ 200 c/c	T8 @ 200 c/c	All straight

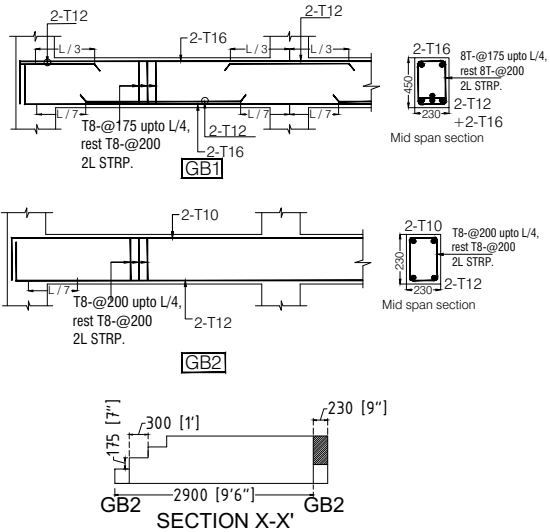


GROUND BEAM SECTIONAL DETAIL

GENERAL NOTES

NOTES-

 - USE - M 20 GRADE OF CONC. AS/IS 426-5000
 - USE - FE 500 GRADE OF REINF. BY CLIENT
 - PROVIDE CLEAR COVER TO MAIN REINF.
- FOUNDATION- 50MM
COLUMN - 40MM
BEAM - 25MM
SLAB - 20MM OR DIA OF BAR, WHICHEVER IS MORE,
R.C.C. WALL - 25MM
- TIES SHOULD BE BEND INSIDE WITH 10# LENGTH IN BEAM & COLUMN



- FOLLOW - IS-456-2000 FOR R.C.C. WORK
- STRIPPING TIME FOR SHUTTERING / FORMWORK UNDER NORMAL CONDITION.


TYPE OF WORK	MINIMUM PERIOD BEFORE STRIKING FORM WORK
--------------	--

- VERTICAL FORMWORK TO COLUMN, WALLS, BEAM 16-24 HOUR
- SOFFITS FORMWORK TO SLABS (PROPS TO BE REFIXED- IMMEDIATELY AFTER REMOVAL OF FORMWORK) 3 DAYS
- SOFFIT FORMWORK TO BEAMS (PROPS TO BE REFIXED IMMEDIATELY AFTER REMOVAL OF FORMWORK) 7DAYS
- PROPS TO SLABS:
 - 1) SPANNING UP TO 4.5M 7DAYS
 - 2) SPANNING OVER 4.5M 14 DAYS
- PROPS TO BEAMS & ARCHES:
 - 1) SPANNING UP TO 6M 14DAYS
 - 2) SPANNING OVER 6M 21DAYS

- CURING FOR R.C.C. MEMBER MINIMUM 14 DAYS CONTINUOUSLY PREFERABLE - 28 DAYS.
- START EARLY CURING TO AVOID SRINKAGE CRACKS, WHEN CONCRETE APPEARS TO HARDEN.
- PROVIDE FOLLOWING SLUMP IN CONCRETE GENERALLY.
 - SHALLOW SECTIONS, PAYMENTS, MASS CONC. LIGTH REINFORCEMENT SECTION IN SLAB, BEAM, WALL, COLUMN 25-75
 - HEAVILY REINFORCEMENT SECTION IN SLAB 50-100
 - HEAVILY REINFORCEMENT SECTION IN BEAMS, WALLS, COLUMNS SLIPFORM, OR PUMPED CONC. 75-100
 - TRENCH FILL, PILLING, PUMPED CONC. 100-150
- PROVIDE LAP/ DEVELOPEMENT LENGTH IN REINFORCEMENT BARS GRADE OF CONC.

- REFER RELEVANT DRG. WITH THIS DRG.
- AVOID CORE CUTING.


DRG NO:	SHEET NO:	REV.	SCALE:	SWATI Architecture landscape interior ARCHITECTS PLANERS ENGINEERING INTERIOR DESIGN 282 , tulip , A block , Talpuri International colony , Bhilai , C.G. Email - swati.arch@outlook.com	
DP0001 DRG CL 01 102	5 OF 9	R0	NTS		
DESIGNED:	DRAWN:	CHECKED:	VERIFIED:	APPROVED:	CLIENT:
UPENDRA SINGH	SIMRAN SONI	UPENDRA SINGH	ADMIN	ADMIN	CHHATTISGARH STATE MINOR FOREST PRODUCE
ISSUED FOR:		UNIT:	DATE:	PROJECT:	
TENDOR PURPOSE		MILIMETER	12.05.2022	INCUBATION CENTER AT DEOBHOG GARIYABAND	
This drawing is the property of HUP DESIGN and is to be used only for the purpose for which it was lent and must not be in any way detrimental to the interest of the company and is subject to return on demand				TITLE:	
				CHIRONJEE PROCESSING UNIT BEAM LAYOUT	5

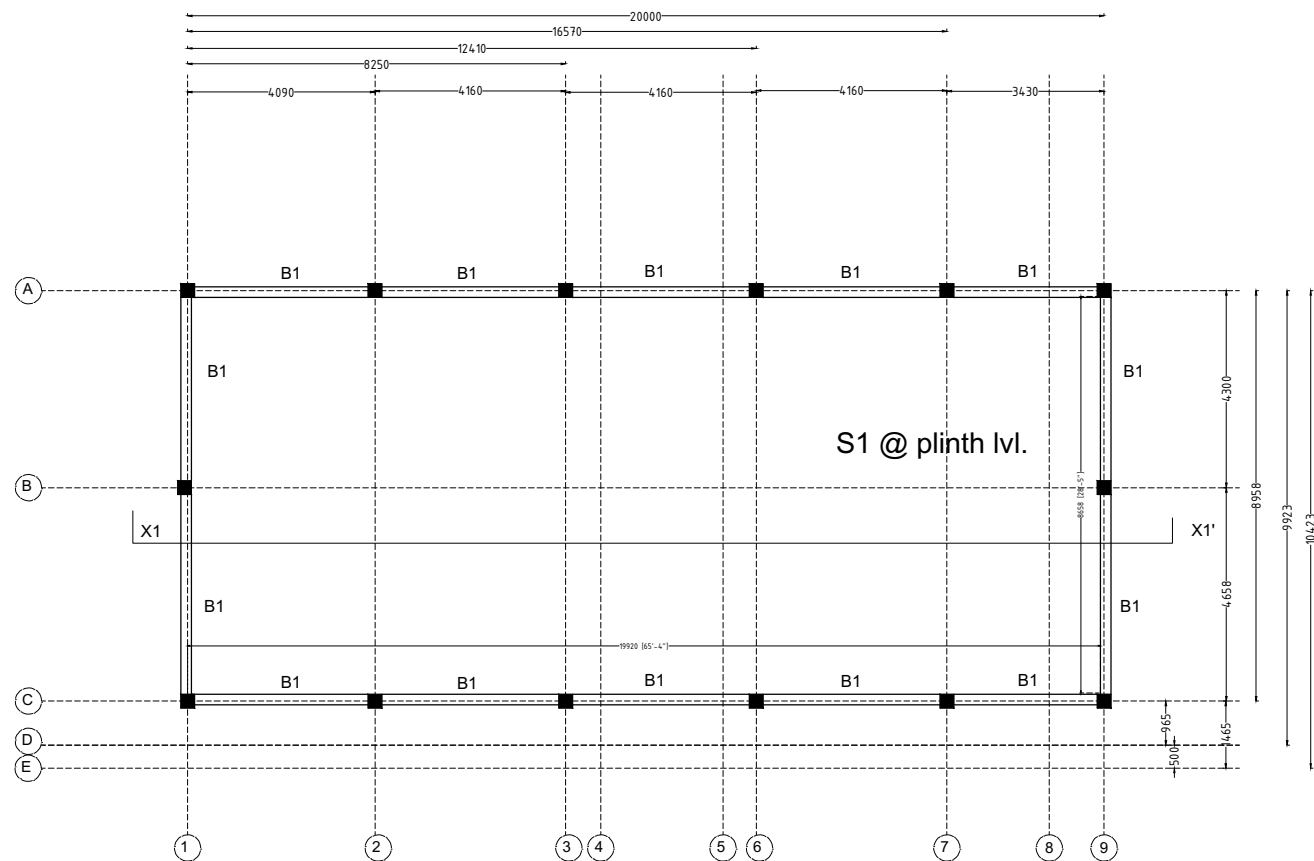

BEAM PLAN(2.4 m ABOVE PLINTH LVL)

BEAM SCHEDULE FOR 2.4m LVL. ABOVE PLINTH


B1	230X300	2-T12	2-T12	2-T12	2-T12	2-T12	T8 @200C/C	T8 @175C/C	T8 @175C/C	SLAB THK. INCLUDED

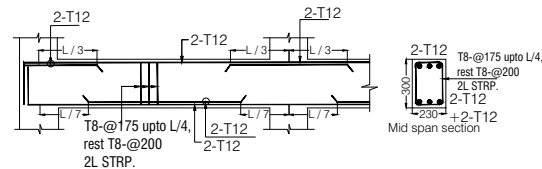

GENERAL NOTES

NOTES-

 1. USE - M 20 GRADE OF CONC. AS/IS 426-5000
 2. USE - FE 500 GRADE OF REINF. BY CLIENT
 3. PROVIDE CLEAR COVER TO MAIN REINF.
- FOUNDATION- 50MM
COLUMN - 40MM
BEAM - 25MM
SLAB - 20MM OR DIA OF BAR, WHICHEVER IS MORE,
R.C.C. WALL - 25MM
- 4.TIES SHOULD BE BEND INSIDE WITH 10# LENGTH IN BEAM & COLUMN




- 5.FOLLOW - IS-456-2000 FOR R.C.C. WORK
- 6.STRIPPING TIME FOR SHUTTERING / FORMWORK UNDER NORMAL CONDITION.


TYPE OF WORK	MINIMUM PERIOD BEFORE STRIKING FORM WORK
a) VERTICAL FORMWORK TO COLUMN, WALLS, BEAM	16-24 HOUR
b) SOFFITS FORMWORK TO SLABS (PROPS TO BE REFIXED- IMMEDIATELY AFTER REMOVAL OF FORMWORK)	3 DAYS
c) SOFFIT FORMWORK TO BEAMS (PROPS TO BE REFIXED IMMEDIATELY AFTER REMOVAL OF FORMWORK)	7DAYS
d) PROPS TO SLABS:	
1) SPANNING UP TO 4.5M	7DAYS
2) SPANNING OVER 4.5M	14 DAYS
e) PROPS TO BEAMS & ARCHES:	
1) SPANNING UP TO 6M	14DAYS
2) SPANNING OVER 6M	21DAYS

7. CURING FOR R.C.C. MEMBER MINIMUM 14 DAYS CONTINOUSELY PREFERABLE - 28 DAYS.
8. START EARLY CURING TO AVOID SRINKAGE CRACKS, WHEN CONCRETE APPEARS TO HARDEN.
- 9) PROVIDE FOLLOWING SLUMP IN CONCRETE GEN-ERALLY.
- a) SHALLOW SECTIONS, PAYMENTS, MASS CONC. LIGTH REINFORCEMENT SECTION IN SLAB, BEAM, WALL, COLUMN 25-75
- b) HEAVILY REINFORCEMENT SECTION IN SLAB 50-100
- c) HEAVILY REINFORCEMENT SECTION IN BEAMS, WALLS, COLUMNS SLIPFORM, OR PUMPED CONC. 75-100
- d) TRENCH FILL, PILLING, PUMPED CONC. 100-150
- 10) PROVIDE LAP/ DEVELOPEMENT LENGTH IN REINFORCEMENT BARS GRADE OF CONC.
- M20- 47Ø
- M25-41Ø
- M30-38Ø
- 11) REFER RELEVANT DRG. WITH THIS DRG.
- 12) AVOID CORE CUTING.

DRG NO: DP0001 DRG CL 01 102	SHEET NO: 3 OF 9	REV. R0	SCALE: NTS	SWATI Architecture landscape interior ARCHITECTS PLANERS ENGINEERING INTERIOR DESIGN 282 , tulip , A block , Talpuri International colony , Bhilai , C.G. Email - swati.arch@outlook.com	
DESIGNED: UPENDRA SINGH	DRAWN: SIMRAN SONI	CHECKED: UPENDRA SINGH	VERIFIED: ADMIN	APPROVED: ADMIN	CLIENT: CHHATTISGARH STATE MINOR FOREST PRODUCE
ISSUED FOR: TENDOR PURPOSE	UNIT: MILIMETER	DATE: 12.05.2022	PROJECT: INCUBATION CENTER AT DEOBHOG GARIYABAND		
This drawing is the property of HUP DESIGN and is to be used only for the purpose for which it was lent and must not be in any way detrimental to the interest of the company and is subject to return on demand				TITLE: CHIRONJEE PROCESSING UNIT BEAM LAYOUT	6

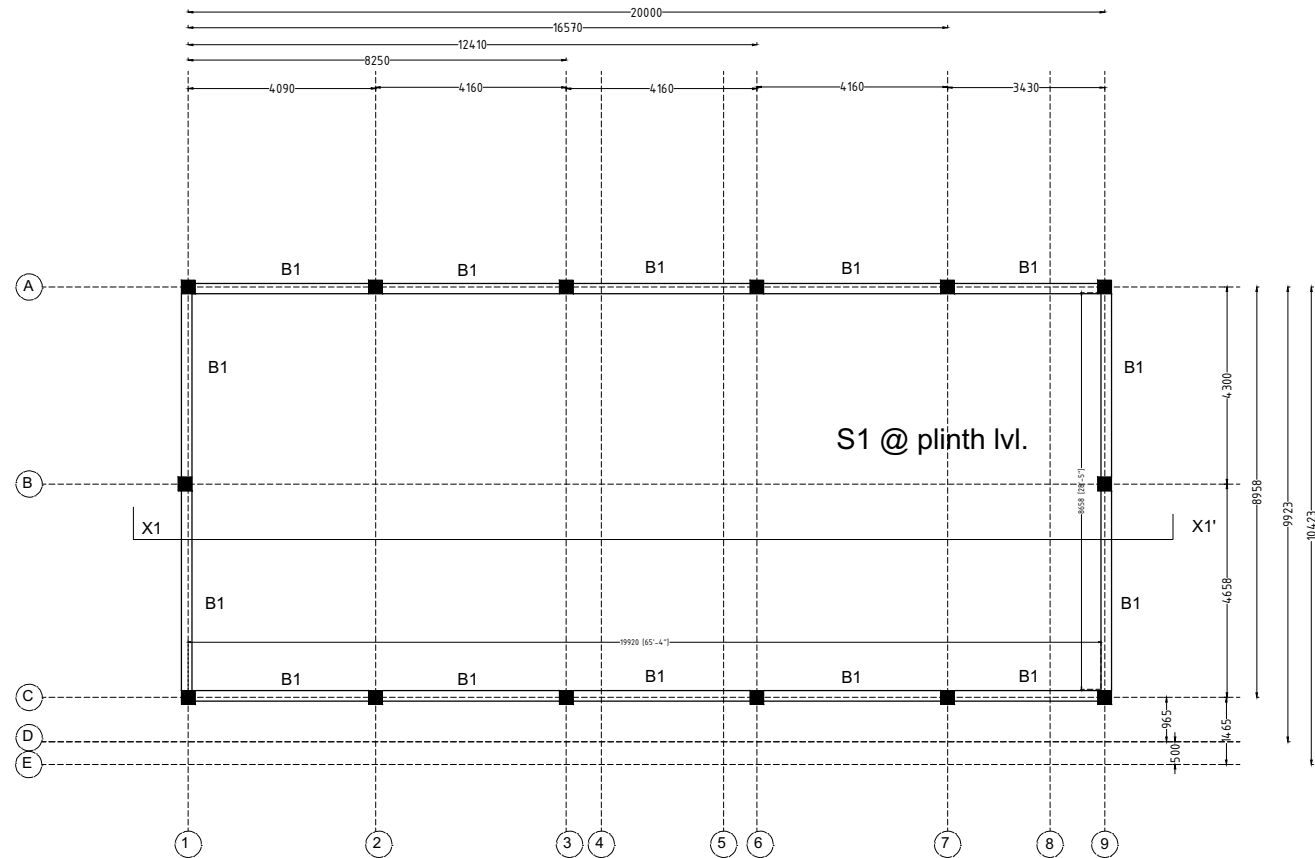

BEAM PLAN (4.5 ABOVE PLINTH LVL)

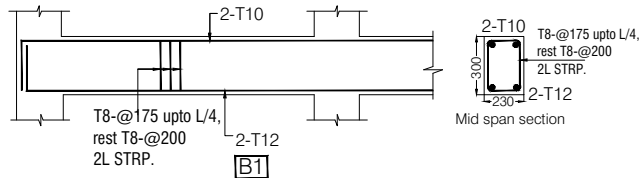


BEAM SCHEDULE FOR 4.5m LVL. ABOVE PLINTH

Beam ID	Size	Top Reinforcement			Bottom Reinforcement			Stirrups			Slab Thickness Included
		Bar	Spacing	Notes	Bar	Spacing	Notes	Bar	Spacing	Notes	
B1	230X300	2-T12	-		2-T10	-		T8 @200C/C	T8 @175C/C	T8 @175C/C	SLAB THK. INCLUDED


GENERAL NOTES

- NOTES-
- USE - M 20 GRADE OF CONC. AS/IS 426-5000
 - USE - FE 500 GRADE OF REINF. BY CLIENT
 - PROVIDE CLEAR COVER TO MAIN REINF.
- FOUNDATION- 50MM
COLUMN - 40MM
BEAM - 25MM
SLAB - 20MM OR DIA OF BAR, WHICHEVER IS MORE,
R.C.C. WALL - 25MM
- TIES SHOULD BE BEND INSIDE WITH 10# LENGTH IN BEAM & COLUMN
- 5.FOLLOW - IS-456-2000 FOR R.C.C. WORK
6.STRIPPING TIME FOR SHUTTERING / FORMWORK UNDER NORMAL CONDITION.
- TYPE OF WORK MINIMUM PERIOD BEFORE STRIKING FORM WORK
- VERTICAL FORMWORK TO COLUMN, WALLS, BEAM 16-24 HOUR
 - SOFFITS FORMWORK TO SLABS (PROPS TO BE REFIXED- IMMEDIATELY AFTER REMOVAL OF FORMWORK) 3 DAYS
 - SOFFIT FORMWORK TO BEAMS (PROPS TO BE REFIXED IMMEDIATELY AFTER REMOVAL OF FORMWORK) 7DAYS
 - PROPS TO SLABS:
 - 1) SPANNING UP TO 4.5M 7DAYS
 - 2) SPANNING OVER 4.5M 14 DAYS
 - PROPS TO BEAMS & ARCHES:
 - 1) SPANNING UP TO 6M 14DAYS
 - 2) SPANNING OVER 6M 21DAYS
7. CURING FOR R.C.C. MEMBER MINIMUM 14 DAYS CONTINOUSELY PREFERABLE - 28 DAYS.
8. START EARLY CURING TO AVOID SRINKAGE CRACKS, WHEN CONCRETE APPEARS TO HARDEN.
9) PROVIDE FOLLOWING SLUMP IN CONCRETE GEN-ERALLY.
 - SHALLOW SECTIONS, PAYMENTS, MASS CONC. LIGTH REINFORCEMENT SECTION IN SLAB, BEAM, WALL, COLUMN 25-75
 - HEAVILY REINFORCEMENT SECTION IN SLAB 50-100
 - HEAVILY REINFORCEMENT SECTION IN BEAMS, WALLS, COLUMNS SLIPFORM, OR PUMPED CONC. 75-100
 - TRENCH FILL, PILLING, PUMPED CONC. 100-150
- 10) PROVIDE LAP/ DEVELOPEMENT LENGTH IN REINFORCEMENT BARS GRADE OF CONC.
M20- 47Ø
M25-41Ø
M30-38Ø
- 11) REFER RELEVANT DRG. WITH THIS DRG.
12) AVOID CORE CUTING.


DRG NO: DP0001 DRG CL 01 102		SHEET NO: 3 OF 9	REV. R0	SCALE: NTS	SWATI Architecture landscape interior ARCHITECTS PLANERS ENGINEERING INTERIOR DESIGN 282 , tulip , A block , Talpuri International colony , Bhilai , C.G. Email - swati.arch@outlook.com	
DESIGNED:	DRAWN:	CHECKED:	VERIFIED:	APPROVED:	CLIENT:	CHHATTISGARH STATE MINOR FOREST PRODUSE
UPENDRA SINGH	SIMRAN SONI	UPENDRA SINGH	ADMIN	ADMIN		
ISSUED FOR: TENDOR PURPOSE		UNIT: MILIMETER	DATE: 12.05.2022	PROJECT:	INCUBATION CENTER AT DEOBHOG GARIYABAND	
This drawing is the property of HUP.DESIGN and is to be used only for the purpose for which it was lent and must not be in any way detrimental to the interest of the company and is subject to return on demand				TITLE:	CHIRONJEE PROCESSING UNIT BEAM LAYOUT	
					7	

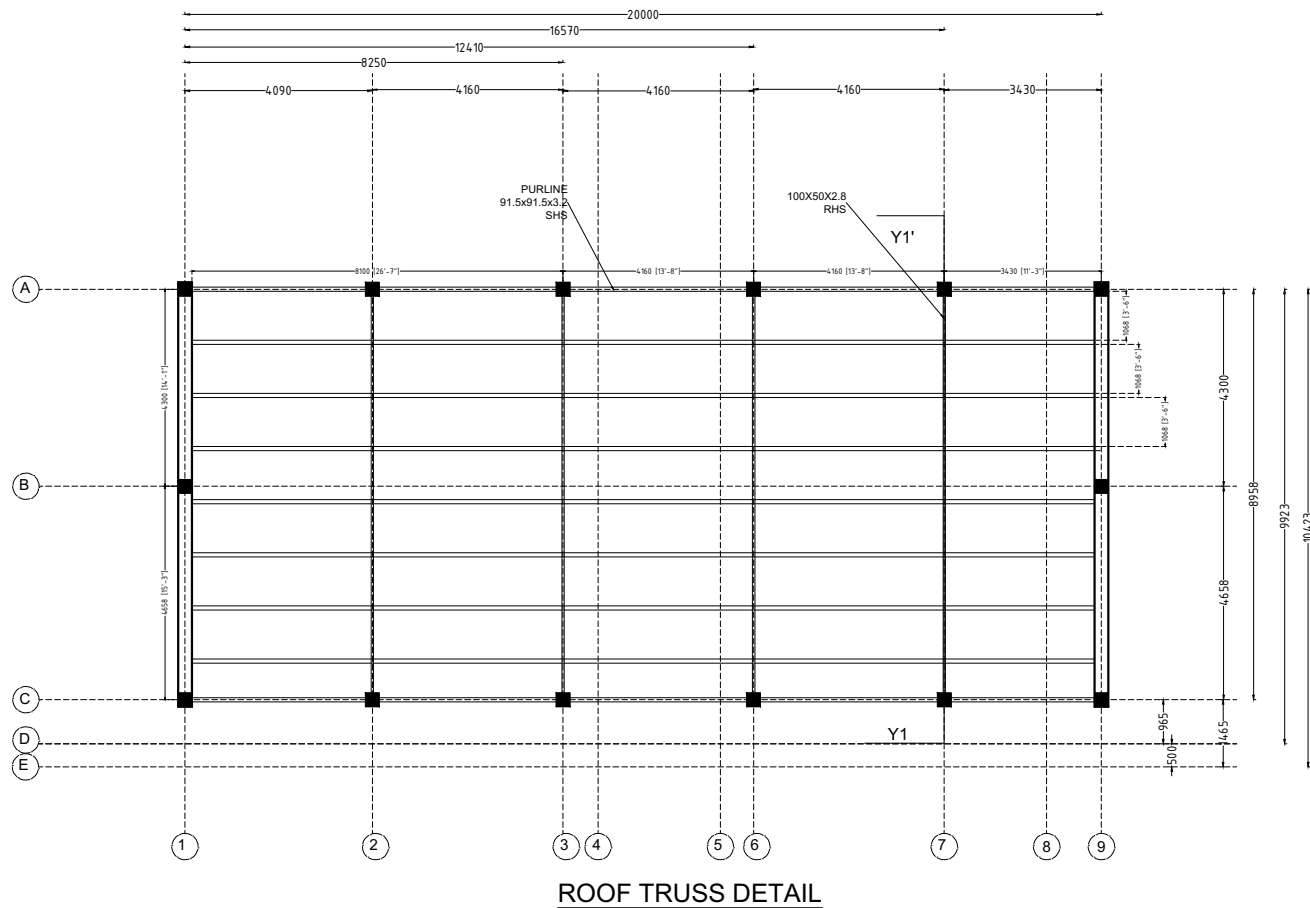


ROOF TRUSS DETAIL

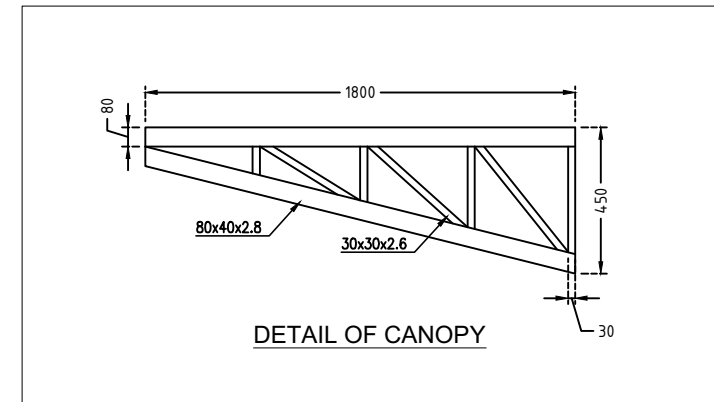

DETAIL OF CANOPY

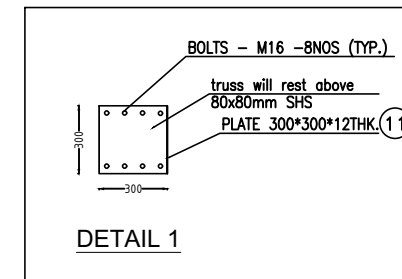

DETAIL 1

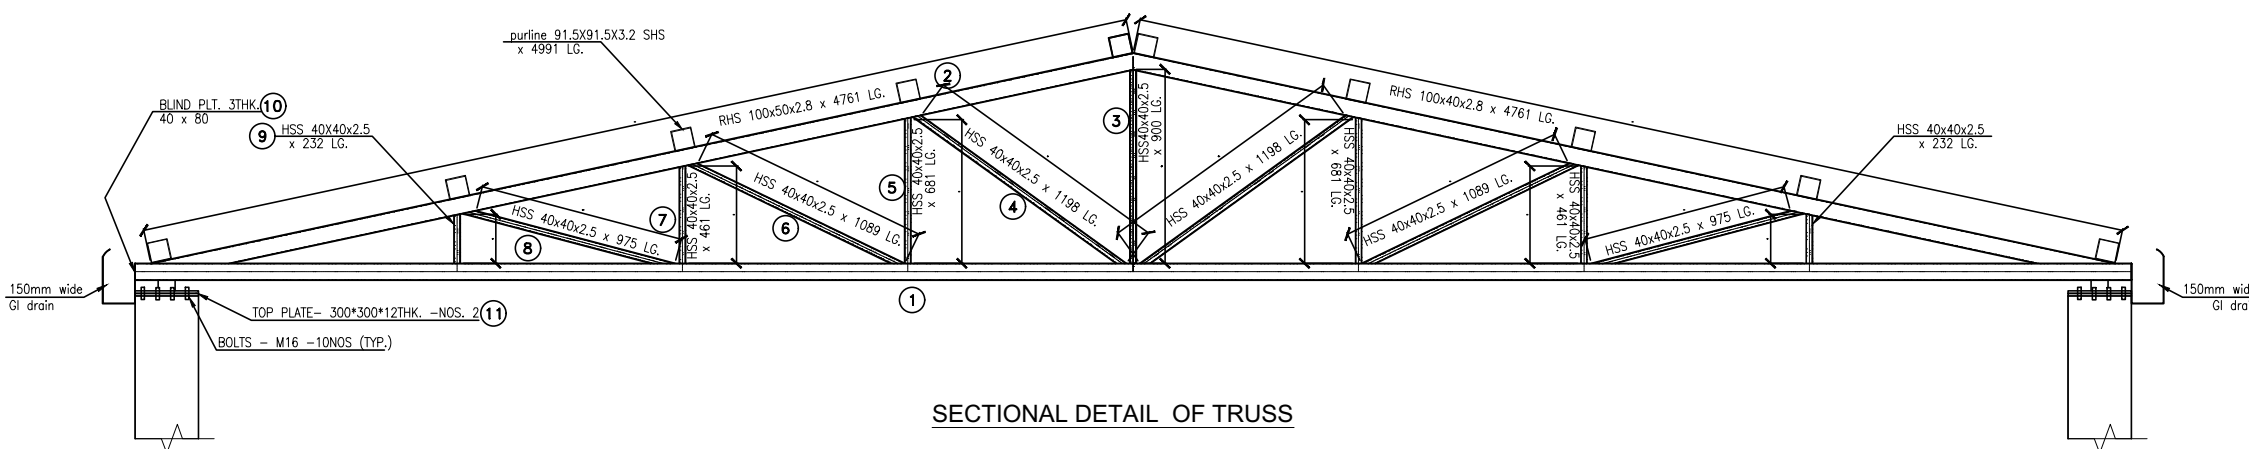


SECTIONAL DETAIL OF TRUSS

GENERAL NOTES

NOTES-

1. USE - M 20 GRADE OF CONC. AS/IS 426-5000
2. USE - FE 500 GRADE OF REINF. BY CLIENT
3. PROVIDE CLEAR COVER TO MAIN REINF.

 FOUNDATION- 50MM
COLUMN - 40MM
BEAM - 25MM
SLAB - 20MM OR DIA OF BAR, WHICHEVER IS MORE,
R.C.C. WALL - 25MM
4.TIES SHOULD BE BEND INSIDE WITH 10# LENGTH
IN BEAM & COLUMN



- 5.FOLLOW - IS-456-2000 FOR R.C.C. WORK
- 6.STRIPPING TIME FOR SHUTTERING / FORMWORK UNDER NORMAL CONDITION.

TYPE OF WORK	MINIMUM PERIOD BEFORE STRIKING FORM WORK
--------------	--

- | | |
|--|------------|
| a) VERTICAL FORMWORK TO COLUMN, WALLS, BEAM | 16-24 HOUR |
| b) SOFFITS FORMWORK TO SLABS (PROPS TO BE REFIXED- - IMMEDIATELY AFTER REMOVAL OF FORMWORK) | 3 DAYS |
| c) SOFFIT FORMWORK TO BEAMS (PROPS TO BE REFIXED IMMEDIATELY AFTER REMOVAL OF FORMWORK) | 7DAYS |
| d) PROPS TO SLABS: | |
| 1) SPANNING UP TO 4.5M | 7DAYS |
| 2) SPANNING OVER 4.5M | 14 DAYS |
| e) PROPS TO BEAMS & ARCHES: | |
| 1) SPANNING UP TO 6M | 14DAYS |
| 2) SPANNING OVER 6M | 21DAYS |

7. CURING FOR R.C.C. MEMBER MINIMUM 14 DAYS CONTINUOUSLY PREFERABLE - 28 DAYS.
8. START EARLY CURING TO AVOID SRINKAGE CRACKS, WHEN CONCRETE APPEARS TO HARDEN.
- 9) PROVIDE FOLLOWING SLUMP IN CONCRETE GENERALLY.

- | | |
|---|---------|
| a) SHALLOW SECTIONS, PAYMENTS, MASS CONC. LIGTH REINFORCEMENT SECTION IN SLAB, BEAM, WALL, COLUMN | 25-75 |
| b) HEAVY REINFORCEMENT SECTION IN SLAB | 50-100 |
| c) HEAVY REINFORCEMENT SECTION IN BEAMS, WALLS, COLUMNS SLIPFORM, OR PUMPED CONC. | 75-100 |
| d) TRENCH FILL, PILLING, PUMPED CONC. | 100-150 |

- 10) PROVIDE LAP/ DEVELOPEMENT LENGTH IN REINFORCEMENT BARS GRADE OF CONC.
- 11) REFER RELEVANT DRG. WITH THIS DRG.
- 12) AVOID CORE CUTING.

DRG NO:	SHEET NO:	REV.	SCALE:
DP0001 DRG CL 01 102	3 OF 9	R0	NTS
DESIGNED:	DRAWN:	CHECKED:	VERIFIED:
UPENDRA SINGH	SIMRAN SONI	UPENDRA SINGH	ADMIN
ISSUED FOR:	UNIT:	DATE:	
TENDOR PURPOSE	MILIMETER	12.05.2022	


SWATI Architecture landscape interior
ARCHITECTS I PLANERS I ENGINEERING I INTERIOR DESIGN
282 , tulip , A block , Talpuri International colony , Bhilai , C.G. Email - swati.arch@outlook.com

CHHATTISGARH STATE MINOR FOREST PRODUCE

INCUBATION CENTER AT DEOBHOG GARIYABAND


CHIRONJEE PROCESSING UNIT
TRUSS LAYOUT

This drawing is the property of HUP DESIGN and is to be used only for the purpose for which it was lent and must not be in any way detrimental to the interest of the company and is subject to return on demand

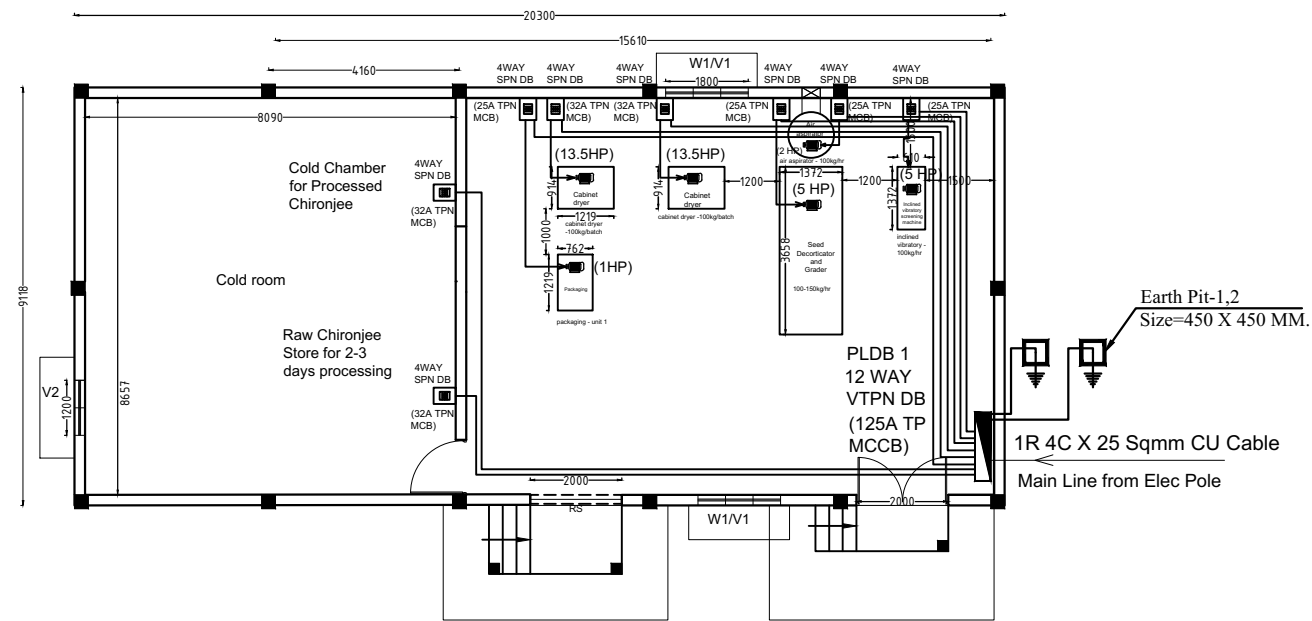

CHIRONJEE PROCESSING UNIT


01	LED 50W	50W FLOOD LIGHT (HIGH BAY)	06 No.
02	WALL LIGHT		02 No.
03	PP-1	16A SWITCH SOCKET	04 No.
04	LP-1	6A SWITCH SOCKET	01 No.
05	4WAY SPN DB	4WAY SPN DB	08 No.
06	PLDB 1 12 WAY VTPN DB		01 No.
07	1400 mm Ceiling Fan		06 No.
08	20w Led Tube Light		16 No.
09	450 mm Ex Fan		03 No.
10	LP-1	6A SWITCH SOCKET	09 No.
11	SB1	SWITCH BOARD	07 No.
12	6 X 6 SQMM CU WIRE		
13	3 X 1.5 SQMM CU WIRE		
14	Earth Pit-1 Size=450 X 450 MM.		2 SET

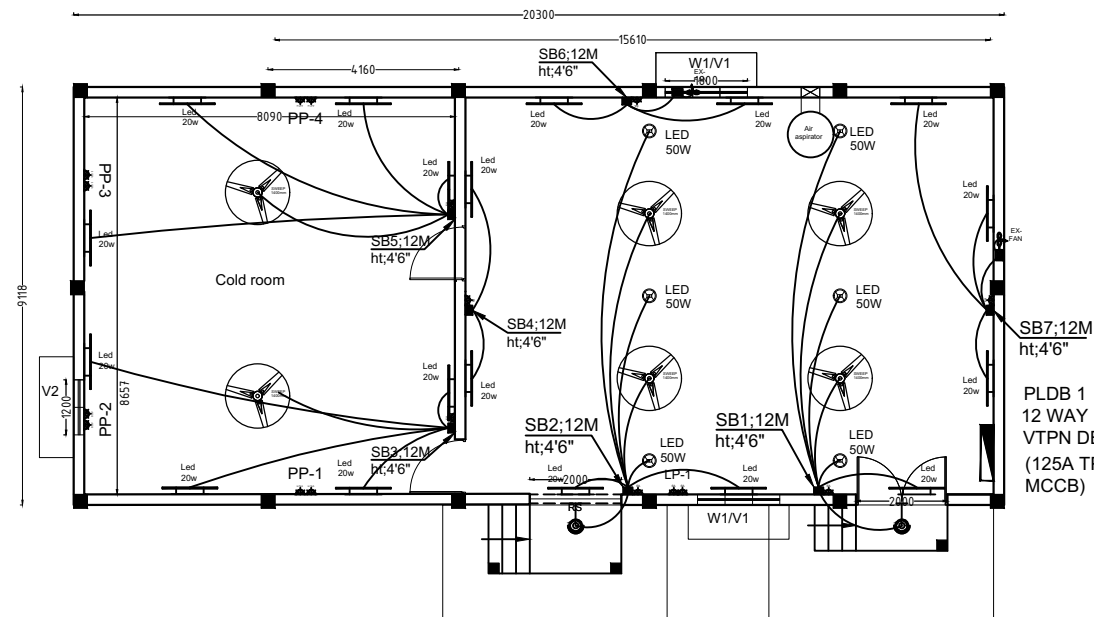

ELECTRICAL LAYOUT

MACHINE LIST			
1 - guthali grader machine(inclined vibrating) - 100kg/hr- nos 1	5 HP	6 X 6 Sqmm CU wire	
2 - chironjee decorticator and grader - 100-150kg/hr - nos 1	5 HP	6 X 6 Sqmm CU wire	
3 - cabinet dryer - 100kg/batch - nos 2	10 KW 13.5 HP	6 X 6 Sqmm CU wire	
3A - cabinet dryer - 100kg/batch - nos 2	10 KW 13.5 HP	6 X 6 Sqmm CU wire	
4 - air aspirator machine - 100kg/hr - nos1	2 HP	6 X 6 Sqmm CU wire	
5 - weighting machine -10gm - 10kg , 10kg - 250kg - nos 2	1 HP	6 X 6 Sqmm CU wire	
6 - vacuum packaging machine - nos 1	2 HP	6 X 6 Sqmm CU wire	
7 - material handling and other equipment - nos 1	1 HP		
TOTAL LOAD	3P MCCB 125A (32 KW) (83 AMP)	43 HP	1R 4C 25 Sqmm Ar. CU Cable

DRG NO: DP0001 DRG CL 01 102	SHEET NO: 3 OF 9	REV. R0	SCALE: NTS	SWATI Architecture landscape interior ARCHITECTS PLANERS ENGINEERING INTERIOR DESIGN 282 , tulip , A block , Talpuri International colony , Bhilai , C.G. Email - swati.arch@outlook.com	
DESIGNED: UPENDRA SINGH	DRAWN: SIMRAN SONI	CHECKED: UPENDRA SINGH	VERIFIED: ADMIN	APPROVED: ADMIN	CLIENT: CHHATTISGARH STATE MINOR FOREST PRODUCE
ISSUED FOR: TENDOR PURPOSE		UNIT: MILIMETER	DATE: 12.05.2022	PROJECT: INCUBATION CENTER AT DEOBHOG GARIYABAND	
This drawing is the property of HUP DESIGN and is to be used only for the purpose for which it was lent and must not be in any way detrimental to the interest of the company and is subject to return on demand					TITLE: CHIRONJEE PROCESSING UNIT ELECTRICAL LAYOUT

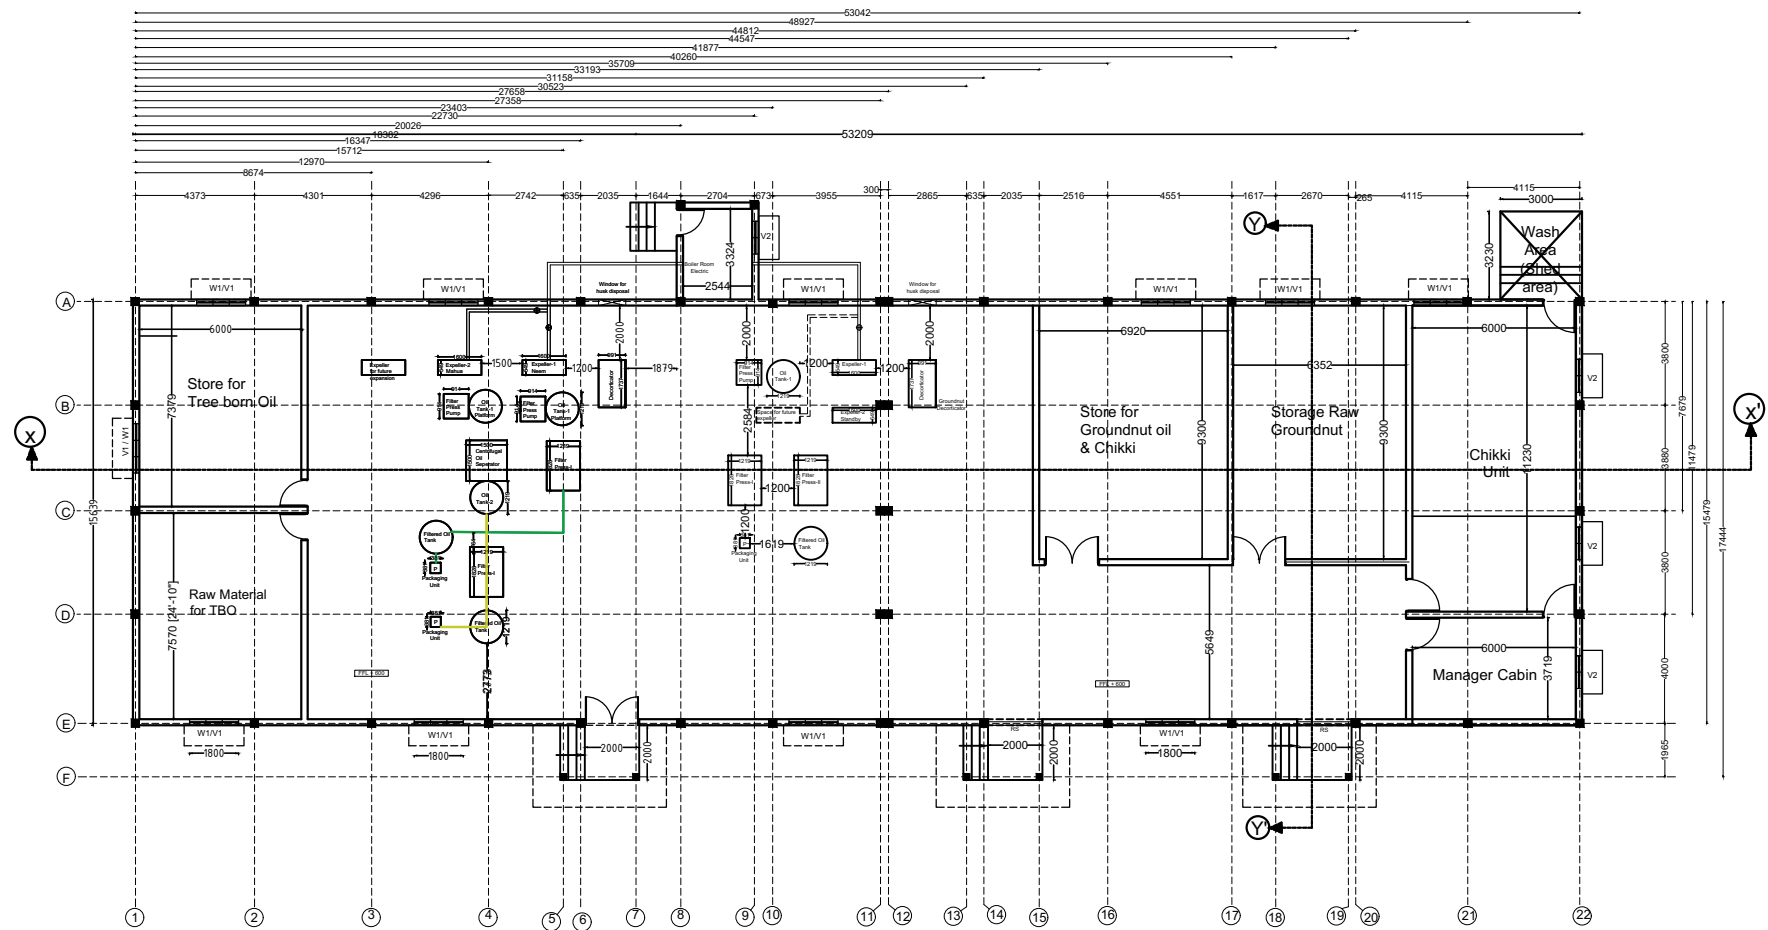

NEEM / MAHUA / KUSUM /GROUNDNUT OIL/ CHIKKI UNIT
BUILD UP AREA - 866 SQM





- LIST OF DRAWING**
NEEM / MAHUA / KUSUM / GROUNDNUT OIL
EXTRACTION UNIT
DP0001 DRG CL 01 103
1 - PLAN LAYOUT
2 - SECTION / ELEVATION
3 - COLUMN LAYOUT
4 - FOOTING LAYOUT
5 - GROUND BEAM LAYOUT
6 - BEAM LAYOUT (2.4 M ABOVE)
7 - BEAM LAYOUT (4.5 M ABOVE)
8 - TRUSS DETAIL
9 - ELECTRICAL LAYOUT

OPENING SCHEDULE

NAME	SAYMBOL
WINDOW	- W1
VENTILATOR	- V1
ROLLING SHUTTER	- R1
DOOR	- D1

SN	SAYMBOL	NOS	SIZE
01	W1	11	1.8M X 1.5M
02	V1	15	1.8 M X 1 M
03	D2	03	1.2 M X 2.1M
04	D1	07	1M X 2.1 M
05	R1	02	2.4 M X 2.5 M

DRG NO: DP0001 DRG CL 01 103	SHEET NO: 1 OF 9	REV. R0	SCALE: NTS	SWATI Architecture landscape interior ARCHITECTS PLANERS ENGINEERING INTERIOR DESIGN 282 , tulip , A block , Talpuri International colony , Bhilai , C.G. Email - swati.arch@outlook.com
DESIGNED: UPENDRA SINGH	DRAWN: SIMRAN SONI	CHECKED: UPENDRA SINGH	VERIFIED: ADMIN	APPROVED: ADMIN
ISSUED FOR: TENDOR PURPOSE				UNIT: MILIMETER
				DATE: 12.05.2022
This drawing is the property of HUP DESIGN and is to be used only for the purpose for which it was lent and must not be in any way detrimental to the interest of the company and is subject to return on demand				TITLE: NEEM / MAHUA / KUSUM /GROUNDNUT OIL EXTRACTION UNIT PLAN LAYOUT

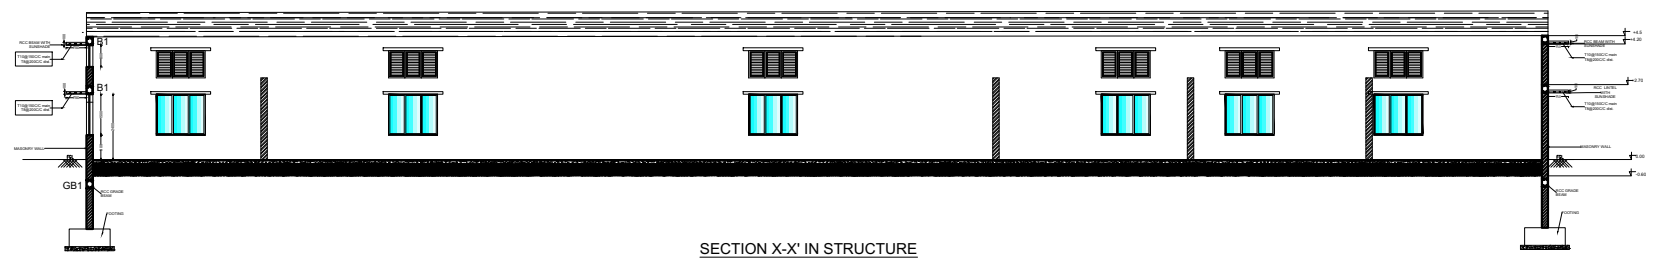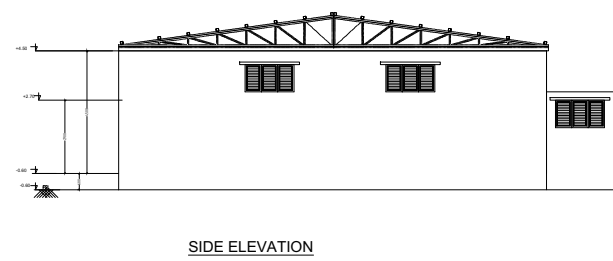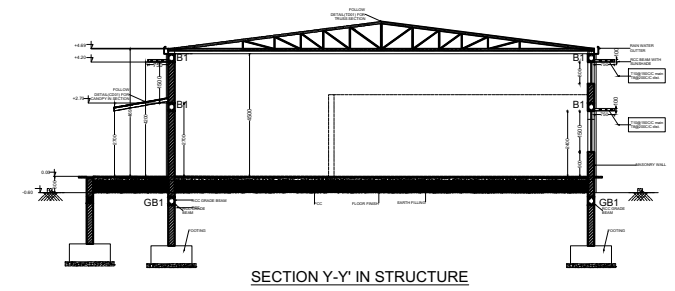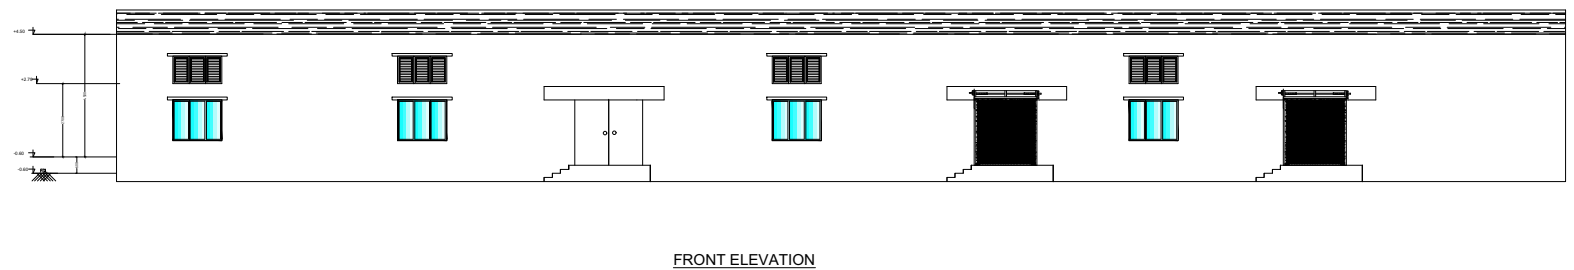


DRG NO:		SHEET NO:	REV.	SCALE:	SWATI Architecture landscape interior ARCHITECTS PLANERS ENGINEERING INTERIOR DESIGN 282 , tulip , A block , Talpuri International colony , Bhilai , C.G. Email - swati.arch@outlook.com	
DP0001 DRG CL 01 103		2 OF 9	R0	NTS		
DESIGNED:	DRAWN:	CHECKED:	VERIFIED:	APPROVED:	CLIENT:	CHHATTISGARH STATE MINOR FOREST PRODUSE
UPENDRA SINGH	SIMRAN SONI	UPENDRA SINGH	ADMIN	ADMIN		
ISSUED FOR:		UNIT:		DATE:	PROJECT:	INCUBATION CENTER AT DEOBHOG GARIYABAND
TENDOR PURPOSE		MILIMETER		12.05.2022		
This drawing is the property of HUP DESIGN and is to be used only for the purpose for which it was lent and must not be in any way detrimental to the interest of the company and is subject to return on demand					TITLE:	
					NEEM / MAHUA / KUSUM /GROUNDNUT OIL EXTRACTION UNIT ELEVATION / SECTION	

GENERAL NOTES


NOTES-

 1. USE - M 20 GRADE OF CONC. AS/IS 426-5000
2. USE - FE 500 GRADE OF REINF. BY CLIENT
3. PROVIDE CLEAR COVER TO MAIN REINF.
- FOUNDATION- 50MM
- COLUMN - 40MM
- BEAM - 25MM
- SLAB - 20MM OR DIA OF BAR, WHICHEVER IS MORE,
- R.C.C. WALL - 25MM
- 4.TIES SHOULD BE BEND INSIDE WITH 10# LENGTH IN BEAM & COLUMN




- 5.FOLLOW - IS-456-2000 FOR R.C.C. WORK
- 6.STRIPPING TIME FOR SHUTTERING / FORMWORK UNDER NORMAL CONDITION.

TYPE OF WORK	MINIMUM PERIOD BEFORE STRIKING FORM WORK
a) VERTICAL FORMWORK TO COLUMN, WALLS, BEAM	16-24 HOUR
b) SOFFITS FORMWORK TO SLABS (PROPS TO BE REFIXED- - IMMEDIATELY AFTER REMOVAL OF FORMWORK)	3 DAYS
c) SOFFIT FORMWORK TO BEAMS (PROPS TO BE REFIXED IMMEDIATELY AFTER REMOVAL OF FORMWORK)	7DAYS
d) PROPS TO SLABS:	
1) SPANNING UP TO 4.5M	7DAYS
2) SPANNING OVER 4.5M	14 DAYS
e) PROPS TO BEAMS & ARCHES:	
1) SPANNING UP TO 6M	14DAYS
2) SPANNING OVER 6M	21DAYS
7. CURING FOR R.C.C. MEMBER MINIMUM 14 DAYS CONTINUOUSLY PREFERABLE - 28 DAYS.	
8. START EARLY CURING TO AVOID SRINKAGE CRACKS, WHEN CONCRETE APPEARS TO HARDEN.	
9) PROVIDE FOLLOWING SLUMP IN CONCRETE GEN- -ERALLY.	
a) SHALLOW SECTIONS, PAYMENTS, MASS CONC. LIGTH REINFORCEMENT SECTION IN SLAB, BEAM, WALL, COLUMN	25-75
b) HEAVILY REINFORCEMENT SECTION IN SLAB	50-100
c) HEAVILY REINFORCEMENT SECTION IN BEAMS, WALLS, COLUMNS SLIPFORM, OR PUMPED CONC.	75-100
d) TRENCH FILL, PILLING, PUMPED CONC.	100-150
10) PROVIDE LAP/ DEVELOPEMENT LENGTH IN REINFORCEMENT BARS GRADE OF CONC.	
	M20- 47Ø
	M25-41Ø
	M30-38Ø
11) REFER RELEVANT DRG. WITH THIS DRG.	
12) AVOID CORE CUTING.	

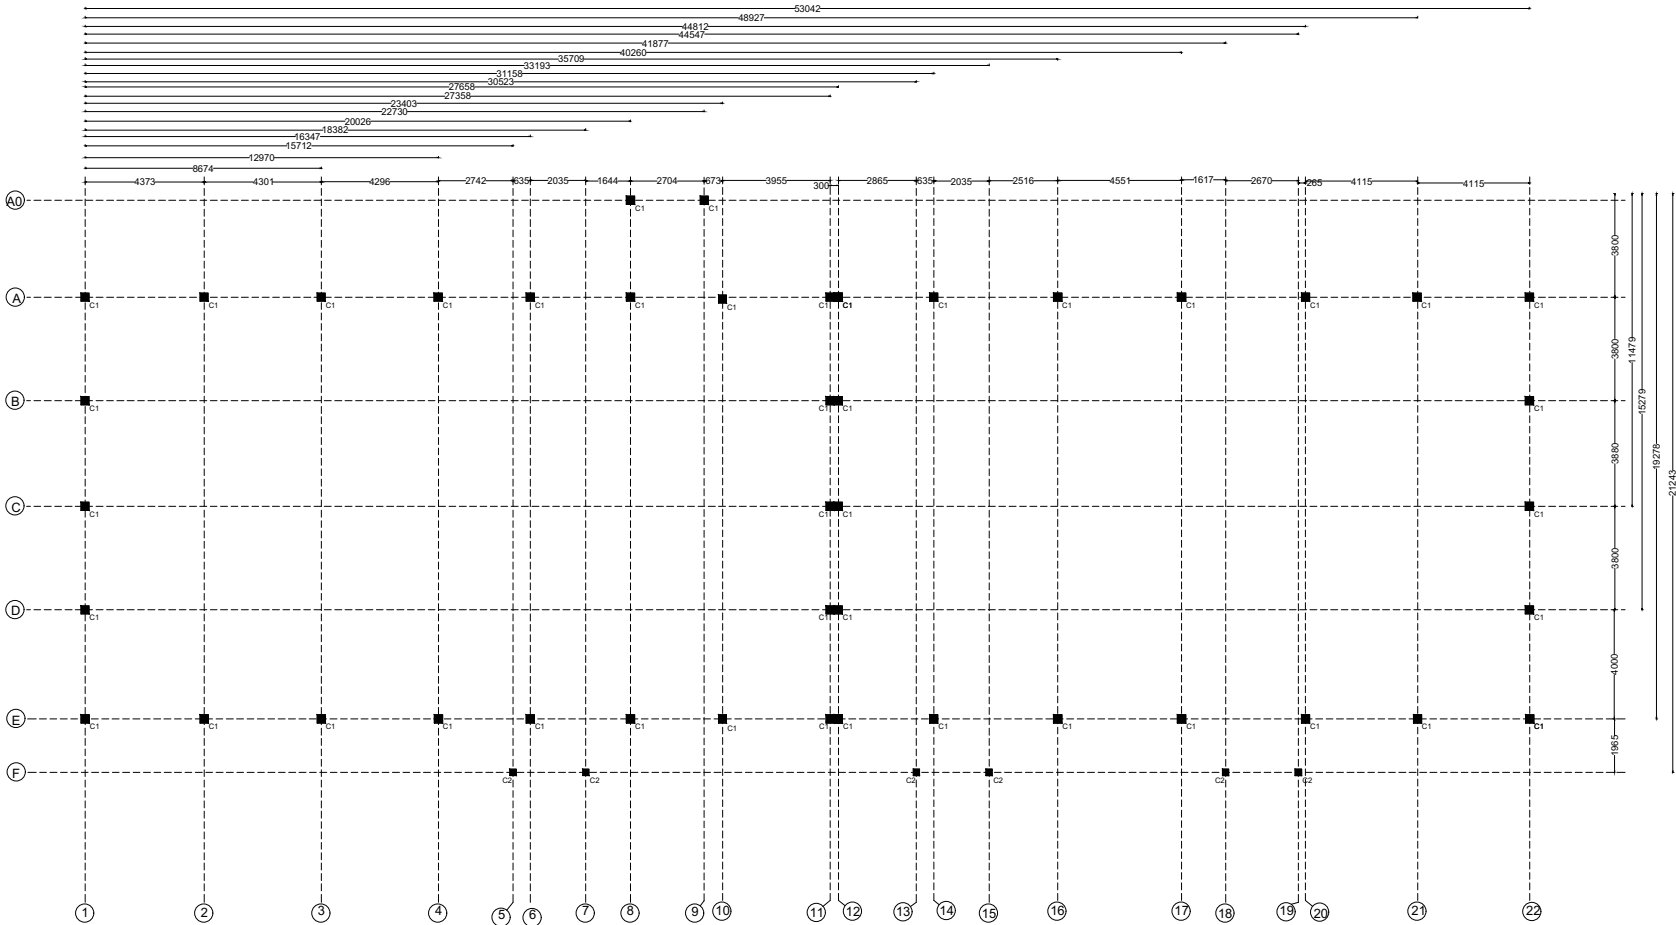

COLUMN LAYOUT PLAN

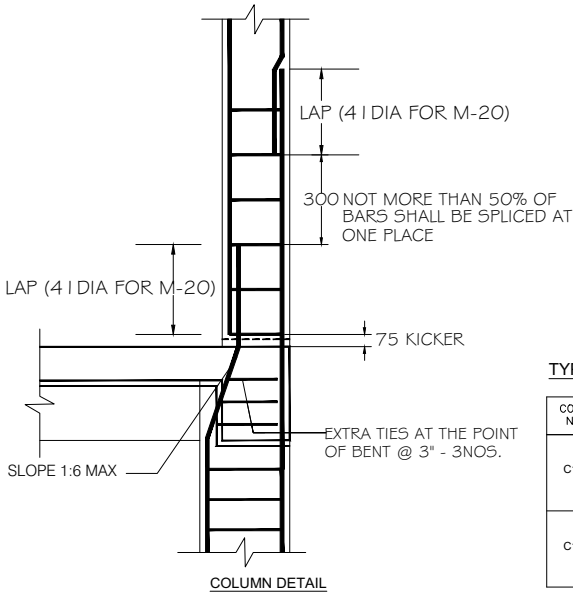

TYPICAL COLUMN DETAIL'S

COLUMN NAME	Pile/col detail	STIRRUPS	REMARKS
C1	 300 300 8-T12 TB@ 200 c/c 2-Tie		FOUNDATION TO TERRACE
C1	 230 230 4-T12 TB@ 200 c/c 1-Tie		TERMINATE AT GROUND LVL.

DRG NO:	SHEET NO:	REV.	SCALE:
DP0001 DRG CL 01 105	3 OF 9	R0	NTS
DESIGNED:	DRAWN:	CHECKED:	VERIFIED:
UPENDRA SINGH	SIMRAN SONI	UPENDRA SINGH	ADMIN
ISSUED FOR:	UNIT:	DATE:	
TENDOR PURPOSE	MILIMETER	12.05.2022	

This drawing is the property of HUP DESIGN and is to be used only for the purpose for which it was lent and must not be in any way detrimental to the interest of the company and is subject to return on demand

SWATI Architecture landscape interior
ARCHITECTS | PLANERS | ENGINEERING | INTERIOR DESIGN
282 , tulip , A block , Talpuri International colony , Bhilai , C.G. Email - swati.arch@outlook.com

CHHATTISGARH STATE MINOR FOREST PRODUCE

 
INCUBATION CENTER AT DEOBHOG GARIYABAND

TITLE:
NEEM / MAHUA / KUSUM/ GROUND NUT OIL EXTRACTION UNIT
BEAM LAYOUT

GENERAL NOTES

NOTES-

1. USE - M 20 GRADE OF CONC. AS/IS 426-5000
 2. USE - FE 500 GRADE OF REINF. BY CLIENT
 3. PROVIDE CLEAR COVER TO MAIN REINF.
- FOUNDATION- 50MM
COLUMN - 40MM
BEAM - 25MM
SLAB - 20MM OR DIA OF BAR, WHICHEVER IS MORE,
R.C.C. WALL - 25MM
- 4.TIES SHOULD BE BEND INSIDE WITH 10# LENGTH
IN BEAM & COLUMN



- 5.FOLLOW - IS-456-2000 FOR R.C.C. WORK
- 6.STRIPPING TIME FOR SHUTTERING / FORMWORK
UNDER NORMAL CONDITION.

TYPE OF WORK	MINIMUM PERIOD BEFORE STRIKING FORM WORK
--------------	--

a) VERTICAL FORMWORK TO
COLUMN, WALLS, BEAM 16-24 HOUR

b) SOFFITS FORMWORK TO
SLABS (PROPS TO BE REFIXED-
- IMMEDIATELY AFTER REMOVAL
OF FORMWORK) 3 DAYS

c) SOFFIT FORMWORK TO BEAMS
(PROPS TO BE REFIXED IMMEDIATELY
AFTER REMOVAL OF FORMWORK) 7DAYS

d) PROPS TO SLABS:
1) SPANNING UP TO 4.5M 7DAYS
2) SPANNING OVER 4.5M 14 DAYS

e) PROPS TO BEAMS & ARCHES:
1) SPANNING UP TO 6M 14DAYS
2) SPANNING OVER 6M 21DAYS

7. CURING FOR R.C.C. MEMBER MINIMUM 14 DAYS
CONTINUOUSLY PREFERABLE - 28 DAYS.
8. START EARLY CURING TO AVOID SHRINKAGE
CRACKS, WHEN CONCRETE APPEARS TO HARDEN.
- 9) PROVIDE FOLLOWING SLUMP IN CONCRETE GEN-
-ERALLY.

a) SHALLOW SECTIONS, PAYMENTS,
MASS CONC. LIGHT REINFORCEMENT
SECTION IN SLAB, BEAM, WALL, COLUMN 25-75

b) HEAVILY REINFORCEMENT SECTION IN
SLAB 50-100

c) HEAVILY REINFORCEMENT SECTION IN
BEAMS, WALLS, COLUMNS SLIPFORM, OR
PUMPED CONC. 75-100

d) TRENCH FILL, FILLING, PUMPED CONC.
100-150


10) PROVIDE LAP/ DEVELOPEMENT LENGTH
IN REINFORCEMENT BARS GRADE OF CONC.

M20- 47Ø


M25-41Ø

M30-38Ø


- 11) REFER RELEVANT DRG. WITH THIS DRG.
- 12) AVOID CORE CUTTING.

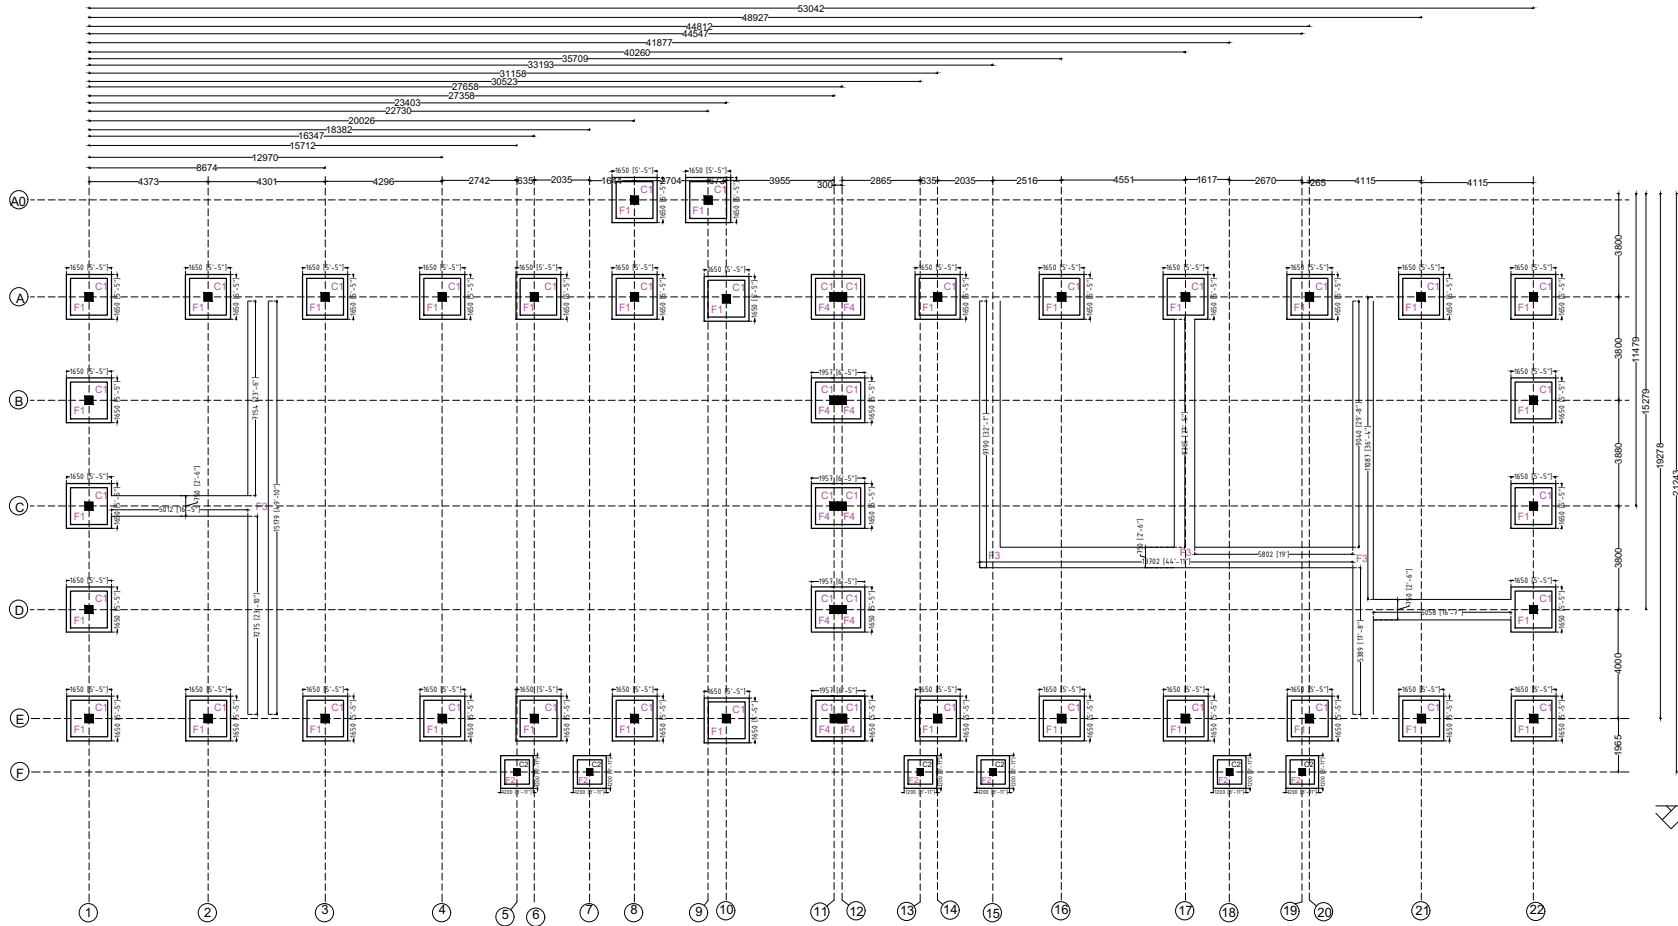

FOOTING LAYOUT PLAN

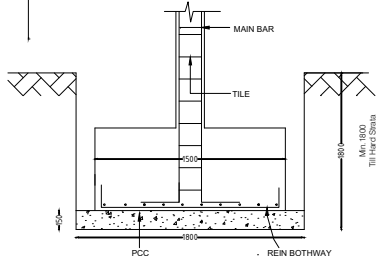

TYPICAL FOOTING SECTION (1-1'')

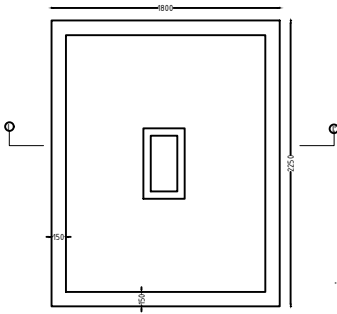

TYPICAL FOOTING PLAN

FOOTING SCHEDULE

FE500 AND M20						
Footing	Column	PCC Size	Footing Size	Total	Steel	Steel
	Nos	X - Y mm	X - Y mm	Depth mm	to X mm	to Y mm
F1	C1	1650 X 1650	1350 X 1350	400	T10@ 175C/C	T10@ 175 C/C
F2	C2	1200 X 1200	900 X 900	230	T8@200C/C	T8@ 200 C/C

DRG NO:	SHEET NO:	REV.	SCALE:
DP0001 DRG CL 01 105	4 OF 9	R0	NTS
DESIGNED:	DRAWN:	CHECKED:	VERIFIED:
UPENDRA SINGH	SIMRAN SONI	UPENDRA SINGH	ADMIN
ISSUED FOR:	UNIT:	DATE:	
TENDOR PURPOSE	MILIMETER	12.05.2022	

This drawing is the property of HUP DESIGN and is to be used only for the purpose for which it was lent and must not be in any way detrimental to the interest of the company and is subject to return on demand


SWATI Architecture landscape interior

ARCHITECTS | PLANERS | ENGINEERING | INTERIOR DESIGN
282 , tulip , A block , Talpuri International colony , Bhilai , C.G. Email - swati.arch@outlook.com

CHHATTISGARH STATE MINOR FOREST PRODUCE

INCUBATION CENTER AT DEOBHOG GARIYABAND

TITLE:
NEEM / MAHUA / KUSUM/ GROUND NUT OIL EXTRACTION UNIT
FOOTING LAYOUT

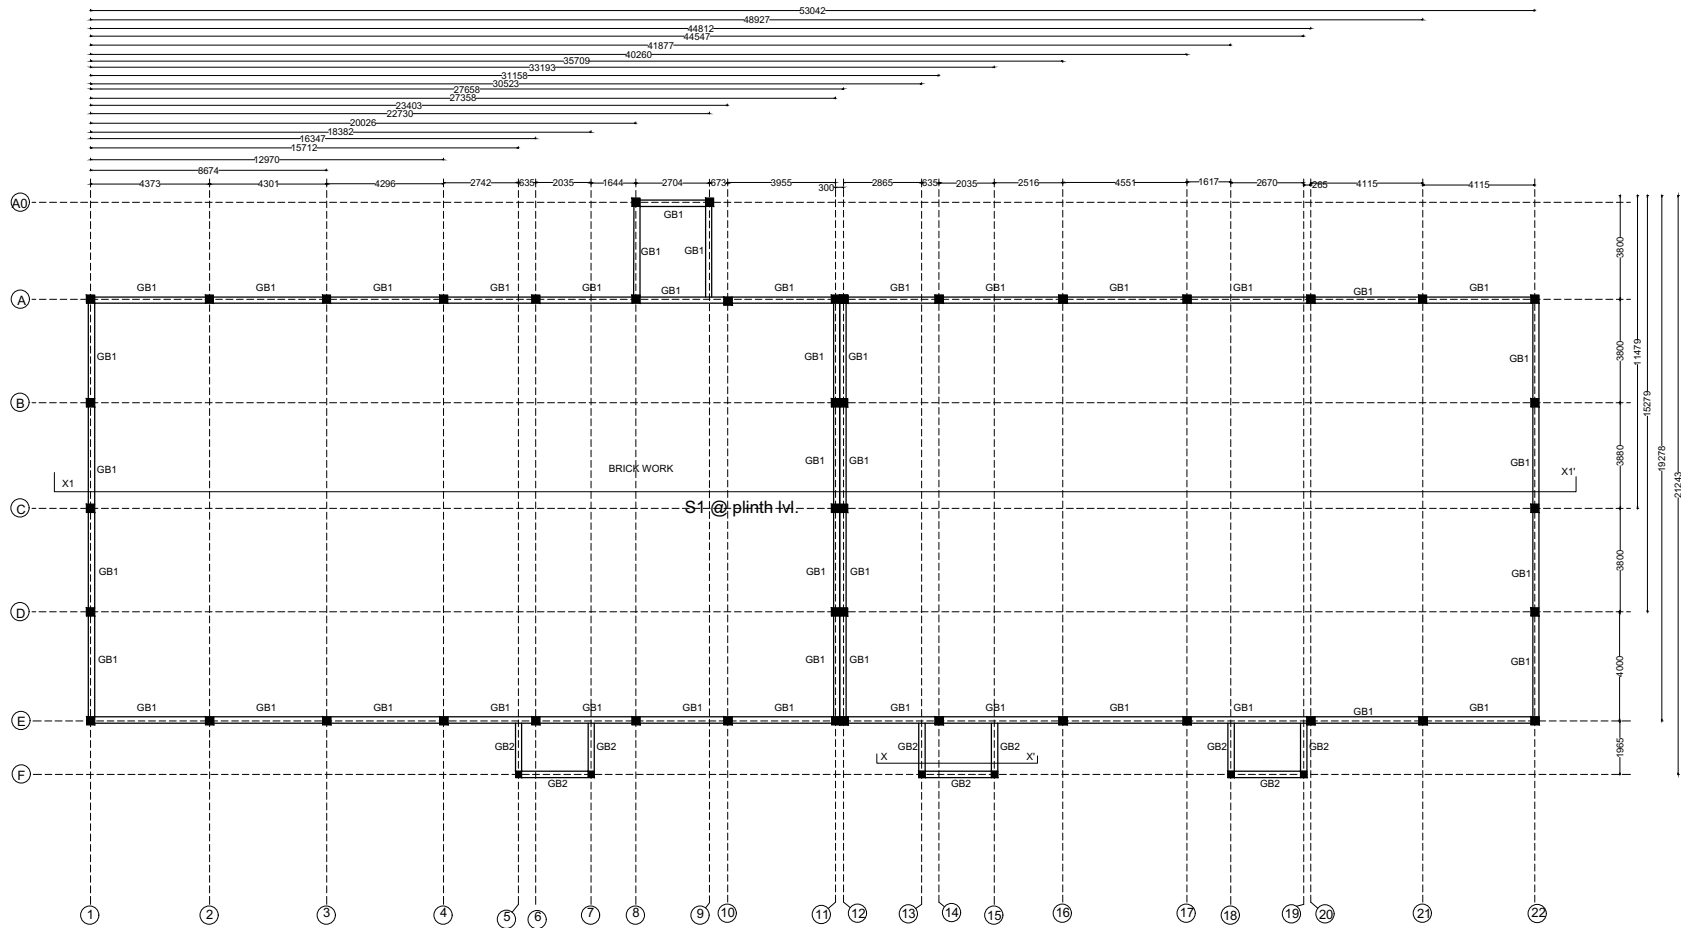


GROUND BEAM LAYOUT

BEAM SCHEDULE FOR GROUND/ PLINTH LVL.									
GB1	230X375	2-T16	2-T12	2-T16	2-T12	2-T12	T8 @200C/C	T8 @175C/C	T8 @175C/C
GB2	230X230	2-T12	-	2-T10	-	-	T8 @200C/C	T8 @200C/C	T8 @200C/C
SLAB SCHEDULE FOR GROUND FLOOR LVL.									
SLAB NAME	THICKNESS (mm)								
		Main Steel		Other Steel				remarks	
S1	150 (MESH)	T8 @ 200 c/c		T8 @ 200 c/c				All straight	

GENERAL NOTES

NOTES-

 - USE - M 20 GRADE OF CONC. AS/IS 426-5000
 - USE - FE 500 GRADE OF REINF. BY CLIENT
 - PROVIDE CLEAR COVER TO MAIN REINF.
- FOUNDATION- 50MM
COLUMN - 40MM
BEAM - 25MM
SLAB - 20MM OR DIA OF BAR, WHICHEVER IS MORE,
R.C.C. WALL - 25MM
- 4.TIES SHOULD BE BEND INSIDE WITH 10# LENGTH IN BEAM & COLUMN




- FOLLOW - IS-456-2000 FOR R.C.C. WORK
- STRIPPING TIME FOR SHUTTERING / FORMWORK UNDER NORMAL CONDITION.

TYPE OF WORK	MINIMUM PERIOD BEFORE STRIKING FORM WORK
--------------	--

- VERTICAL FORMWORK TO COLUMN, WALLS, BEAM 16-24 HOUR
- SOFFITS FORMWORK TO SLABS (PROPS TO BE REFIXED- IMMEDIATELY AFTER REMOVAL OF FORMWORK) 3 DAYS
- SOFFIT FORMWORK TO BEAMS (PROPS TO BE REFIXED IMMEDIATELY AFTER REMOVAL OF FORMWORK) 7DAYS
- PROPS TO SLABS:
 - 1) SPANNING UP TO 4.5M 7DAYS
 - 2) SPANNING OVER 4.5M 14 DAYS
- PROPS TO BEAMS & ARCHES:
 - 1) SPANNING UP TO 6M 14DAYS
 - 2) SPANNING OVER 6M 21DAYS

- CURING FOR R.C.C. MEMBER MINIMUM 14 DAYS CONTINOUSELY PREFERABLE - 28 DAYS.
- START EARLY CURING TO AVOID SRINKAGE CRACKS, WHEN CONCRETE APPEARS TO HARDEN.
- PROVIDE FOLLOWING SLUMP IN CONCRETE GEN-ERALLY.
 - SHALLOW SECTIONS, PAYMENTS, MASS CONC. LIGTH REINFORCEMENT SECTION IN SLAB, BEAM, WALL, COLUMN 25-75
 - HEAVILY REINFORCEMENT SECTION IN SLAB 50-100
 - HEAVILY REINFORCEMENT SECTION IN BEAMS, WALLS, COLUMNS SLIPFORM, OR PUMPED CONC. 75-100
 - TRENCH FILL, PILLING, PUMPED CONC. 100-150
- PROVIDE LAP/ DEVELOPEMENT LENGTH IN REINFORCEMENT BARS GRADE OF CONC.
 - M20- 47Ø
 - M25-41Ø
 - M30-38Ø
- REFER RELEVANT DRG. WITH THIS DRG.
- AVOID CORE CUTING.


DRG NO: DP0001 DRG CL 01 105	SHEET NO: 5 OF 9	REV. R0	SCALE: NTS	SWATI Architecture landscape interior ARCHITECTS PLANERS ENGINEERING INTERIOR DESIGN 282 , tulip , A block , Talpuri International colony , Bhilai , C.G. Email - swati.arch@outlook.com	
DESIGNED: UPENDRA SINGH	DRAWN: SIMRAN SONI	CHECKED: UPENDRA SINGH	VERIFIED: ADMIN	APPROVED: ADMIN	CLIENT: CHHATTISGARH STATE MINOR FOREST PRODUCE
ISSUED FOR: TENDOR PURPOSE	UNIT: MILIMETER	DATE: 12.05.2022	PROJECT: INCUBATION CENTER AT DEOBHOG GARIYABAND		
This drawing is the property of HUP DESIGN and is to be used only for the purpose for which it was lent and rust not be in any way detrimental to the interest of the company and is subject to return on demand				TITLE: NEEM / MAHUA / KUSUM/ GROUND NUT OIL EXTRACTION BEAM LAYOUT	UNIT 14

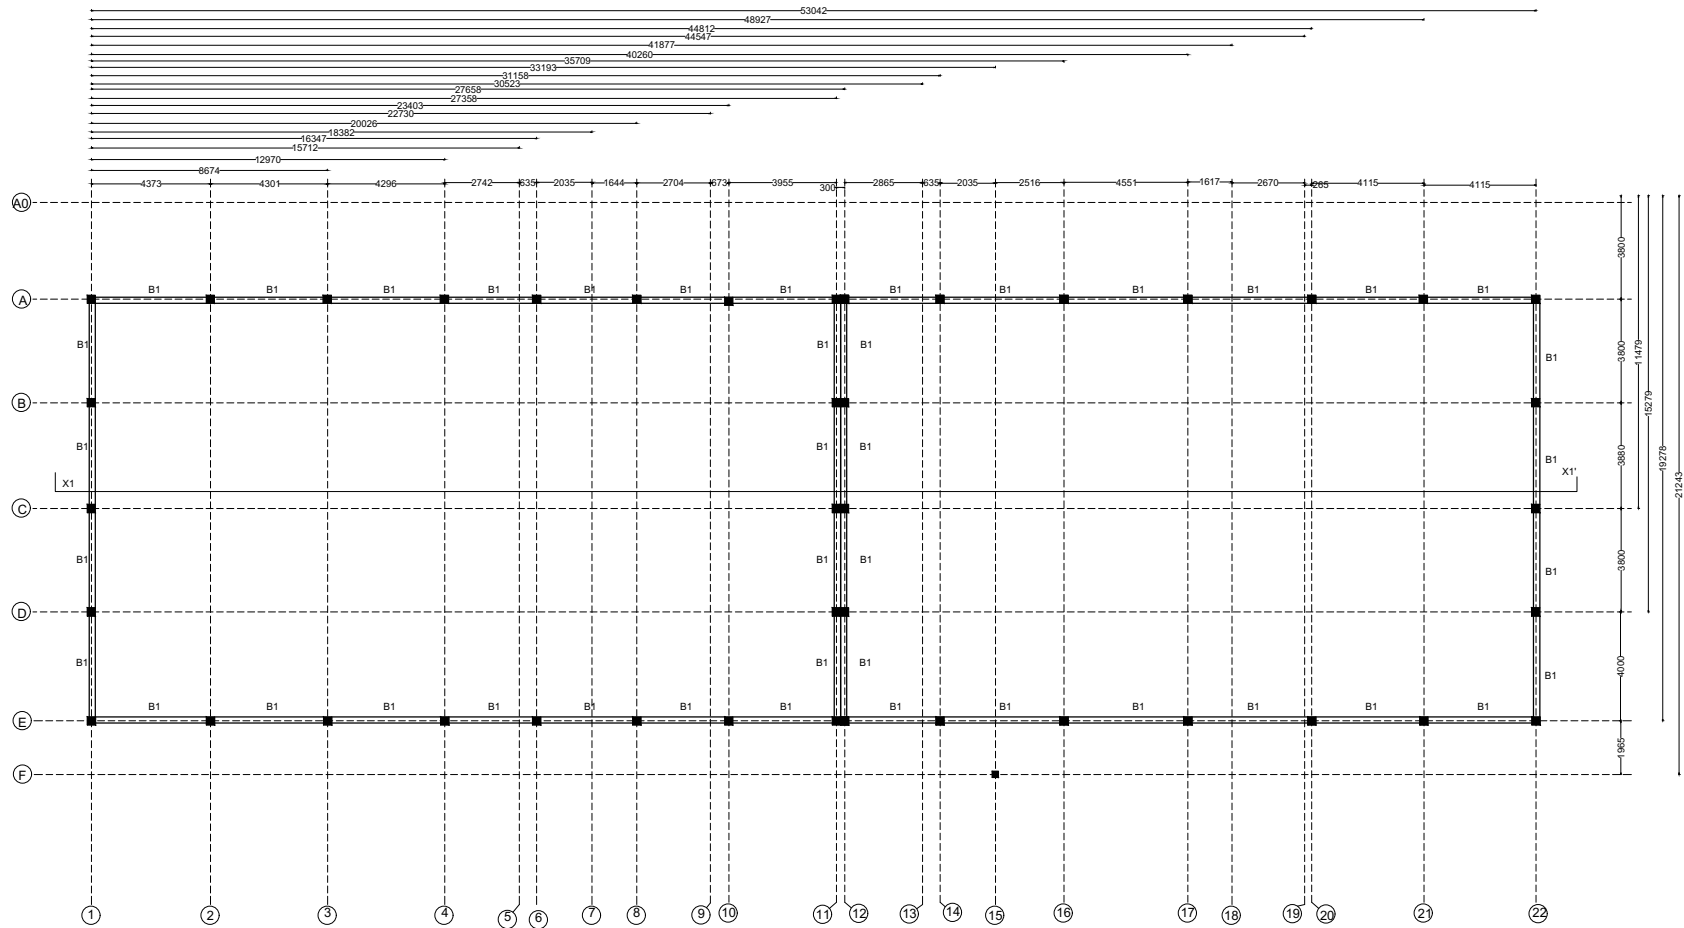

BEAM PLAN (4.5 ABOVE PLINTH LVL)

BEAM SCHEDULE FOR 4.5m LVL. ABOVE PLINTH


B1	230X300	2-T12	-	2-T10	-	-	T8 @200C/C	T8 @175C/C	T8 @175C/C	SLAB THK. INCLUDED
B2	230X300	2-T12	2-T12	2-T12	2-T12	2-T12	T8 @200C/C	T8 @175C/C	T8 @175C/C	SLAB THK. INCLUDED

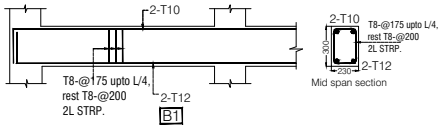

GENERAL NOTES

NOTES-

 1. USE - M 20 GRADE OF CONC. AS/IS 426-5000
2. USE - FE 500 GRADE OF REINF. BY CLIENT
3. PROVIDE CLEAR COVER TO MAIN REINF.
- FOUNDATION- 50MM
COLUMN - 40MM
BEAM - 25MM
SLAB - 20MM OR DIA OF BAR, WHICHEVER IS MORE,
R.C.C. WALL - 25MM
- 4.TIES SHOULD BE BEND INSIDE WITH 10# LENGTH
IN BEAM & COLUMN



- 5.FOLLOW - IS-456-2000 FOR R.C.C. WORK
- 6.STRIPPING TIME FOR SHUTTERING / FORMWORK
UNDER NORMAL CONDITION.

TYPE OF WORK	MINIMUM PERIOD BEFORE STRIKING FORM WORK
--------------	--

- a) VERTICAL FORMWORK TO
COLUMN, WALLS, BEAM 16-24 HOUR
- b) SOFFITS FORMWORK TO
SLABS (PROPS TO BE REFIXED-
- IMMEDIATELY AFTER REMOVAL
OF FORMWORK) 3 DAYS
- c) SOFFIT FORMWORK TO BEAMS
(PROPS TO BE REFIXED IMMEDIATELY
AFTER REMOVAL OF FORMWORK) 7DAYS
- d) PROPS TO SLABS:
1) SPANNING UP TO 4.5M 7DAYS
2) SPANNING OVER 4.5M 14 DAYS
- e) PROPS TO BEAMS & ARCHES:
1) SPANNING UP TO 6M 14DAYS
2) SPANNING OVER 6M 21DAYS

7. CURING FOR R.C.C. MEMBER MINIMUM 14 DAYS
CONTINUOUSLY PREFERABLE - 28 DAYS.
8. START EARLY CURING TO AVOID SRINKAGE
CRACKS, WHEN CONCRETE APPEARS TO HARDEN.
- 9) PROVIDE FOLLOWING SLUMP IN CONCRETE GEN-
-ERALLY.
a) SHALLOW SECTIONS, PAYMENTS,
MASS CONC. LIGTH REINFORCEMENT
SECTION IN SLAB, BEAM, WALL, COLUMN 25-75
b) HEAVILY REINFORCEMENT SECTION IN
SLAB 50-100
c) HEAVILY REINFORCEMENT SECTION IN
BEAMS, WALLS, COLUMNS SLIPFORM, OR
PUMPED CONC. 75-100
d) TRENCH FILL, PILLING, PUMPED CONC.
100-150
10) PROVIDE LAP/ DEVELOPEMENT LENGTH
IN REINFORCEMENT BARS GRADE OF CONC.

M20- 47Ø
M25-41Ø
M30-38Ø

- 11) REFER RELEVANT DRG. WITH THIS DRG.
- 12) AVOID CORE CUTING.

DRG NO:	SHEET NO:	REV.	SCALE:
DP0001 DRG CL 01 105	7 OF 9	R0	NTS
DESIGNED:	DRAWN:	CHECKED:	VERIFIED:
UPENDRA SINGH	SIMRAN SONI	UPENDRA SINGH	ADMIN
ISSUED FOR:	TENDOR PURPOSE	UNIT:	MILIMETER
		DATE:	12.05.2022

This drawing is the property of HUP DESIGN and is to be used only for the purpose for which it was lent and must not be in any way detrimental to the interest of the company and is subject to return on demand


SWATI Architecture landscape interior

ARCHITECTS | PLANERS | ENGINEERING | INTERIOR DESIGN
282 , tulip , A block , Talpuri International colony , Bhilai , C.G. Email - swati.arch@outlook.com


CHHATTISGARH STATE MINOR FOREST PRODUSE

INCUBATION CENTER AT DEOBHOG GARIYABAND

TITLE:
NEEM / MAHUA / KUSUM/ GROUND NUT OIL EXTRACTION UNIT
BEAM LAYOUT

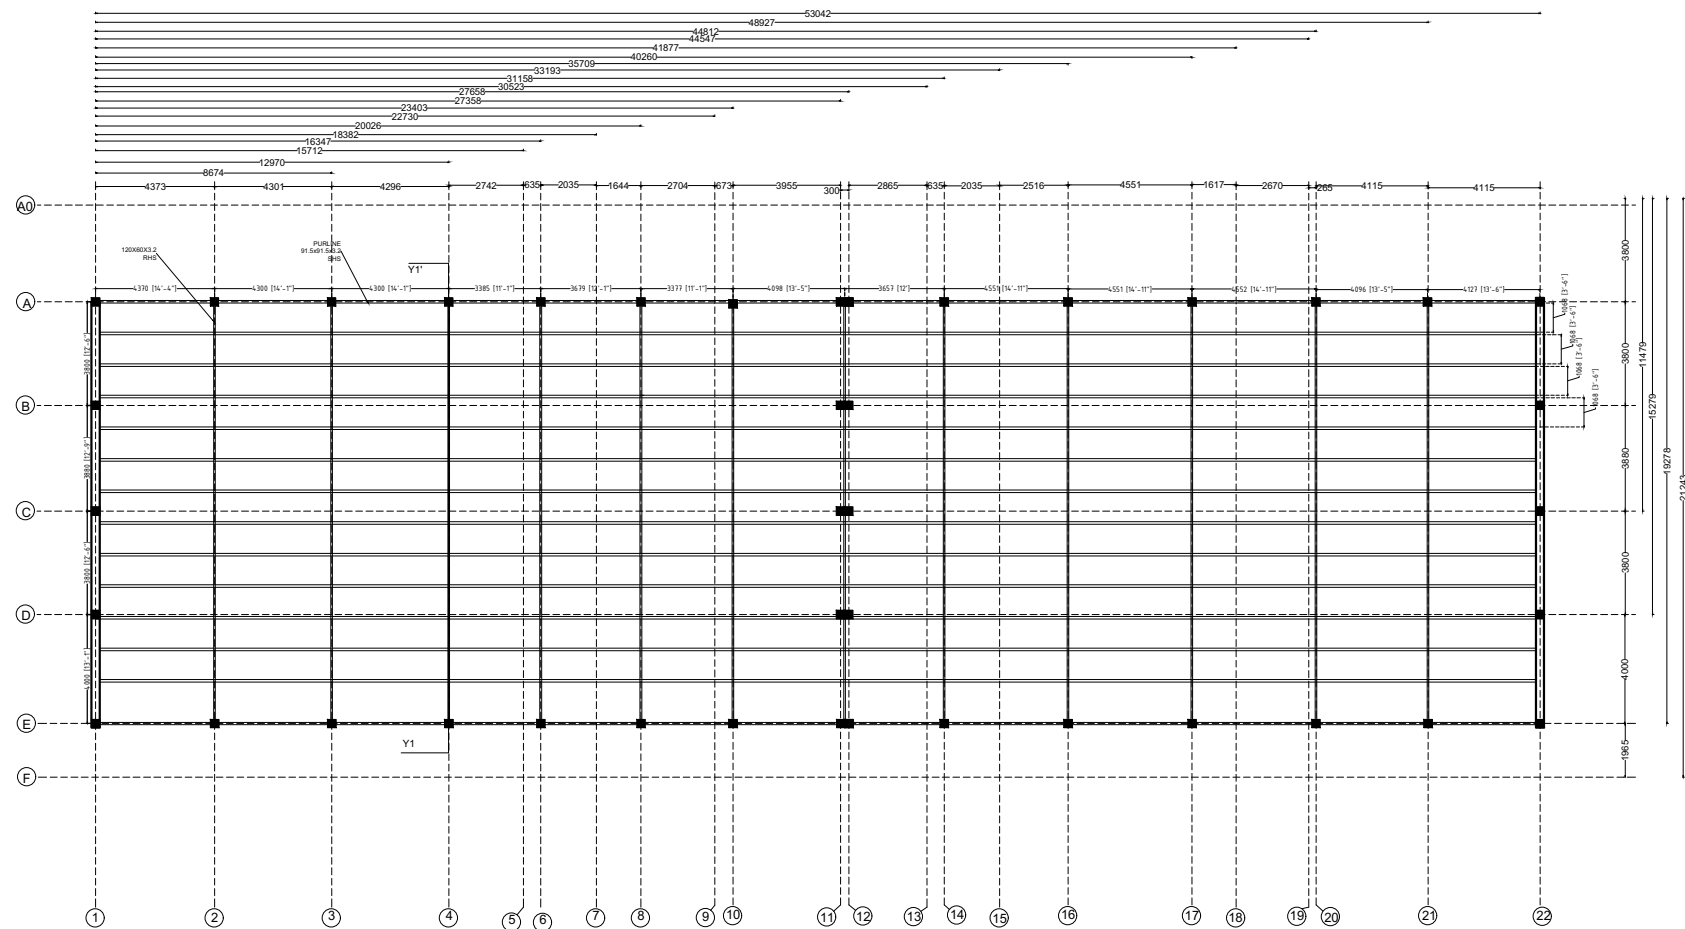

TRUSS PLAN

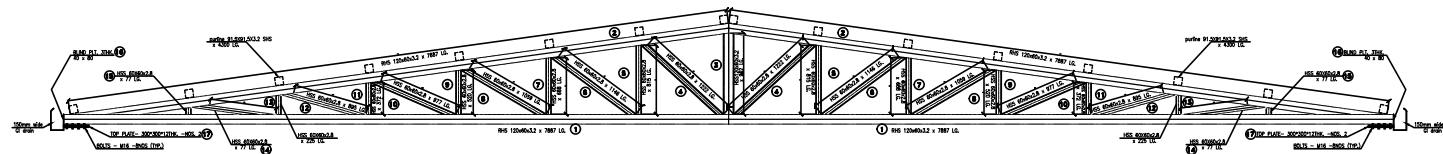


TRUSS DETAIL

GENERAL NOTES

NOTES-

 1. USE - M 20 GRADE OF CONC. AS/IS 426-5000
 2. USE - FE 500 GRADE OF REINF. BY CLIENT
 3. PROVIDE CLEAR COVER TO MAIN REINF.
- FOUNDATION- 50MM
COLUMN - 40MM
BEAM - 25MM
SLAB - 20MM OR DIA OF BAR, WHICHEVER IS MORE,
R.C.C. WALL - 25MM
- 4.TIES SHOULD BE BEND INSIDE WITH 10# LENGTH
IN BEAM & COLUMN



- 5.FOLLOW - IS-456-2000 FOR R.C.C. WORK
- 6.STRIPPING TIME FOR SHUTTERING / FORMWORK
UNDER NORMAL CONDITION.

TYPE OF WORK	MINIMUM PERIOD BEFORE STRIKING FORM WORK
--------------	--

- | | |
|---|------------|
| a) VERTICAL FORMWORK TO
COLUMN, WALLS, BEAM | 16-24 HOUR |
| b) SOFFITS FORMWORK TO
SLABS (PROPS TO BE REFIXED-
- IMMEDIATELY AFTER REMOVAL
OF FORMWORK) | 3 DAYS |
| c) SOFFIT FORMWORK TO BEAMS
(PROPS TO BE REFIXED IMMEDIATELY
AFTER REMOVAL OF FORMWORK) | 7DAYS |
| d) PROPS TO SLABS: | |
| 1) SPANNING UP TO 4.5M | 7DAYS |
| 2) SPANNING OVER 4.5M | 14 DAYS |
| e) PROPS TO BEAMS & ARCHES: | |
| 1) SPANNING UP TO 6M | 14DAYS |
| 2) SPANNING OVER 6M | 21DAYS |

7. CURING FOR R.C.C. MEMBER MINIMUM 14 DAYS
CONTINUOUSLY PREFERABLE - 28 DAYS.
 8. START EARLY CURING TO AVOID SRINKAGE
CRACKS, WHEN CONCRETE APPEARS TO HARDEN.
 - 9) PROVIDE FOLLOWING SLUMP IN CONCRETE GEN-
-ERALLY.
- | | |
|---|---------|
| a) SHALLOW SECTIONS, PAYMENTS,
MASS CONC. LIGTH REINFORCEMENT
SECTION IN SLAB, BEAM, WALL, COLUMN | 25-75 |
| b) HEAVILY REINFORCEMENT SECTION IN
SLAB | 50-100 |
| c) HEAVILY REINFORCEMENT SECTION IN
BEAMS, WALLS, COLUMNS SLIPFORM, OR
PUMPED CONC. | 75-100 |
| d) TRENCH FILL, PILLING, PUMPED CONC. | 100-150 |
- 10) PROVIDE LAP/ DEVELOPEMENT LENGTH
IN REINFORCEMENT BARS GRADE OF CONC.
- M20- 47Ø
M25-41Ø
M30-38Ø
- 11) REFER RELEVANT DRG. WITH THIS DRG.
 - 12) AVOID CORE CUTING.

DRG NO:	SHEET NO:	REV.	SCALE:
DP0001 DRG CL 01 105	8 OF 9	R0	NTS
DESIGNED:	DRAWN:	CHECKED:	VERIFIED:
UPENDRA SINGH	SIMRAN SONI	UPENDRA SINGH	ADMIN
ISSUED FOR:	TENDOR PURPOSE	UNIT:	MILIMETER
		DATE:	12.05.2022

This drawing is the property of HUP DESIGN and is to be used only for the purpose for which it was lent and must not be in any way detrimental to the interest of the company and is subject to return on demand

SWATI Architecture landscape interior

ARCHITECTS | PLANERS | ENGINEERING | INTERIOR DESIGN
282 , tulip , A block , Talpuri International colony , Bhilai , C.G. Email - swati.arch@outlook.com

CHHATTISGARH STATE MINOR FOREST PRODUCE


INCUBATION CENTER AT DEOBHOG GARIYABAND

TITLE:
NEEM / MAHUA / KUSUM/ GROUND NUT OIL EXTRACTION UNIT
TRUSS PLAN


01	LED 50W	50W FLOOD LIGHT (HIGH BAY)	52 No.
02		WALL LIGHT	05 No.
03	PP-1	16A SWITCH SOCKET	06 No.
04	LP-1	6A SWITCH SOCKET	06 No.
05	4WAY SPN DB	4WAY SPN DB	21 No.
06		PLDB 1 12 WAY VTPN DB	02 No.
07		1400 mm Ceiling Fan	43 No.
08		20w Led Tube Light	57 No.
09		450 mm Ex Fan	15 No.
10	LP-1	6A SWITCH SOCKET	25 No.
11	SB1	SWITCH BOARD	25 No.
12		6 X 6 SQMM CU WIRE	
13		3 X 1.5 SQMM CU WIRE	
14		Earth Pit-1 Size=450 X 450 MM.	2 SET

MACHINE LIST					
1 - OIL EXPELLER - 120 - 140 kg/hr- nos 2	12.5 HP	02	25 HP	6 X 6 Sqmm CU wire	
2 - ROUND COOKING KETTLE + STREAM JACKET - nos 2					
3 - FILTER PRESS (16 PLATE WITH FILTER PUMP) - nos 2	2 HP	02	4 HP	6 X 6 Sqmm CU wire	
4 - CENTRIFUGAL OIL SEPARATOR - 50 LIT/ BATCH - nos1	2 HP	01	2 HP	6 X 6 Sqmm CU wire	
5 - FILTER PRESS STAND - nos 2					
6 - NEEM SEED DECORTICATOR - 200KG/HR - nos 1	2 HP	01	2 HP	6 X 6 Sqmm CU wire	
7 - ELECTRIC MOTOR - 12.5 HP -nos 1	12.5 HP	01	12.5 HP	6 X 6 Sqmm CU wire	
8 - ELECTRIC BOILER - NOS 1 (10 KW) (13.5 HP)	13.5 HP	01	13.5 HP	6 X 6 Sqmm CU wire	
9 - ONE FILTER PUMP + SWICH - 1.5 HP - NOS 1	1.5 HP	01	1.5 HP	6 X 6 Sqmm CU wire	
10- OIL TANK - 1000 LT - NOS 2					
11 - ESSENTIAL SPARE KIT - NOS -1					
12 - ACCESSORIES (OIL PIPE LINE) - NOS 1					
13 - BOTTLE FILLING MACHINE - NOS -1	0.5 HP	01	0.5 HP	6 X 6 Sqmm CU wire	
14 - MULTIPURPOSE PULVERIZER - NOS- 1	5 HP	01	5 HP	6 X 6 Sqmm CU wire	
TOTAL LOAD	3P MCCB 160A (50 KW) (128 AMP)	66 HP	1R 4C 50 Sqmm Ar. CU Cable		

MACHINE LIST					
1 - OIL EXPELLER , 120 -140 KG/HR , NOS - 2 (12.5 HP)	12.5 HP	02	25 HP	6 X 6 Sqmm CU wire	
2 - ROUND COOKING KETTLE + STREAM JACKET , NOS - 2					
3 - FILTER PRESS (16 PLATE WITH FILTER PUMP) , NOS - 2	1.5 HP	02	3 HP	6 X 6 Sqmm CU wire	
4 - FILTER PRESS STAND , NOS 2					
5 - GROUND NUT DECORTICATOR , 350 KG /HR , NOS 1	2 HP	01	2 HP	6 X 6 Sqmm CU wire	
6 - ELECTRIC MOTOR , 12.5 HP , NOS - 2	12.5 HP	02	25 HP	6 X 6 Sqmm CU wire	
7 - ELECTRIC BOILER , NOS 1 (10 KW) (13.5 HP)	13.5 HP	01	13.5 HP	6 X 6 Sqmm CU wire	
8 - ONE FILTER PUMP + SWITCH , 1.5 HP - NOS 1	1.5 HP	01	1.5 HP	6 X 6 Sqmm CU wire	
9 - OILL TANK ,1000 LT , NOS 1					
10 - ESSENTIAL SPARE KIT , NOS 1					
11 - ACCESSORIES (OIL PIPE LINE) - NOS 1					
12 - BOTTLE FILLING MACHINE - NOS 1	1 HP	01	1 HP	6 X 6 Sqmm CU wire	
TOTAL LOAD	3P MCCB 160A (53 KW) (138 AMP)	71 HP	1R 4C 50 Sqmm Ar. CU Cable		

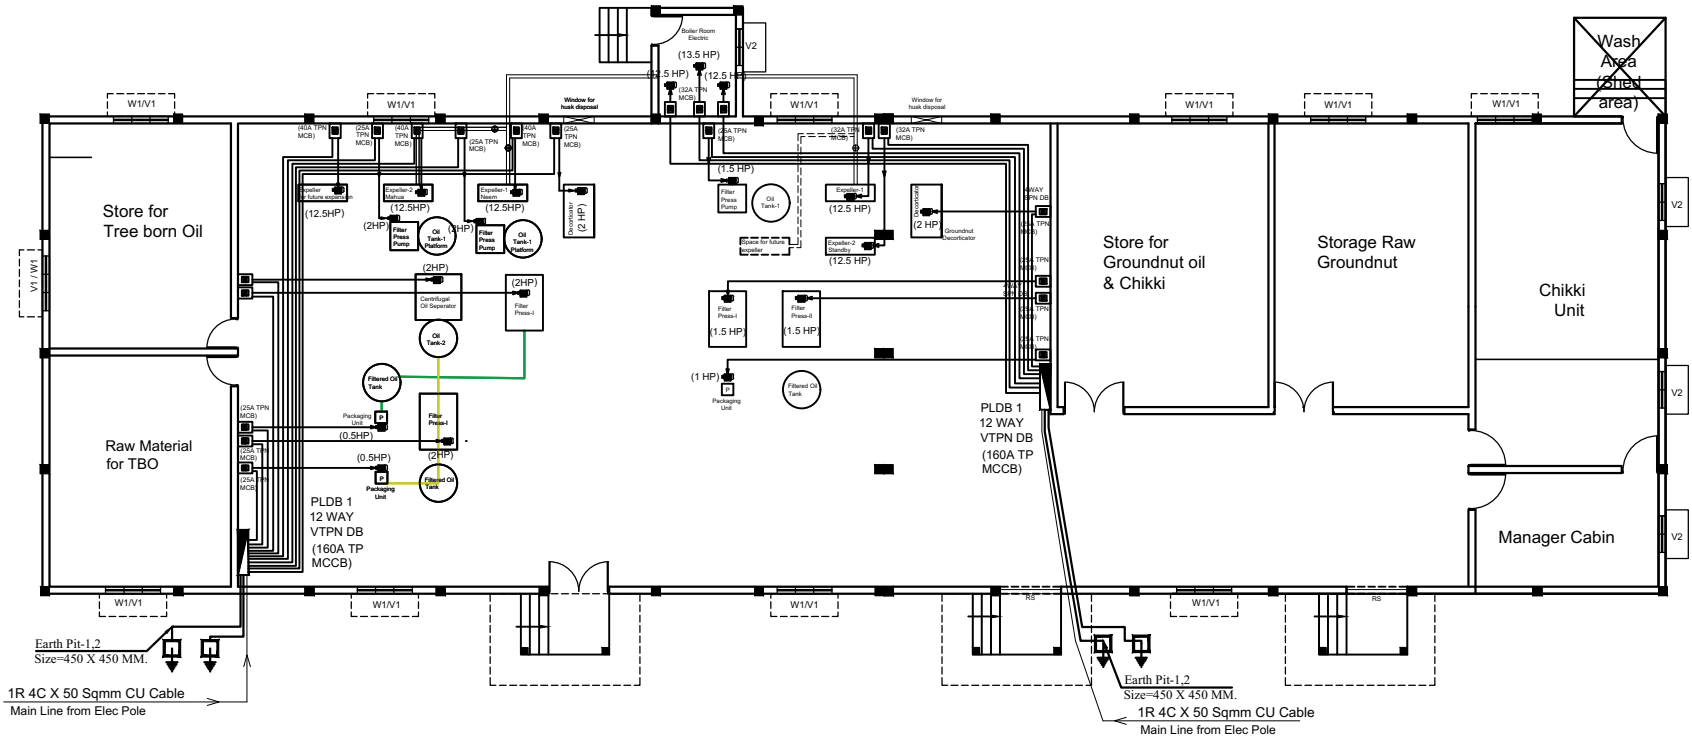


NEEM / MAHUA / KUSUM/ GROUND NUT OIL EXTRACTION UNIT

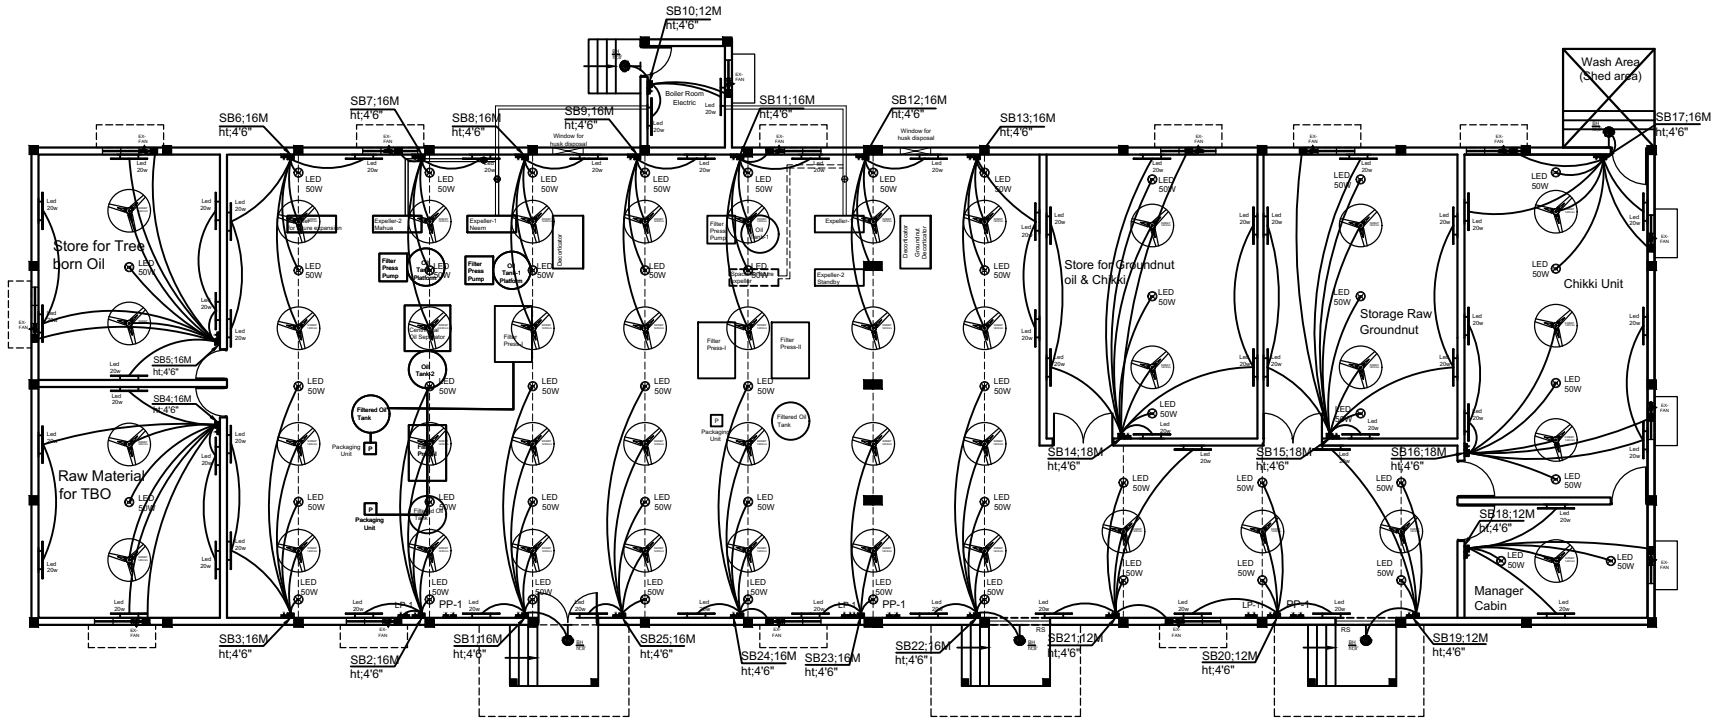

ELECTRICAL LAYOUT

DRG NO:		SHEET NO:		REV.		SCALE:		SWATI Architecture landscape interior ARCHITECTS PLANERS ENGINEERING INTERIOR DESIGN 282 , tulip , A block , Talpuri International colony , Bhilai , C.G. Email - swati.arch@outlook.com			
DP0001 DRG CL 01 105		9 OF 9		R0		NTS					
DESIGNED:		DRAWN:		CHECKED:		VERIFIED:		APPROVED:		CLIENT: CHHATTISGARH STATE MINOR FOREST PRODUCE	
UPENDRA SINGH		SIMRAN SONI		UPENDRA SINGH		ADMIN		ADMIN			
ISSUED FOR:				UNIT:		DATE:		PROJECT:		INCUBATION CENTER AT DEOBHOG GARIYABAND	
TENDOR PURPOSE				MILIMETER		12.05.2022					
This drawing is the property of HUP DESIGN and is to be used only for the purpose for which it was lent and must not be in any way detrimental to the interest of the company and is subject to return on demand								TITLE:		NEEM / MAHUA / KUSUM/ GROUND NUT OIL EXTRACTION UNIT ELECTRICAL LAYOUT	18

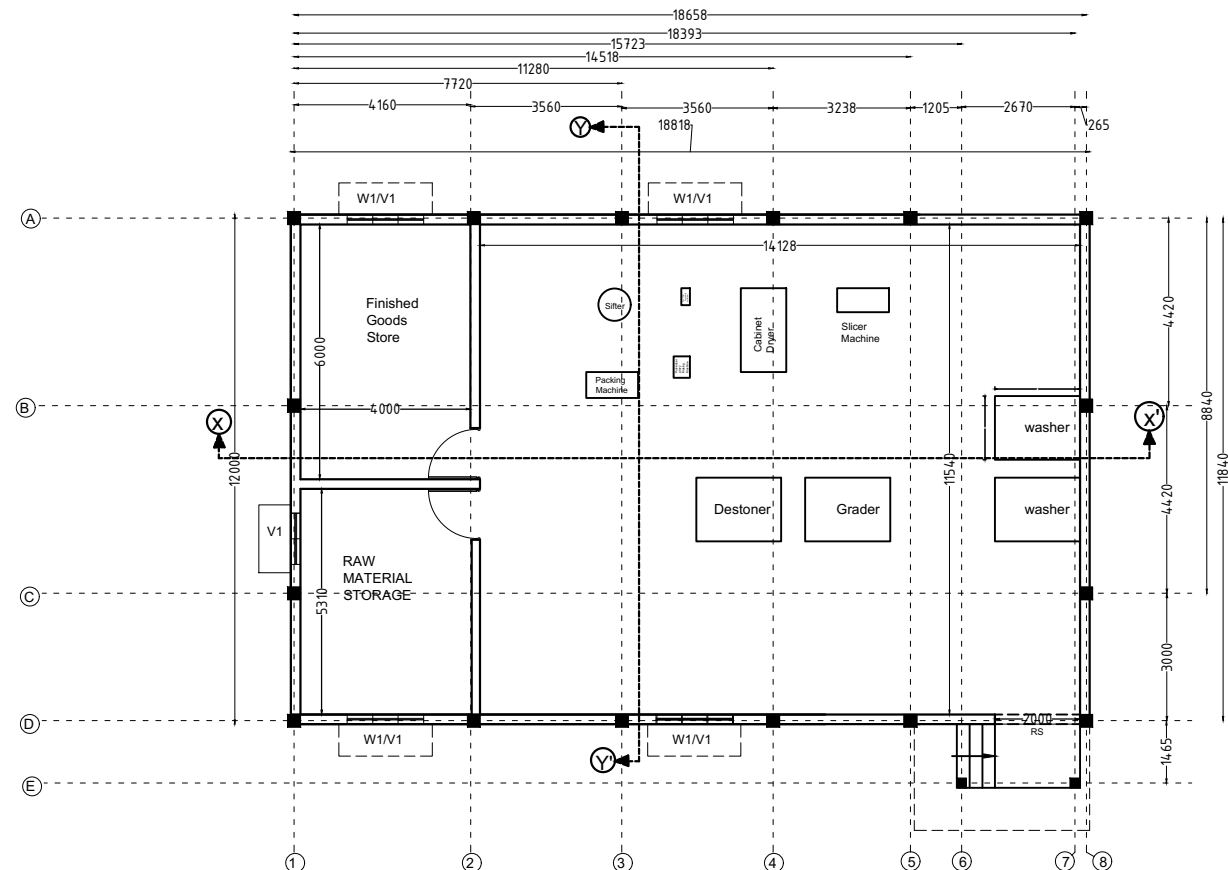

MASALA PROCESSING UNIT
BUILD UP AREA - 230 SQM





- LIST OF DRAWING**
MASALA PROCESSING UNIT
DP0001 DRG CL 01 104
- 1 - PLAN LAYOUT
 - 2 - SECTION / ELEVATION
 - 3 - COLUMN LAYOUT
 - 4 - FOOTING LAYOUT
 - 5 - BEAM LAYOUT (GROUND BEAM)
 - 6 - BEAM LAYOUT (2.4 M ABOVE PLINTH)
 - 7 - BEAM LAYOUT (4.5 M ABOVE PLINTH)
 - 8 - TRUSS DETAIL
 - 9 - ELECTRICAL LAYOUT

OPENING SCHEDULE


NAME	SAYMBOL
WINDOW	- W1
VENTILATOR	- V1
ROLLING SHUTTER	- R1
DOOR	- D1

SN	SAYMBOL	NOS	SIZE
01	W1	04	1.8M X 1.5M
02	V1	05	1.8 M X 1 M
03	D1	02	1 M X 2.1M
04	R1	01	2M X 2.1 M


DRG NO: SHEET NO: REV. SCALE:					SWATI Architecture landscape interior ARCHITECTS PLANERS ENGINEERING INTERIOR DESIGN 282 , tulip , A block , Talpuri International colony , Bhilai , C.G. Email - swati.arch@outlook.com					
DP0001 DRG CL 01 104		1 OF 9	R0	NTS						
DESIGNED:		DRAWN:	CHECKED:	VERIFIED:	APPROVED:	CLIENT: CHHATTISGARH STATE MINOR FOREST PRODUCE				
UPENDRA SINGH		SIMRAN SONI	UPENDRA SINGH	ADMIN	ADMIN					
ISSUED FOR:			UNIT:	DATE:	PROJECT: INCUBATION CENTER AT DEOBHOG GARIYABAND					
TENDOR PURPOSE			MILIMETER	12.05.2022						
This drawing is the property of HUP DESIGN and is to be used only for the purpose for which it was lent and must not be in any way detrimental to the interest of the company and is subject to return on demand					TITLE:		MASALA PROCESSING UNIT PLAN LAYOUT		19	

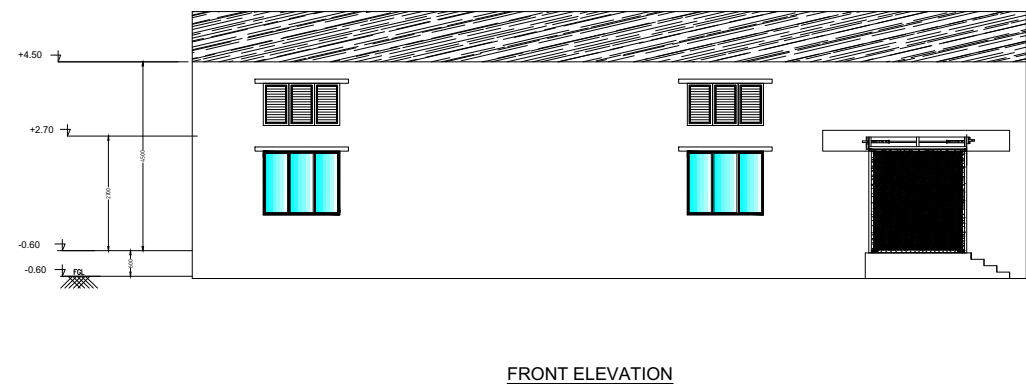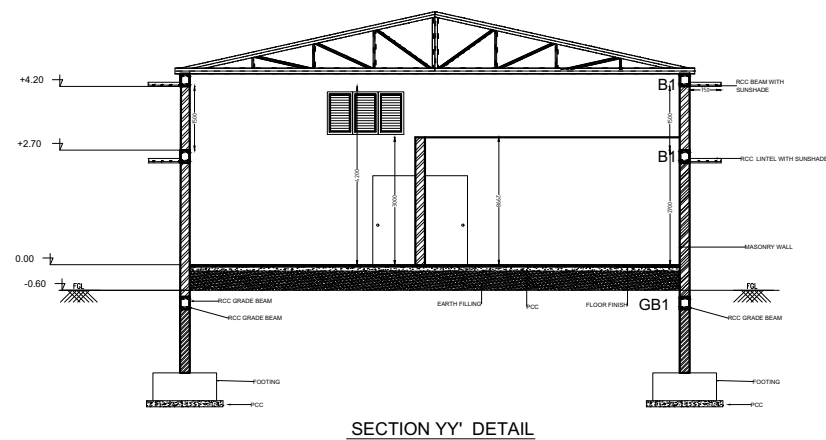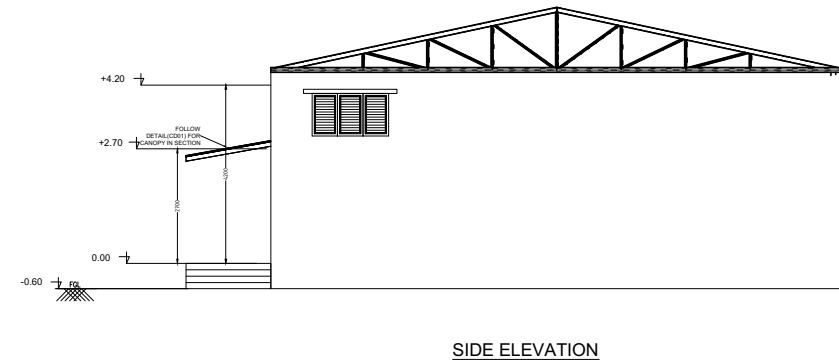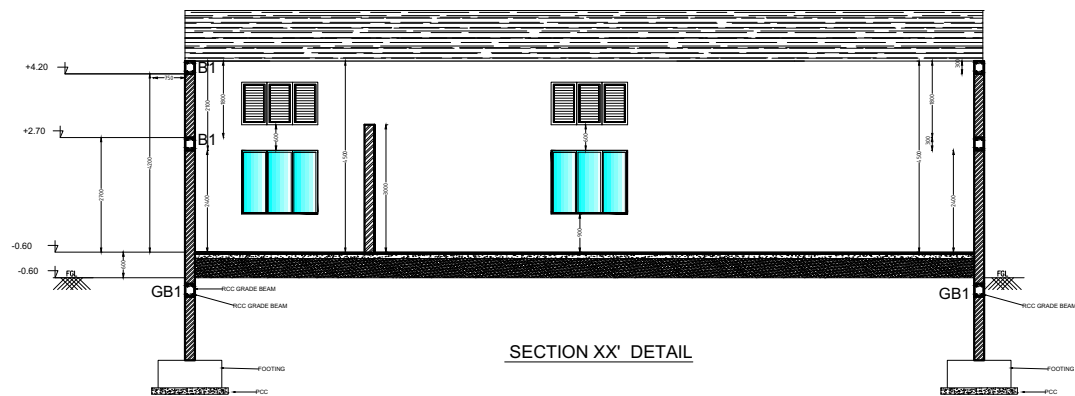

DRG NO: DP0001 DRG CL 01 104		SHEET NO: 2 OF 9		REV. R0		SCALE: NTS		SWATI Architecture landscape interior ARCHITECTS PLANERS ENGINEERING INTERIOR DESIGN 282 , tulip , A block , Talpuri International colony , Bhilai , C.G. Email - swati.arch@outlook.com			
DESIGNED: UPENDRA SINGH		DRAWN: SIMRAN SONI		CHECKED: UPENDRA SINGH		VERIFIED: ADMIN		APPROVED: ADMIN		CLIENT: CHHATTISGARH STATE MINOR FOREST PRODUCE	
ISSUED FOR: TENDOR PURPOSE				UNIT: MILIMETER		DATE: 12.05.2022		PROJECT: INCUBATION CENTER AT DEOBHOG GARIYABAND			
This drawing is the property of HUP DESIGN and is to be used only for the purpose for which it was lent and must not be in any way detrimental to the interest of the company and is subject to return on demand								TITLE: MASALA PROCESSING UNIT SECTION / ELEVATION		20	

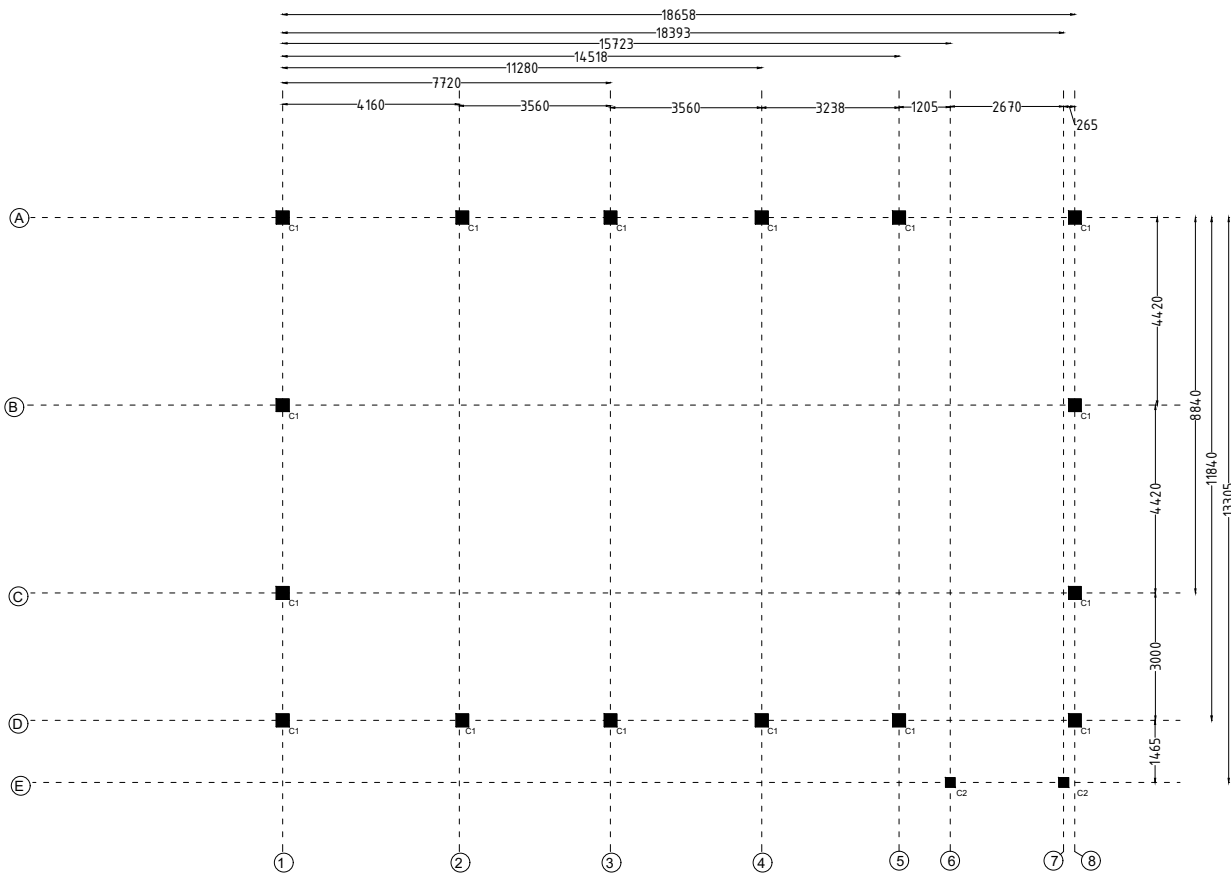

COLUMN LAYOUT

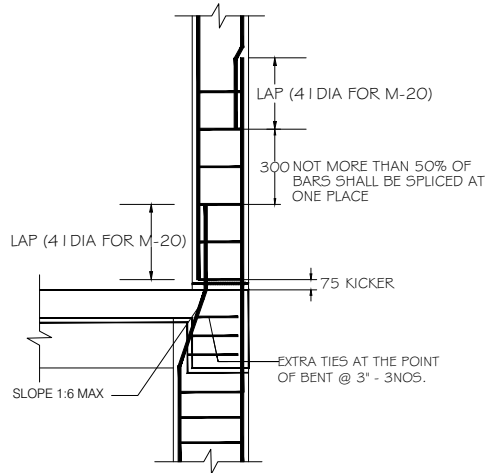


COLUMN DETAIL

GENERAL NOTES

NOTES-

 - 1. USE - M 20 GRADE OF CONC. AS/IS 426-5000
- 2. USE - FE 500 GRADE OF REINF. BY CLIENT
- 3. PROVIDE CLEAR COVER TO MAIN REINF.
- FOUNDATION- 50MM
- COLUMN - 40MM
- BEAM - 25MM
- SLAB - 20MM OR DIA OF BAR, WHICHEVER IS MORE,
- R.C.C. WALL - 25MM
- 4.TIES SHOULD BE BEND INSIDE WITH 10# LENGTH IN BEAM & COLUMN



- 5.FOLLOW - IS-456-2000 FOR R.C.C. WORK
- 6.STRIPPING TIME FOR SHUTTERING / FORMWORK UNDER NORMAL CONDITION.

TYPE OF WORK	MINIMUM PERIOD BEFORE STRIKING FORM WORK
a) VERTICAL FORMWORK TO COLUMN, WALLS, BEAM	16-24 HOUR
b) SOFFITS FORMWORK TO SLABS (PROPS TO BE REFIXED- - IMMEDIATELY AFTER REMOVAL OF FORMWORK)	3 DAYS
c) SOFFIT FORMWORK TO BEAMS (PROPS TO BE REFIXED IMMEDIATELY AFTER REMOVAL OF FORMWORK)	7DAYS
d) PROPS TO SLABS:	
1) SPANNING UP TO 4.5M	7DAYS
2) SPANNING OVER 4.5M	14 DAYS
e) PROPS TO BEAMS & ARCHES:	
1) SPANNING UP TO 6M	14DAYS
2) SPANNING OVER 6M	21DAYS
7. CURING FOR R.C.C. MEMBER MINIMUM 14 DAYS CONTINOUSELY PREFERABLE - 28 DAYS.	
8. START EARLY CURING TO AVOID SRINKAGE CRACKS, WHEN CONCRETE APPEARS TO HARDEN.	
9) PROVIDE FOLLOWING SLUMP IN CONCRETE GEN-ERALLY.	
a) SHALLOW SECTIONS, PAVMENTS, MASS CONC. LIGTH REINFORCEMENT	25-75
b) HEAVILY REINFORCEMENT SECTION IN SLAB	50-100
c) HEAVILY REINFORCEMENT SECTION IN BEAMS, WALLS, COLUMNS SLIPFORM, OR PUMPED CONC.	75-100
d) TRENCH FILL, PILLING, PUMPED CONC.	100-150
10) PROVIDE LAP/ DEVELOPEMENT LENGTH IN REINFORCEMENT BARS GRADE OF CONC.	
	M20- 47Ø
	M25-41Ø
	M30-38Ø
11) REFER RELEVANT DRG. WITH THIS DRG.	
12) AVOID CORE CUTING.	

TYPICAL COLUMN DETAIL'S

COLUMN NAME	Pile/col detail	STIRRUPS	REMARKS
C1	 8-T12 T8@ 200 c/c 2-Tie		FOUNDATION TO TERRACE
C1	 4-T12 T8@ 200 c/c 1-Tie		TERMINATE AT GROUND LVL.

DRG NO: DP0001 DRG CL 01 104					SHEET NO: 3 OF 9					REV. R0					SCALE: NTS					SWATI Architecture landscape interior ARCHITECTS PLANERS ENGINEERING INTERIOR DESIGN 282 , tulip , A block , Talpuri International colony , Bhilai , C.G. Email - swati.arch@outlook.com																			
DESIGNED: UPENDRA SINGH					DRAWN: SIMRAN SONI					CHECKED: UPENDRA SINGH					VERIFIED: ADMIN					APPROVED: ADMIN					CLIENT: CHHATTISGARH STATE MINOR FOREST PRODUCE														
ISSUED FOR: TENDOR PURPOSE										UNIT: MILIMETER					DATE: 12.05.2022					PROJECT: INCUBATION CENTER AT DEOBHOG GARIYABAND																			
This drawing is the property of HUP DESIGN and is to be used only for the purpose for which it was lent and must not be in any way detrimental to the interest of the company and is subject to return on demand																				TITLE: MASALA PROCESSING UNIT COLUMN LAYOUT										21									

GENERAL NOTES

NOTES-

1. USE - M 20 GRADE OF CONC. AS/IS 426-5000
2. USE - FE 500 GRADE OF REINF. BY CLIENT
3. PROVIDE CLEAR COVER TO MAIN REINF.
- FOUNDATION- 50MM
COLUMN - 40MM
BEAM - 25MM
SLAB - 20MM OR DIA OF BAR, WHICHEVER IS MORE,
R.C.C. WALL - 25MM
- 4.TIES SHOULD BE BEND INSIDE WITH 10# LENGTH
IN BEAM & COLUMN

- 5.FOLLOW - IS-456-2000 FOR R.C.C. WORK
6.STRIPPING TIME FOR SHUTTERING / FORMWORK
UNDER NORMAL CONDITION.


TYPE OF WORK	MINIMUM PERIOD BEFORE STRIKING FORM WORK
--------------	--

- a) VERTICAL FORMWORK TO
COLUMN, WALLS, BEAM 16-24 HOUR
- b) SOFFITS FORMWORK TO
SLABS (PROPS TO BE REFIXED-
- IMMEDIATELY AFTER REMOVAL
OF FORMWORK) 3 DAYS
- c) SOFFIT FORMWORK TO BEAMS
(PROPS TO BE REFIXED IMMEDIATELY
AFTER REMOVAL OF FORMWORK) 7DAYS
- d) PROPS TO SLABS:
- 1) SPANNING UP TO 4.5M 7DAYS
2) SPANNING OVER 4.5M 14 DAYS
- e) PROPS TO BEAMS & ARCHES:
- 1) SPANNING UP TO 6M 14DAYS
2) SPANNING OVER 6M 21DAYS



7. CURING FOR R.C.C. MEMBER MINIMUM 14 DAYS
CONTINOUSELY PREFERABLE - 28 DAYS.
8. START EARLY CURING TO AVOID SRINKAGE
CRACKS, WHEN CONCRETE APPEARS TO HARDEN.
- 9) PROVIDE FOLLOWING SLUMP IN CONCRETE GEN-
-ERALLY.
- a) SHALLOW SECTIONS, PAVMENTS,
MASS CONC. LIGTH REINFORCEMENT
SECTION IN SLAB, BEAM, WALL, COLUMN 25-75
- b) HEAVILY REINFORCEMENT SECTION IN
SLAB 50-100
- c) HEAVILY REINFORCEMENT SECTION IN
BEAMS, WALLS, COLUMNS SLIPFORM, OR
PUMPED CONC. 75-100
- d) TRENCH FILL, PILLING, PUMPED CONC.
100-150
- 10) PROVIDE LAP/ DEVELOPEMENT LENGTH
IN REINFORCEMENT BARS GRADE OF CONC.

M20- 47Ø
M25-41Ø
M30-38Ø

- 11) REFER RELEVANT DRG. WITH THIS DRG.
12) AVOID CORE CUTING.

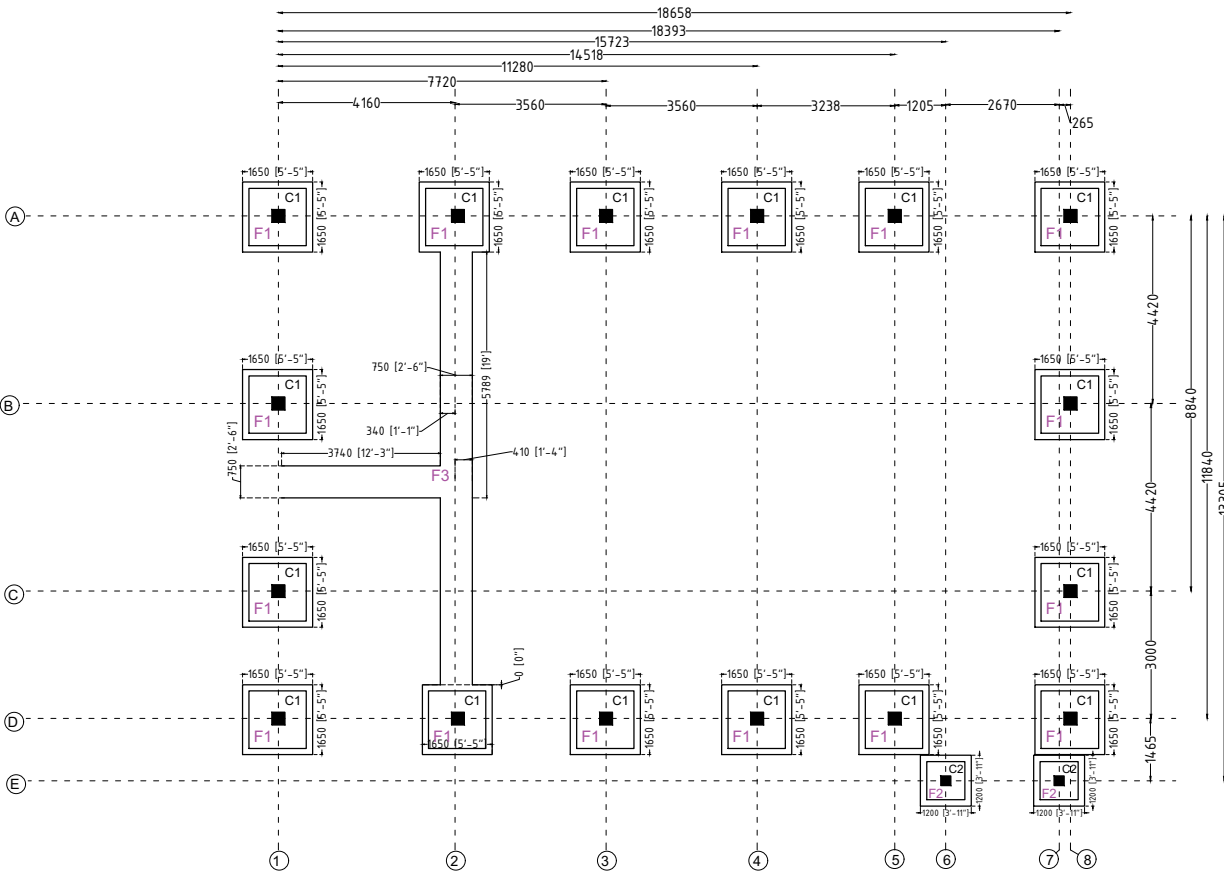

FOOTING LAYOUT

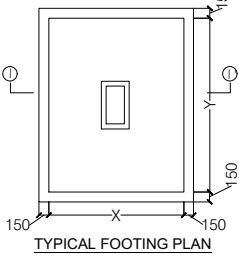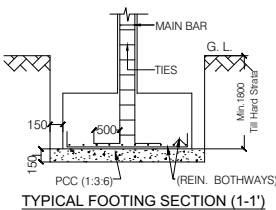

FOOTING SCHEDULE

FE500 AND M20						
Footing	Column	PCC Size	Footing Size	Total	Steel	Steel
	Nos	X - Y mm	X - Y mm	Depth mm	to X mm	to Y mm
F1	C1	1650 X 1650	1350 X 1350	400	T10@ 175C/C	T10@ 175 C/C
F2	C2	1200 X 1200	900 X 900	230	T8@200C/C	T8@ 200 C/C

DRG NO:	SHEET NO:	REV.	SCALE:
DP0001 DRG CL 01 104	4 OF 9	R0	NTS
DESIGNED:	DRAWN:	CHECKED:	VERIFIED:
UPENDRA SINGH	SIMRAN SONI	UPENDRA SINGH	ADMIN
ISSUED FOR:	UNIT:	DATE:	
TENDOR PURPOSE	MILIMETER	12.05.2022	


This drawing is the property of HUP DESIGN and is to be used only for the purpose for which it was lent and must not be in any way detrimental to the interest of the company and is subject to return on demand

SWATI Architecture landscape interior
ARCHITECTS | PLANERS | ENGINEERING | INTERIOR DESIGN
282 , tulip , A block , Talpuri International colony , Bhilai , C.G. Email - swati.arch@outlook.com

CHHATTISGARH STATE MINOR FOREST PRODUCE

INCUBATION CENTER AT DEOBHOG GARIYABAND


MASALA PROCESSING UNIT
FOOTING LAYOUT

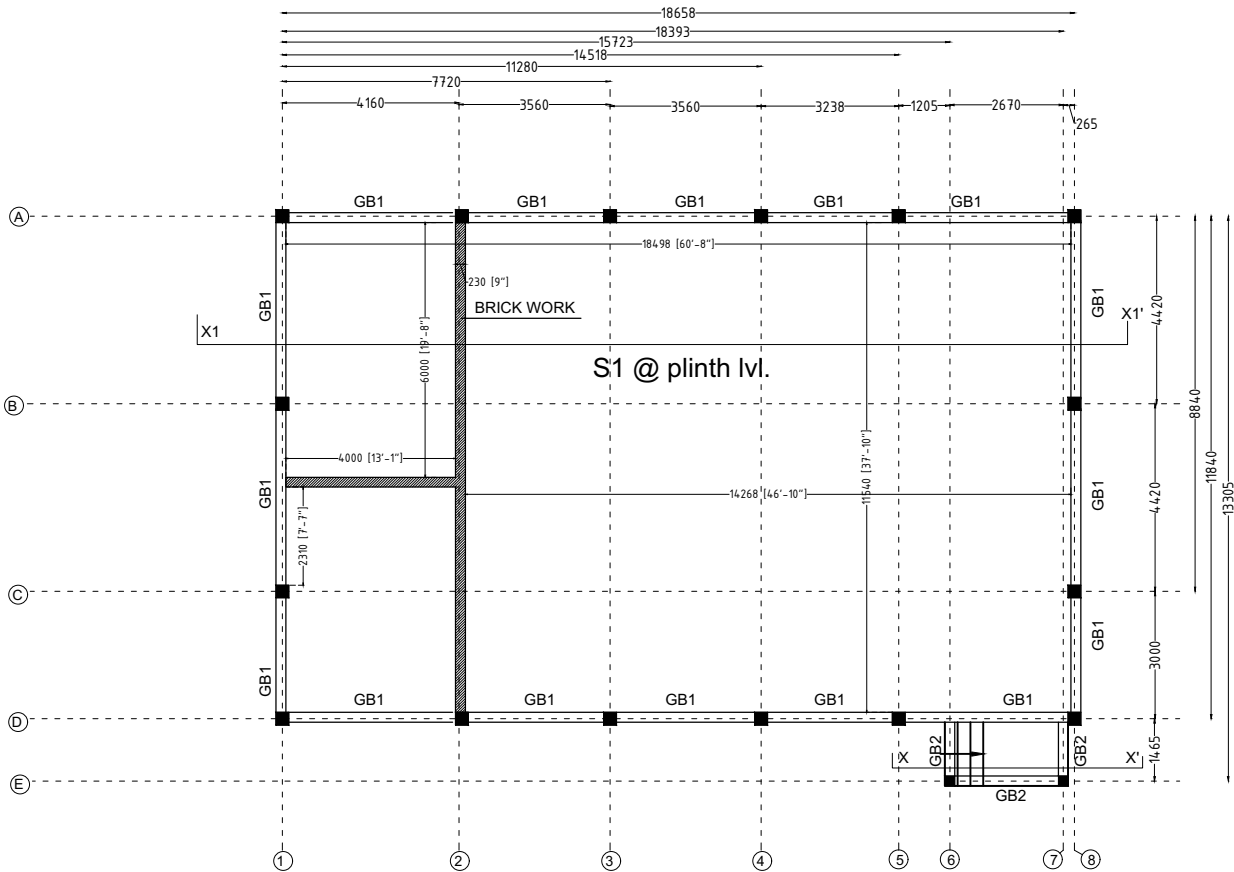

GROUND BEAM LAYOUT

BEAM SCHEDULE FOR GROUND/ PLINTH LVL.									
Beam No.	Beam Name	Top	Bottom	Left	Right	Top	Bottom	Left	Right
GB1	230X375	2-T16	2-T12	2-T16	2-T12	2-T12	2-T12	T8 @200C/C	T8 @175C/C
GB2	230X230	2-T12	-	2-T10	-	-	-	T8 @200C/C	T8 @200C/C

SLAB SCHEDULE FOR GROUND FLOOR LVL.				
Slab Name	Thickness (mm)	Main Steel		remarks
		T8 @ 200 c/c	T8 @ 200 c/c	
S1	150 (MESH)	T8 @ 200 c/c	T8 @ 200 c/c	All straight

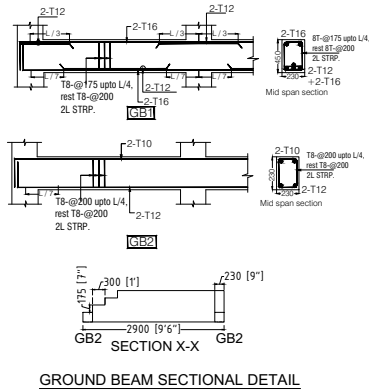


GROUND BEAM SECTIONAL DETAIL

GENERAL NOTES

NOTES-

 - USE - M 20 GRADE OF CONC. AS/IS 426-5000
 - USE - FE 500 GRADE OF REINF. BY CLIENT
 - PROVIDE CLEAR COVER TO MAIN REINF.
- FOUNDATION- 50MM
COLUMN - 40MM
BEAM - 25MM
SLAB - 20MM OR DIA OF BAR, WHICHEVER IS MORE,
R.C.C. WALL - 25MM
- TIES SHOULD BE BEND INSIDE WITH 10# LENGTH IN BEAM & COLUMN




- FOLLOW - IS-456-2000 FOR R.C.C. WORK
- STRIPPING TIME FOR SHUTTERING / FORMWORK UNDER NORMAL CONDITION.

TYPE OF WORK	MINIMUM PERIOD BEFORE STRIKING FORM WORK
--------------	--

- VERTICAL FORMWORK TO COLUMN, WALLS, BEAM 16-24 HOUR
- SOFFITS FORMWORK TO SLABS (PROPS TO BE REFIXED- IMMEDIATELY AFTER REMOVAL OF FORMWORK) 3 DAYS
- SOFFIT FORMWORK TO BEAMS (PROPS TO BE REFIXED IMMEDIATELY AFTER REMOVAL OF FORMWORK) 7DAYS
- PROPS TO SLABS:
 - 1) SPANNING UP TO 4.5M 7DAYS
 - 2) SPANNING OVER 4.5M 14 DAYS
- PROPS TO BEAMS & ARCHES:
 - 1) SPANNING UP TO 6M 14DAYS
 - 2) SPANNING OVER 6M 21DAYS

- CURING FOR R.C.C. MEMBER MINIMUM 14 DAYS CONTINOUSELY PREFERABLE - 28 DAYS.
 - START EARLY CURING TO AVOID SRINKAGE CRACKS, WHEN CONCRETE APPEARS TO HARDEN.
 - PROVIDE FOLLOWING SLUMP IN CONCRETE GEN-ERALLY.
 - SHALLOW SECTIONS, PAVMENTS, MASS CONC. LIGTH REINFORCEMENT SECTION IN SLAB, BEAM, WALL, COLUMN 25-75
 - HEAVILY REINFORCEMENT SECTION IN SLAB 50-100
 - HEAVILY REINFORCEMENT SECTION IN BEAMS, WALLS, COLUMNS SLIPFORM, OR PUMPED CONC. 75-100
 - TRENCH FILL, PILLING, PUMPED CONC. 100-150
 - PROVIDE LAP/ DEVELOPEMENT LENGTH IN REINFORCEMENT BARS GRADE OF CONC.
 - M20- 47Ø
 - M25-41Ø
 - M30-38Ø
- REFER RELEVANT DRG. WITH THIS DRG.
 - AVOID CORE CUTING.


DRG NO: DP0001 DRG CL 01 104	SHEET NO: 5 OF 9	REV. R0	SCALE: NTS	SWATI Architecture landscape interior ARCHITECTS PLANERS ENGINEERING INTERIOR DESIGN 282 , tulip , A block , Talpuri International colony , Bhilai , C.G. Email - swati.arch@outlook.com	
DESIGNED: UPENDRA SINGH	DRAWN: SIMRAN SONI	CHECKED: UPENDRA SINGH	VERIFIED: ADMIN	APPROVED: ADMIN	CLIENT: CHHATTISGARH STATE MINOR FOREST PRODUSE
ISSUED FOR: TENDOR PURPOSE	UNIT: MILIMETER	DATE: 12.05.2022	PROJECT: INCUBATION CENTER AT DEOBHOG GARIYABAND	TITLE: MASALA PROCESSING UNIT BEAM LAYOUT	
This drawing is the property of HUP DESIGN and is to be used only for the purpose for which it was lent and must not be in any way detrimental to the interest of the company and is subject to return on demand				23	

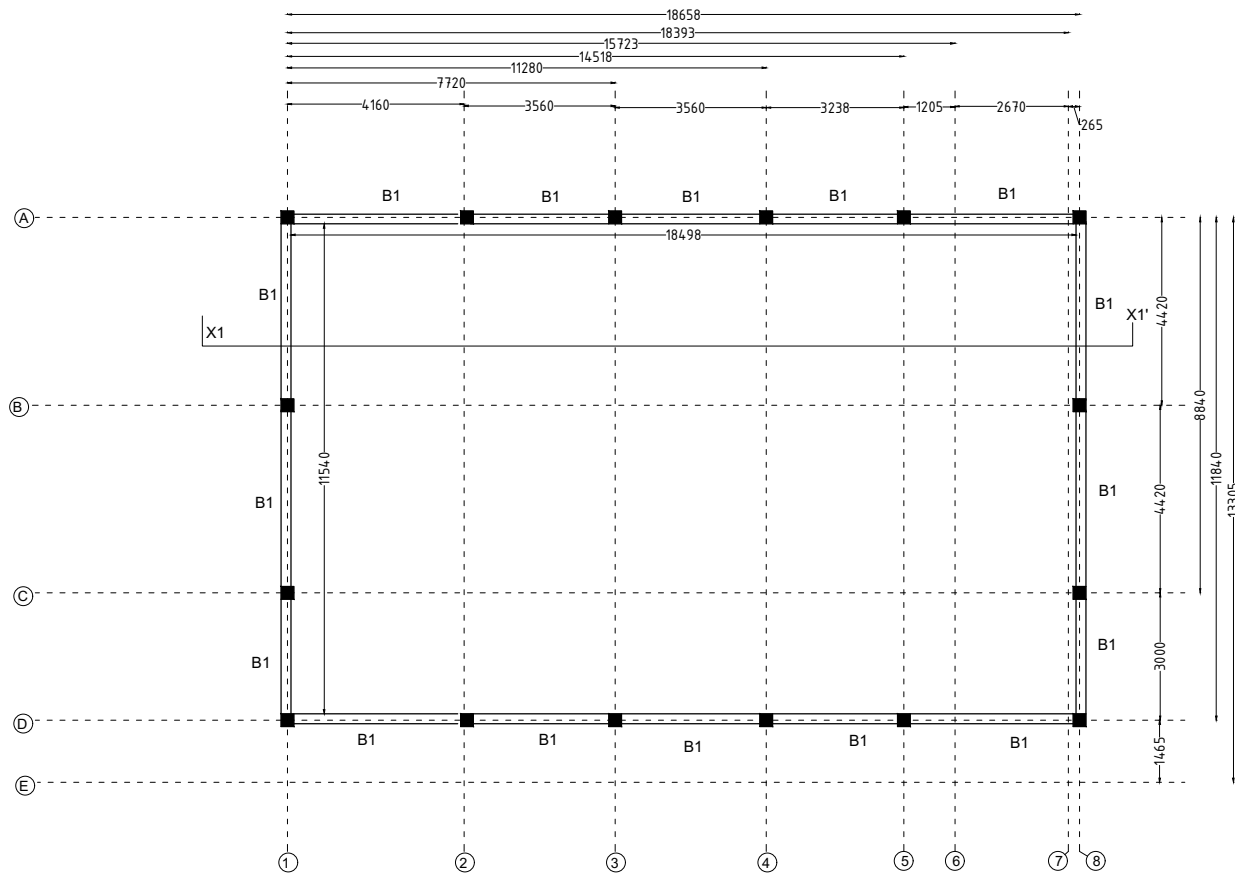

BEAM PLAN(2.4 m ABOVE PLINTH LVL)

BEAM SCHEDULE FOR 2.4m LVL. ABOVE PLINTH


B1	230X300	2-T12	2-T12	2-T12	2-T12	2-T12	T8 @200/C	T8 @175/C	T8 @175/C	SLAB THK. INCLUDED

 

GENERAL NOTES

NOTES-

 - USE - M 20 GRADE OF CONC. AS/IS 426-5000
 - USE - FE 500 GRADE OF REINF. BY CLIENT
 - PROVIDE CLEAR COVER TO MAIN REINF.
- FOUNDATION- 50MM
COLUMN - 40MM
BEAM - 25MM
SLAB - 20MM OR DIA OF BAR, WHICHEVER IS MORE,
R.C.C. WALL - 25MM
- TIES SHOULD BE BEND INSIDE WITH 10# LENGTH IN BEAM & COLUMN




- FOLLOW - IS-456-2000 FOR R.C.C. WORK
- STRIPPING TIME FOR SHUTTERING / FORMWORK UNDER NORMAL CONDITION.

TYPE OF WORK	MINIMUM PERIOD BEFORE STRIKING FORM WORK
--------------	--


- | | |
|--|------------|
| a) VERTICAL FORMWORK TO COLUMN, WALLS, BEAM | 16-24 HOUR |
| b) SOFFITS FORMWORK TO SLABS (PROPS TO BE REFIXED- IMMEDIATELY AFTER REMOVAL OF FORMWORK) | 3 DAYS |
| c) SOFFIT FORMWORK TO BEAMS (PROPS TO BE REFIXED IMMEDIATELY AFTER REMOVAL OF FORMWORK) | 7DAYS |
| d) PROPS TO SLABS: | |
| 1) SPANNING UP TO 4.5M | 7DAYS |
| 2) SPANNING OVER 4.5M | 14 DAYS |
| e) PROPS TO BEAMS & ARCHES: | |
| 1) SPANNING UP TO 6M | 14DAYS |
| 2) SPANNING OVER 6M | 21DAYS |

- CURING FOR R.C.C. MEMBER MINIMUM 14 DAYS CONTINOUSELY PREFERABLE - 28 DAYS.
- START EARLY CURING TO AVOID SRINKAGE CRACKS, WHEN CONCRETE APPEARS TO HARDEN.
- PROVIDE FOLLOWING SLUMP IN CONCRETE GENERALLY.
- a) SHALLOW SECTIONS, PAVMENTS, MASS CONC. LIGTH REINFORCEMENT SECTION IN SLAB, BEAM, WALL, COLUMN 25-75
- b) HEAVILY REINFORCEMENT SECTION IN SLAB 50-100
- c) HEAVILY REINFORCEMENT SECTION IN BEAMS, WALLS, COLUMNS SLIPFORM, OR PUMPED CONC. 75-100
- d) TRENCH FILL, PILLING, PUMPED CONC. 100-150
- 10) PROVIDE LAP/ DEVELOPEMENT LENGTH IN REINFORCEMENT BARS GRADE OF CONC.
M20- 47Ø
M25-41Ø
M30-38Ø
- 11) REFER RELEVANT DRG. WITH THIS DRG.
- 12) AVOID CORE CUTING.

DRG NO: DP0001 DRG CL 01 104	SHEET NO: 6 OF 9	REV. R0	SCALE: NTS	SWATI Architecture landscape interior ARCHITECTS PLANERS ENGINEERING INTERIOR DESIGN 282 , tulip , A block , Talpuri International colony , Bhilai , C.G. Email - swati.arch@outlook.com	
DESIGNED: UPENDRA SINGH	DRAWN: SIMRAN SONI	CHECKED: UPENDRA SINGH	VERIFIED: ADMIN	APPROVED: ADMIN	CLIENT: CHHATTISGARH STATE MINOR FOREST PRODUCE
ISSUED FOR: TENDOR PURPOSE	UNIT: MILIMETER	DATE: 12.05.2022	PROJECT: INCUBATION CENTER AT DEOBHOG GARIYABAND		
This drawing is the property of HUP DESIGN and is to be used only for the purpose for which it was lent and must not be in any way detrimental to the interest of the company and is subject to return on demand				TITLE: MASALA PROCESSING UNIT BEAM LAYOUT	24

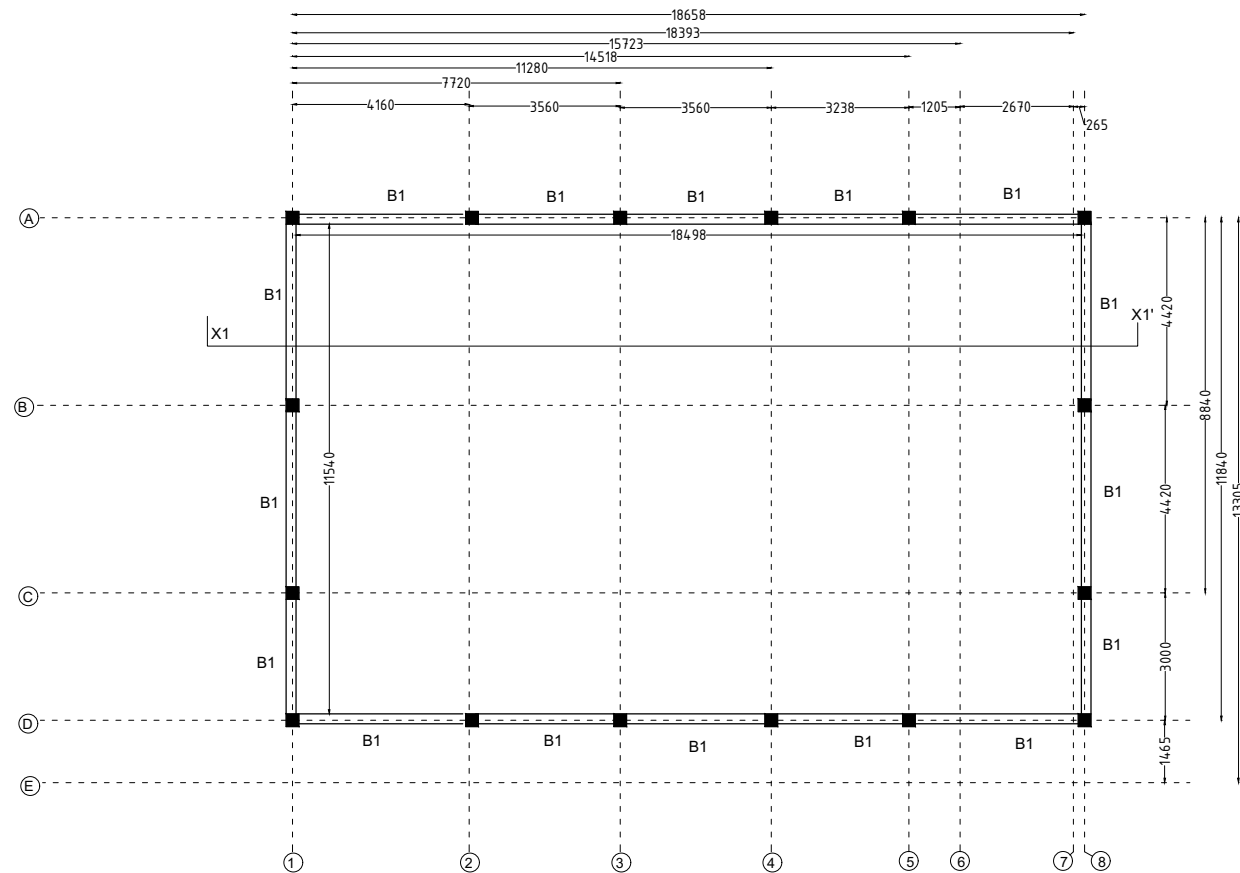

BEAM PLAN (4.5 ABOVE PLINTH LVL)

 


BEAM SCHEDULE FOR 4.5m LVL. ABOVE PLINTH

Beam ID	Size	Top Bar	Bottom Bar	Stirrups	Notes
B1	230X300	2-T12	2-T10	T8 @ 200/C/C	Rest T8 @ 175/C/C

GENERAL NOTES

 - NOTES-
- USE - M 20 GRADE OF CONC. AS/IS 426-5000
 - USE - FE 500 GRADE OF REINF. BY CLIENT
 - PROVIDE CLEAR COVER TO MAIN REINF.
- FOUNDATION- 50MM
COLUMN - 40MM
BEAM - 25MM
SLAB - 20MM OR DIA OF BAR, WHICHEVER IS MORE,
R.C.C. WALL - 25MM
- 4.TIES SHOULD BE BEND INSIDE WITH 10# LENGTH IN BEAM & COLUMN



- FOLLOW - IS-456-2000 FOR R.C.C. WORK
- STRIPPING TIME FOR SHUTTERING / FORMWORK UNDER NORMAL CONDITION.

TYPE OF WORK	MINIMUM PERIOD BEFORE STRIKING FORM WORK
a) VERTICAL FORMWORK TO COLUMN, WALLS, BEAM	16-24 HOUR
b) SOFFITS FORMWORK TO SLABS (PROPS TO BE REFIXED- IMMEDIATELY AFTER REMOVAL OF FORMWORK)	3 DAYS
c) SOFFIT FORMWORK TO BEAMS (PROPS TO BE REFIXED IMMEDIATELY AFTER REMOVAL OF FORMWORK)	7DAYS
d) PROPS TO SLABS:	
1) SPANNING UP TO 4.5M	7DAYS
2) SPANNING OVER 4.5M	14 DAYS
e) PROPS TO BEAMS & ARCHES:	
1) SPANNING UP TO 6M	14DAYS
2) SPANNING OVER 6M	21DAYS

- CURING FOR R.C.C. MEMBER MINIMUM 14 DAYS CONTINOUSELY PREFERABLE - 28 DAYS.
 - START EARLY CURING TO AVOID SRINKAGE CRACKS, WHEN CONCRETE APPEARS TO HARDEN.
 - PROVIDE FOLLOWING SLUMP IN CONCRETE GEN-ERALLY.
 - a) SHALLOW SECTIONS, PAVMENTS, MASS CONC. LIGTH REINFORCEMENT SECTION IN SLAB, BEAM, WALL, COLUMN
 - b) HEAVILY REINFORCEMENT SECTION IN SLAB
 - c) HEAVILY REINFORCEMENT SECTION IN BEAMS, WALLS, COLUMNS SLIPFORM, OR PUMPED CONC.
 - d) TRENCH FILL, PILLING, PUMPED CONC.
 - 10) PROVIDE LAP/ DEVELOPEMENT LENGTH IN REINFORCEMENT BARS GRADE OF CONC.
- M20- 47Ø
M25-41Ø
M30-38Ø

- REFER RELEVANT DRG. WITH THIS DRG.
- AVOID CORE CUTING.

DRG NO:
DP0001 DRG CL 01 104

SHEET NO:
7 OF 9

REV.
R0

SCALE:
NTS

DESIGNED:
UPENDRA SINGH

DRAWN:
SIMRAN SONI

CHECKED:
UPENDRA SINGH

VERIFIED:
ADMIN

APPROVED:
ADMIN

ISSUED FOR:
TENDOR PURPOSE

UNIT:
MILIMETER

DATE:
12.05.2022

CLIENT:
CHHATTISGARH STATE MINOR FOREST PRODUSE


PROJECT:
INCUBATION CENTER AT DEOBHOG GARIYABAND

TITLE:
**MASALA PROCESSING UNIT
BEAM LAYOUT**


SWATI Architecture landscape interior
ARCHITECTS | PLANERS | ENGINEERING | INTERIOR DESIGN
282 , tulip , A block , Talpuri International colony , Bhilai , C.G. Email - swati.arch@outlook.com

25


This drawing is the property of HUP DESIGN and is to be used only for the purpose for which it was lent and must not be in any way detrimental to the interest of the company and is subject to return on demand

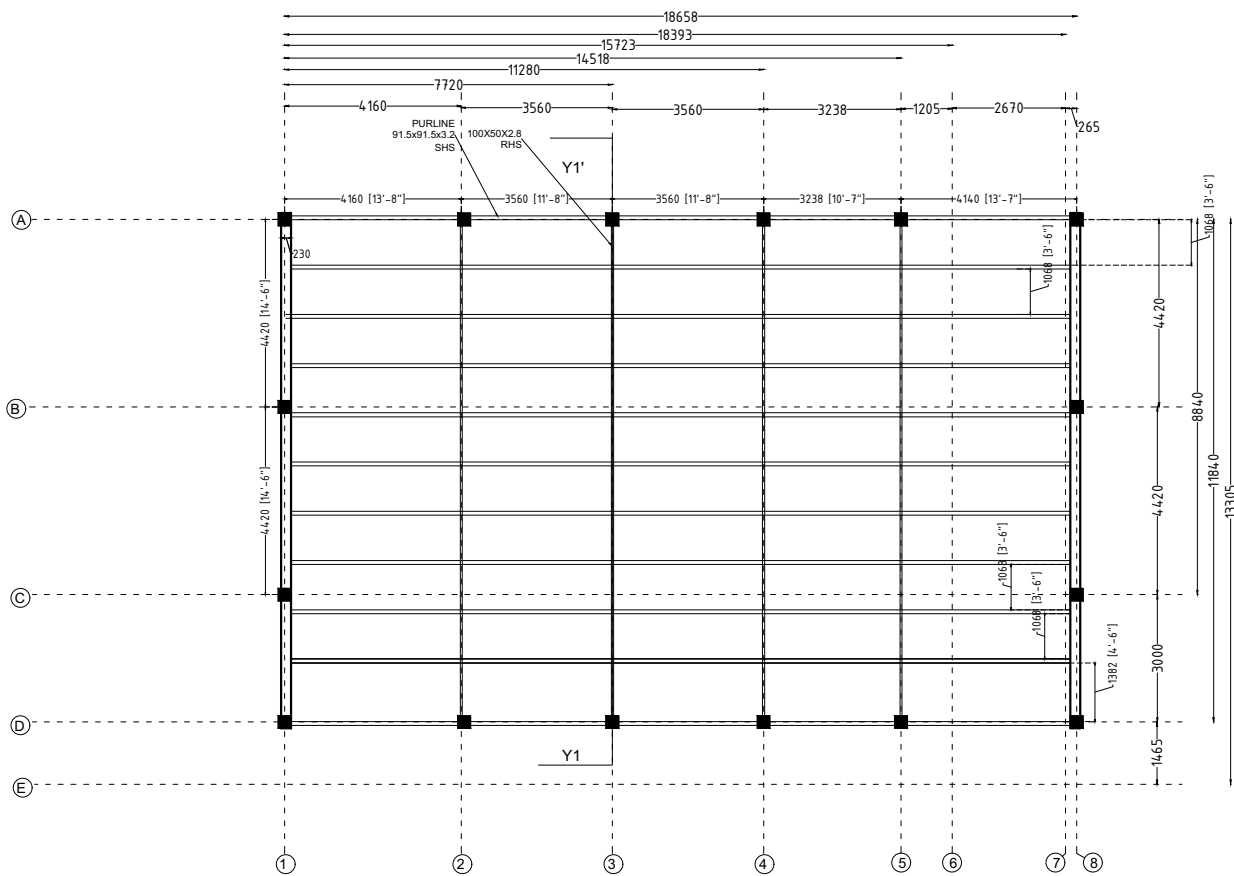


ROOF TRUSS DETAIL

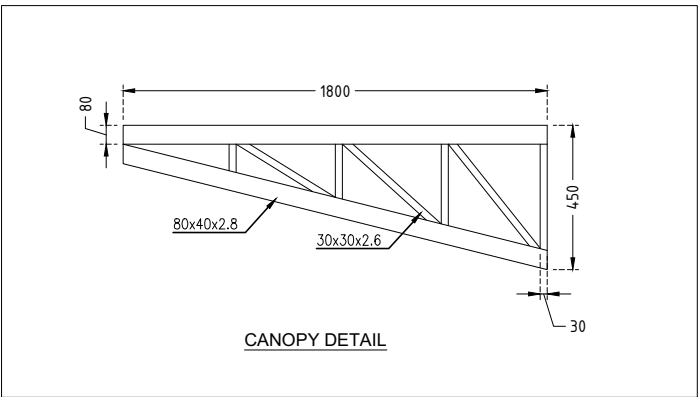

CANOPY DETAIL

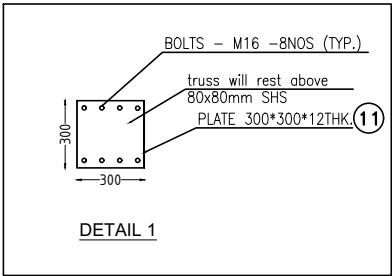

DETAIL 1

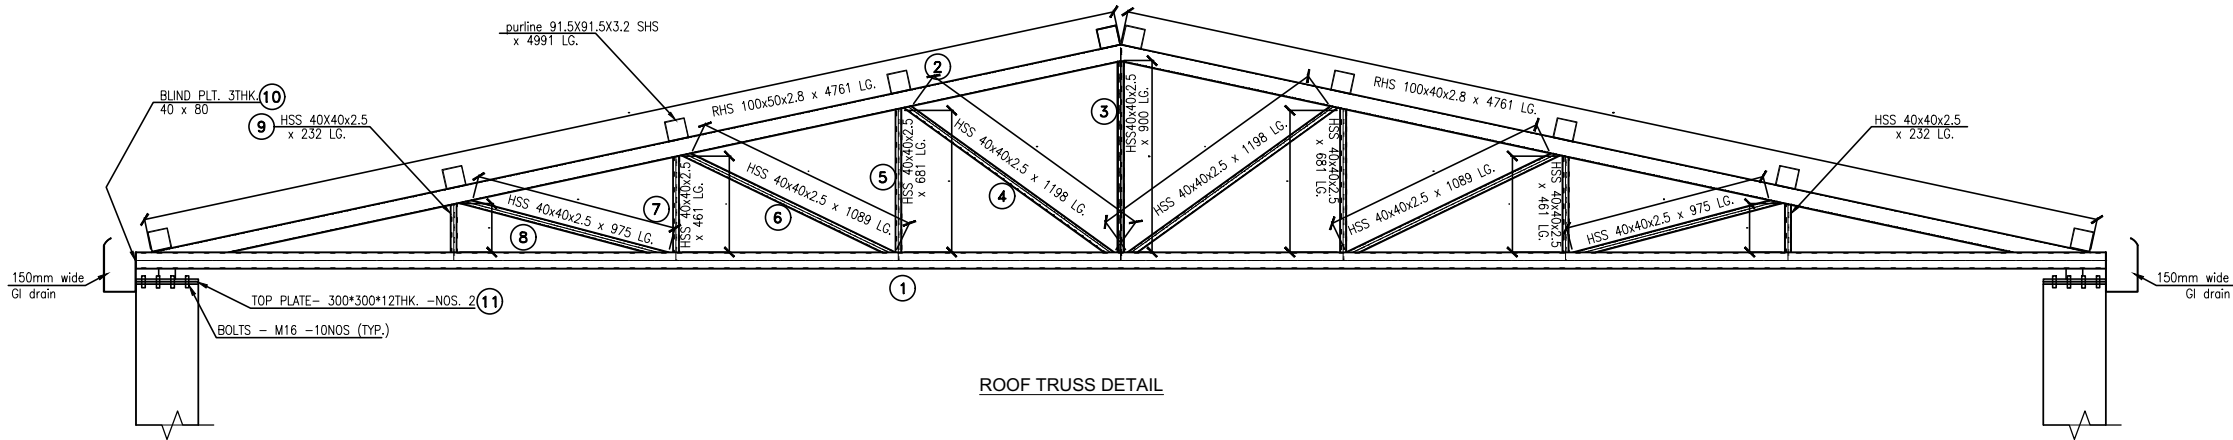


ROOF TRUSS DETAIL

GENERAL NOTES

NOTES-

 - 1. USE - M 20 GRADE OF CONC. AS/IS 426-5000
- 2. USE - FE 500 GRADE OF REINF. BY CLIENT
- 3. PROVIDE CLEAR COVER TO MAIN REINF.
- FOUNDATION- 50MM
- COLUMN - 40MM
- BEAM - 25MM
- SLAB - 20MM OR DIA OF BAR, WHICHEVER IS MORE,
- R.C.C. WALL - 25MM
- 4.TIES SHOULD BE BEND INSIDE WITH 10# LENGTH IN BEAM & COLUMN



- 5.FOLLOW - IS-456-2000 FOR R.C.C. WORK
- 6.STRIPPING TIME FOR SHUTTERING / FORMWORK UNDER NORMAL CONDITION.

TYPE OF WORK	MINIMUM PERIOD BEFORE STRIKING FORM WORK
--------------	--


- a) VERTICAL FORMWORK TO COLUMN, WALLS, BEAM 16-24 HOUR
- b) SOFFITS FORMWORK TO SLABS (PROPS TO BE REFIXED- IMMEDIATELY AFTER REMOVAL OF FORMWORK) 3 DAYS
- c) SOFFIT FORMWORK TO BEAMS (PROPS TO BE REFIXED IMMEDIATELY AFTER REMOVAL OF FORMWORK) 7DAYS
- d) PROPS TO SLABS:
 - 1) SPANNING UP TO 4.5M 7DAYS
 - 2) SPANNING OVER 4.5M 14 DAYS
- e) PROPS TO BEAMS & ARCHES:
 - 1) SPANNING UP TO 6M 14DAYS
 - 2) SPANNING OVER 6M 21DAYS

- 7. CURING FOR R.C.C. MEMBER MINIMUM 14 DAYS CONTINOUSELY PREFERABLE - 28 DAYS.
- 8. START EARLY CURING TO AVOID SRINKAGE CRACKS, WHEN CONCRETE APPEARS TO HARDEN.
- 9) PROVIDE FOLLOWING SLUMP IN CONCRETE GEN-ERALLY.
 - a) SHALLOW SECTIONS, PAVMENTS, MASS CONC. LIGTH REINFORCEMENT SECTION IN SLAB, BEAM, WALL, COLUMN 25-75
 - b) HEAVILY REINFORCEMENT SECTION IN SLAB 50-100
 - c) HEAVILY REINFORCEMENT SECTION IN BEAMS, WALLS, COLUMNS SLIPFORM, OR PUMPED CONC. 75-100
 - d) TRENCH FILL, PILLING, PUMPED CONC. 100-150
- 10) PROVIDE LAP/ DEVELOPEMENT LENGTH IN REINFORCEMENT BARS GRADE OF CONC.


M20- 47Ø
M25-41Ø
M30-38Ø

- 11) REFER RELEVANT DRG. WITH THIS DRG.
- 12) AVOID CORE CUTING.

DRG NO: DP0001 DRG CL 01 104	SHEET NO: 8 OF 9	REV. R0	SCALE: NTS	SWATI Architecture landscape interior ARCHITECTS PLANERS ENGINEERING INTERIOR DESIGN 282 , tulip , A block , Talpuri International colony , Bhilai , C.G. Email - swati.arch@outlook.com	
DESIGNED: UPENDRA SINGH	DRAWN: SIMRAN SONI	CHECKED: UPENDRA SINGH	VERIFIED: ADMIN	APPROVED: ADMIN	CLIENT: CHHATTISGARH STATE MINOR FOREST PRODUSE
ISSUED FOR: TENDOR PURPOSE		UNIT: MILIMETER	DATE: 12.05.2022	PROJECT: INCUBATION CENTER AT DEOBHOG GARIYABAND	
This drawing is the property of HUP DESIGN and is to be used only for the purpose for which it was lent and must not be in any way detrimental to the interest of the company and is subject to return on demand				TITLE: MASALA PROCESSING UNIT TRUSS DETAIL	26

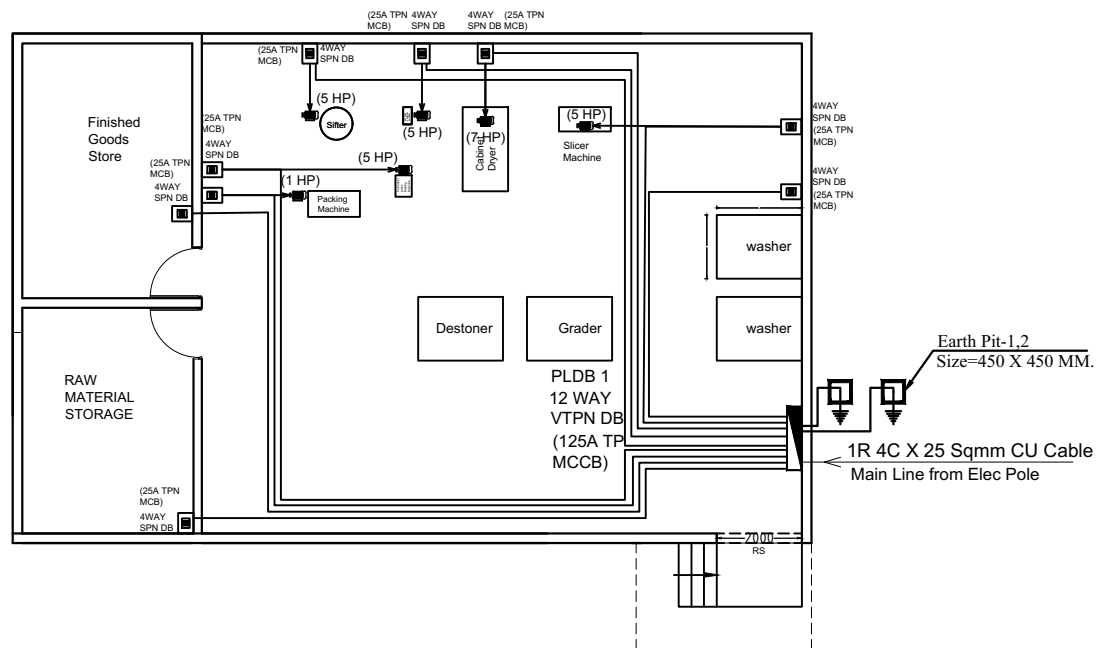


01	LED 50W	50W FLOOD LIGHT (HIGH BAY)	06 No.
02		WALL LIGHT	02 No.
03	PP-1	16A SWITCH SOCKET	08 No.
04	LP-1	6A SWITCH SOCKET	02 No.
05	4WAY SPN DB	4WAY SPN DB	09 No.
06		PLDB 1 12 WAY VTPN DB	01 No.
07		1400 mm Ceiling Fan	06 No.
08	Led 20w	20w Led Tube Light	16 No.
09	Ex Fan	450 mm Ex Fan	06 No.
10	LP-1	6A SWITCH SOCKET	07 No.
11	SB1	SWITCH BOARD	07 No.
12		6 X 6 SQMM CU WIRE	
13		3 X 1.5 SQMM CU WIRE	
14		Earth Pit-1 Size=450 X 450 MM.	2 SET

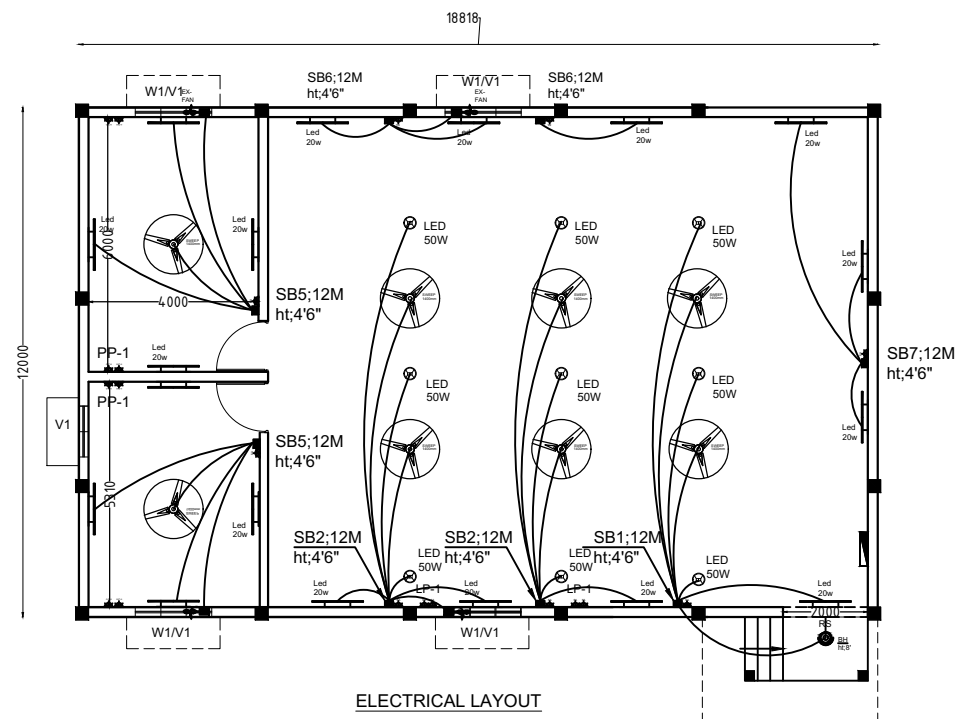

MASALA PROCESSING UNIT

MACHINE LIST			
1 - PULVERIZER , 100 KG / H , NOS 1	5 HP	6 X 6 Sqmm CU wire	
2 - PULVERIZER GRAVY MAKING MACHINE , 100KG / H , NOS 1	5 HP	6 X 6 Sqmm CU wire	
3 - SLICER MACHINE - 500 KG / HR , NOS 1	5 HP	6 X 6 Sqmm CU wire	
4 - CABINET DRYER , 250 KG / BATCH , NOS - 1 (5 KW)	7 HP	6 X 6 Sqmm CU wire	
4A - CABINET DRYER , 250 KG / BATCH , NOS - 2 (5 KW)	7 HP	6 X 6 Sqmm CU wire	
5 - SEIVING MACHINE , 100 KG / HR , NOS 1	2 HP	6 X 6 Sqmm CU wire	
6 - PACKAGING MACHINE , NOS -1	1 HP	6 X 6 Sqmm CU wire	
6A - PACKAGING MACHINE , NOS - 2	1 HP	6 X 6 Sqmm CU wire	
TOTAL LOAD	3P MCCB 125A (25 KW) (64 AMP)	33 HP	1R 4C 25 Sqmm Ar. CU Cable

DRG NO:		SHEET NO:	REV.	SCALE:	SWATI Architecture landscape interior ARCHITECTS PLANERS ENGINEERING INTERIOR DESIGN 282 , tulip , A block , Talpuri International colony , Bhilai , C.G. Email - swati.arch@outlook.com
DP0001 DRG CL 01 104		9 OF 9	R0	NTS	
DESIGNED:	DRAWN:	CHECKED:	VERIFIED:	APPROVED:	CLIENT:
UPENDRA SINGH	SIMRAN SONI	UPENDRA SINGH	ADMIN	ADMIN	CHHATTISGARH STATE MINOR FOREST PRODUCE
ISSUED FOR:			UNIT:	DATE:	PROJECT:
TENDOR PURPOSE			MILIMETER	12.05.2022	MINI FOOD PARK GARIYABAND
This drawing is the property of HUP DESIGN and is to be used only for the purpose for which it was lent and must not be in any way detrimental to the interest of the company and is subject to return on demand					TITLE:
					MASALA PROCESSING UNIT ELECTRICAL LAYOUT 27

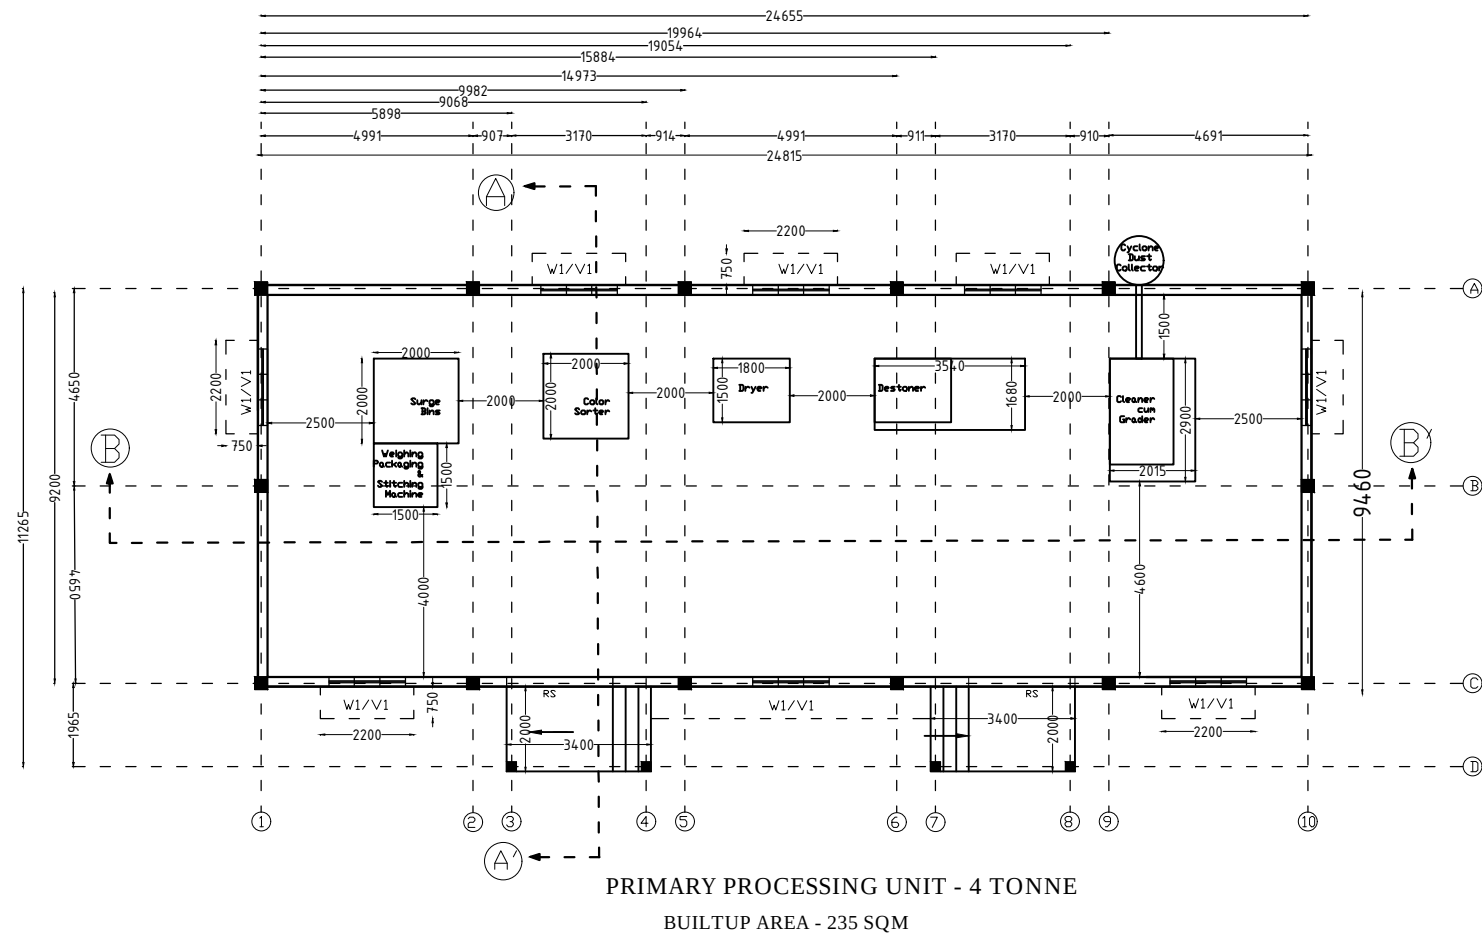


- LIST OF DRAWING**
PULSE MILLING UNIT
DP0001 DRG CL 01 106
- 1 - PLAN LAYOUT
 - 2 - SECTION / ELEVATION
 - 3 - COLUMN LAYOUT
 - 4 - FOOTING LAYOUT
 - 5 - GROUND BEAM LAYOUT
 - 6 - BEAM LAYOUT (2.5 M ABOVE)
 - 7 - BEAM LAYOUT (4.5 M ABOVE)
 - 8 - TRUSS DETAIL
 - 9 - ELECTRICAL LAYOUT

OPENING SCHEDULE


NAME	SAYMBOL
WINDOW	- W1
VENTILATOR	- V1
ROLLING SHUTTER	- R1
DOOR	- D1

SN	SAYMBOL	NOS	SIZE
01	W1	08	1.8M X 1.5M
02	V1	08	1.8 M X 1 M
03	R1	02	2.5M X 2.4 M


DRG NO: DP0001 DRG CL 01 101	SHEET NO: 1 OF 9	REV. R0	SCALE: NTS	SWATI Architecture landscape interior ARCHITECTS PLANERS ENGINEERING INTERIOR DESIGN 282 , tulip , A block , Talpuri International colony , Bhilai , C.G. Email - swati.arch@outlook.com
DESIGNED: UPENDRA SINGH	DRAWN: SIMRAN SONI	CHECKED: UPENDRA SINGH	VERIFIED: ADMIN	APPROVED: ADMIN
ISSUED FOR: TENDOR PURPOSE	UNIT: MILIMETER	DATE: 12.05.2022	PROJECT: INCUBATION CENTER AT DEOBHOG GARIYABAND	TITLE: PRIMARY PROCESSING UNIT PLAN LAYOUT
This drawing is the property of HUP DESIGN and is to be used only for the purpose for which it was lent and must not be in any way detrimental to the interest of the company and is subject to return on demand				28

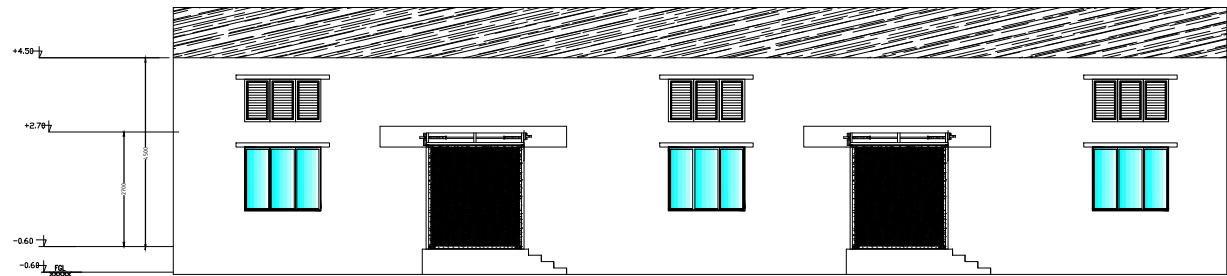


FRONT ELEVATION

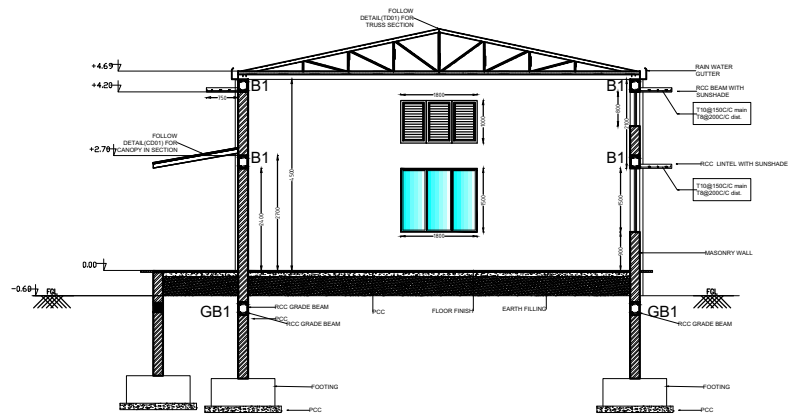

SECTION A-A' IN STRUCTURE

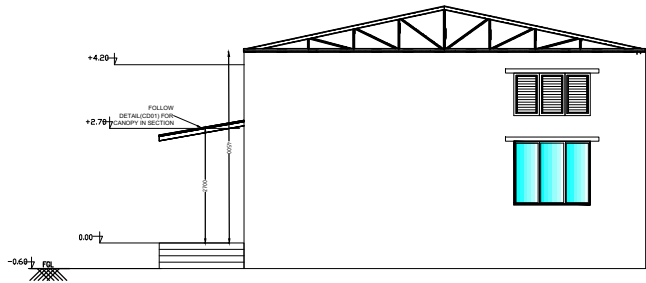

SIDE ELEVATION

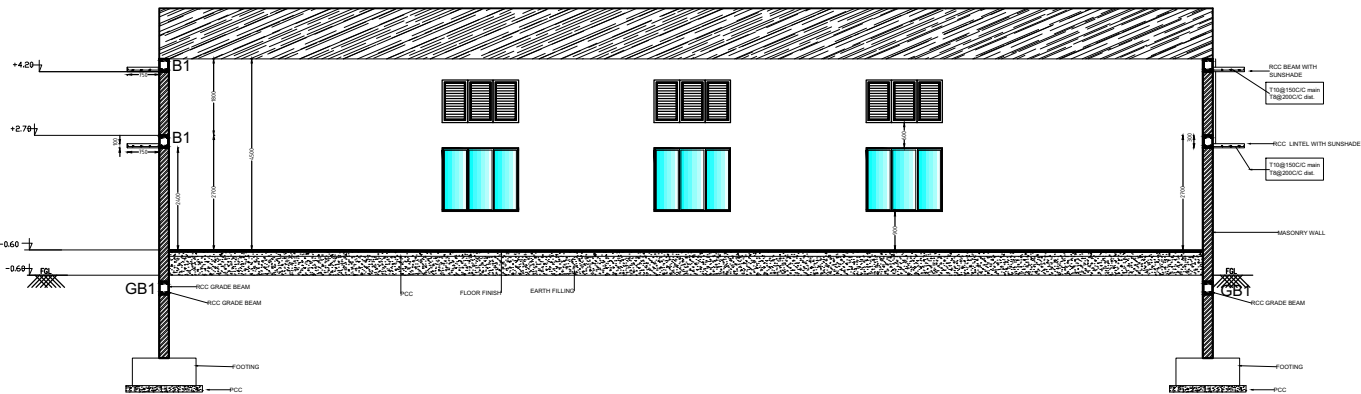


SECTION B-B' IN STRUCTURE

DRG NO:		SHEET NO:	REV.	SCALE:	SWATI Architecture landscape interior ARCHITECTS PLANERS ENGINEERING INTERIOR DESIGN 282 , tulip , A block , Talpuri International colony , Bhilai , C.G. Email - swati.arch@outlook.com		
DP0001 DRG CL 01 101		2 OF 9	R0	NTS			
DESIGNED:	DRAWN:	CHECKED:	VERIFIED:	APPROVED:	CLIENT:	CHHATTISGARH STATE MINOR FOREST PRODUSE	
UPENDRA SINGH	SIMRAN SONI	UPENDRA SINGH	ADMIN	ADMIN			
ISSUED FOR:			UNIT:	DATE:	PROJECT:	INCUBATION CENTER AT DEOBHOG GARIYABAND	
TENDOR PURPOSE			MILIMETER	12.05.2022			
This drawing is the property of HUP DESIGN and is to be used only for the purpose for which it was lent and must not be in any way detrimental to the interest of the company and is subject to return on demand					TITLE:	PRIMARY PROCESSING UNIT SECTION / ELEVATION	29


NOTES-

 1. USE - M 20 GRADE OF CONC. AS/IS 426-5000
2. USE - FE 500 GRADE OF REINF. BY CLIENT
3. PROVIDE CLEAR COVER TO MAIN REINF.
- FOUNDATION- 50MM
- COLUMN - 40MM
- BEAM - 25MM
- SLAB - 20MM OR DIA OF BAR, WHICHEVER IS MORE,
- R.C.C. WALL - 25MM
- 4.TIES SHOULD BE BEND INSIDE WITH 10# LENGTH IN BEAM & COLUMN




- 5.FOLLOW - IS-456-2000 FOR R.C.C. WORK
- 6.STRIPPING TIME FOR SHUTTERING / FORMWORK UNDER NORMAL CONDITION.

TYPE OF WORK	MINIMUM PERIOD BEFORE STRIKING FORM WORK
a) VERTICAL FORMWORK TO COLUMN, WALLS, BEAM	16-24 HOUR
b) SOFFITS FORMWORK TO SLABS (PROPS TO BE REFIXED- IMMEDIATELY AFTER REMOVAL OF FORMWORK)	3 DAYS
c) SOFFIT FORMWORK TO BEAMS (PROPS TO BE REFIXED IMMEDIATELY AFTER REMOVAL OF FORMWORK)	7DAYS
d) PROPS TO SLABS:	
1) SPANNING UP TO 4.5M	7DAYS
2) SPANNING OVER 4.5M	14 DAYS
e) PROPS TO BEAMS & ARCHES:	
1) SPANNING UP TO 6M	14DAYS
2) SPANNING OVER 6M	21DAYS
7. CURING FOR R.C.C. MEMBER MINIMUM 14 DAYS CONTINUOUSLY PREFERABLE - 28 DAYS.	
8. START EARLY CURING TO AVOID SRINKAGE CRACKS, WHEN CONCRETE APPEARS TO HARDEN.	
9) PROVIDE FOLLOWING SLUMP IN CONCRETE GENERALLY.	
a) SHALLOW SECTIONS, PAYMENTS, MASS CONC. LGTH REINFORCEMENT SECTION IN SLAB, BEAM, WALL, COLUMN	25-75
b) HEAVILY REINFORCEMENT SECTION IN SLAB	50-100
c) HEAVILY REINFORCEMENT SECTION IN BEAMS, WALLS, COLUMNS SLIPFORM, OR PUMPED CONC.	75-100
d) TRENCH FILL, PILLING, PUMPED CONC.	100-150
10) PROVIDE LAP/ DEVELOPEMENT LENGTH IN REINFORCEMENT BARS GRADE OF CONC.	M20- 47Ø M25-41Ø M30-38Ø
11) REFER RELEVANT DRG. WITH THIS DRG.	
12) AVOID CORE CUTING.	

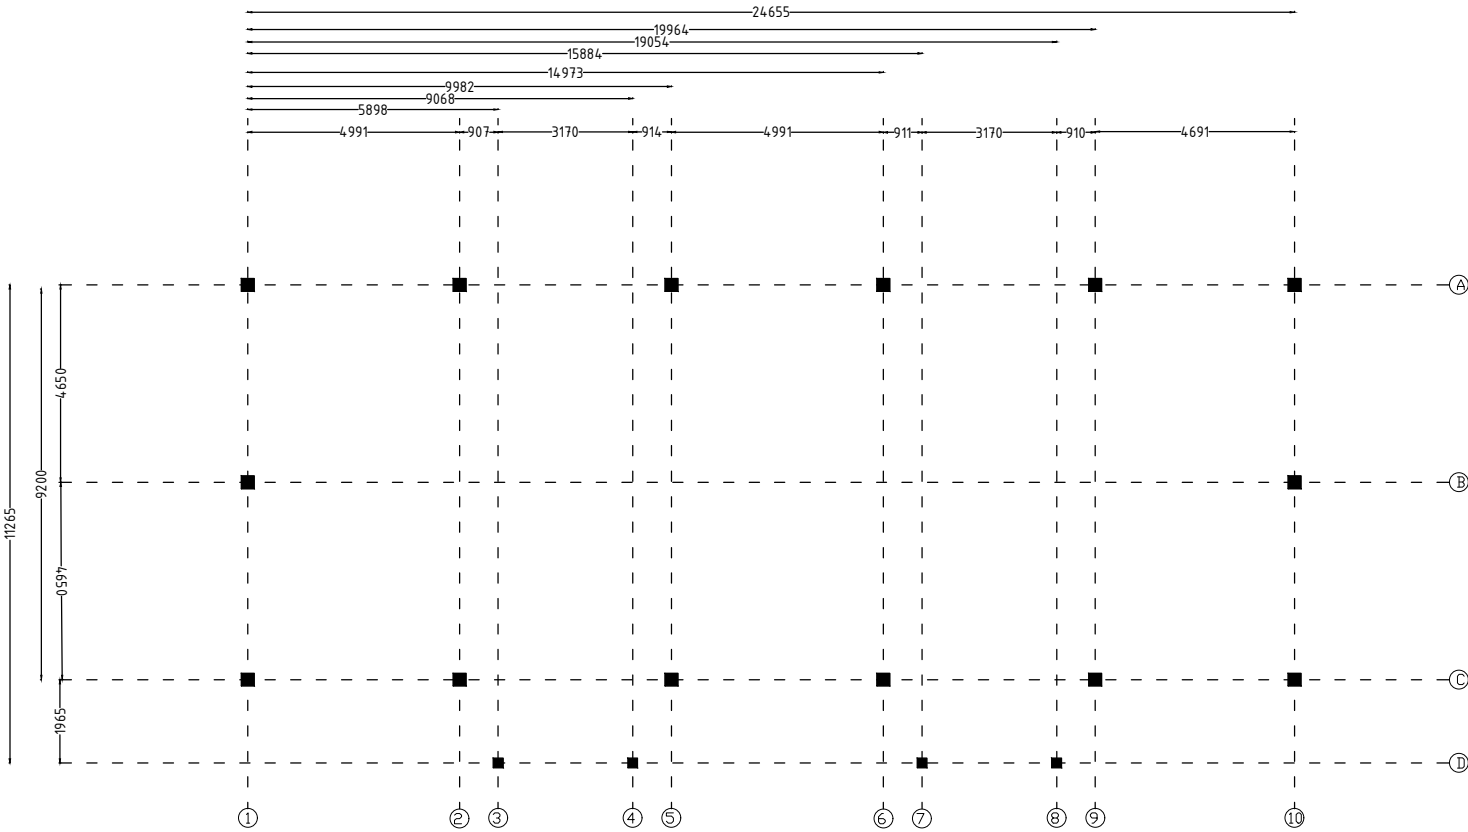

COLUMN LAYOUT

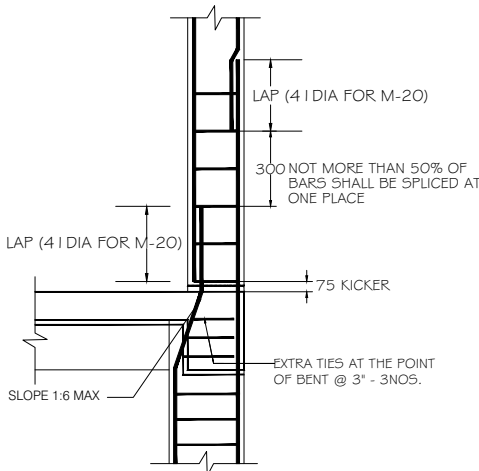

COLUMN DETAIL


TYPICAL COLUMN DETAIL'S

COLUMN NAME	Pile/col detail	STIRRUPS	REMARKS
C1	8-T12 TB@ 200 c/c 2-Tie		FOUNDATION TO TERRACE
C1	4-T12 TB@ 200 c/c 1-Tie		TERMINATE AT GROUND LVL

DRG NO:		SHEET NO:		REV.		SCALE:		SWATI Architecture landscape interior ARCHITECTS PLANERS ENGINEERING INTERIOR DESIGN 282 , tulip , A block , Talpuri International colony , Bhilai , C.G. Email - swati.arch@outlook.com				
DP0001 DRG CL 01 101		3 OF 9		R0		NTS						
DESIGNED:		DRAWN:		CHECKED:		VERIFIED:		APPROVED:		CLIENT:	CHHATTISGARH STATE MINOR FOREST PRODUSE	
UPENDRA SINGH SIMRAN SONI		UPENDRA SINGH		ADMIN		ADMIN						
ISSUED FOR:		TENDOR PURPOSE		UNIT:		DATE:		PROJECT:		INCUBATION CENTER AT DEOBHOG GARIYABAND		
				MILIMETER		12.05.2022						
This drawing is the property of HUP DESIGN and is to be used only for the purpose for which it was lent and must not be in any way detrimental to the interest of the company and is subject to return on demand								TITLE:		PRIMARY PROCESSING UNIT		30
										COLUMN LAYOUT		

NOTES-

 1. USE - M 20 GRADE OF CONC. AS/IS 426-5000
 2. USE - FE 500 GRADE OF REINF. BY CLIENT
 3. PROVIDE CLEAR COVER TO MAIN REINF.
- FOUNDATION - 50MM
COLUMN - 40MM
BEAM - 25MM
SLAB - 20MM OR DIA OF BAR, WHICHEVER IS MORE,
R.C.C. WALL - 25MM
4. TIES SHOULD BE BEND INSIDE WITH 10# LENGTH IN BEAM & COLUMN



5. FOLLOW - IS-456-2000 FOR R.C.C. WORK
6. STRIPPING TIME FOR SHUTTERING / FORMWORK UNDER NORMAL CONDITION.

TYPE OF WORK	MINIMUM PERIOD BEFORE STRIKING FORM WORK
--------------	--

- | | |
|--|------------|
| a) VERTICAL FORMWORK TO COLUMN, WALLS, BEAM | 16-24 HOUR |
| b) SOFFITS FORMWORK TO SLABS (PROPS TO BE REFIXED- IMMEDIATELY AFTER REMOVAL OF FORMWORK) | 3 DAYS |
| c) SOFFIT FORMWORK TO BEAMS (PROPS TO BE REFIXED IMMEDIATELY AFTER REMOVAL OF FORMWORK) | 7DAYS |
| d) PROPS TO SLABS: | |
| 1) SPANNING UP TO 4.5M | 7DAYS |
| 2) SPANNING OVER 4.5M | 14 DAYS |
| e) PROPS TO BEAMS & ARCHES: | |
| 1) SPANNING UP TO 6M | 14DAYS |
| 2) SPANNING OVER 6M | 21DAYS |

7. CURING FOR R.C.C. MEMBER MINIMUM 14 DAYS CONTINUOUSLY PREFERABLE - 28 DAYS.
8. START EARLY CURING TO AVOID SHRINKAGE CRACKS, WHEN CONCRETE APPEARS TO HARDEN.
- 9) PROVIDE FOLLOWING SLUMP IN CONCRETE GENERALLY.

- | | |
|---|---------|
| a) SHALLOW SECTIONS, PAYMENTS, MASS CONC. LIGHT REINFORCEMENT SECTION IN SLAB, BEAM, WALL, COLUMN | 25-75 |
| b) HEAVILY REINFORCEMENT SECTION IN SLAB | 50-100 |
| c) HEAVILY REINFORCEMENT SECTION IN BEAMS, WALLS, COLUMNS SLIPFORM, OR PUMPED CONC. | 75-100 |
| d) TRENCH FILL, PILLING, PUMPED CONC. | 100-150 |


- 10) PROVIDE LAP/ DEVELOPEMENT LENGTH IN REINFORCEMENT BARS GRADE OF CONC.

M20- 47Ø


M25-41Ø

M30-38Ø

- 11) REFER RELEVANT DRG. WITH THIS DRG.
- 12) AVOID CORE CUTTING.

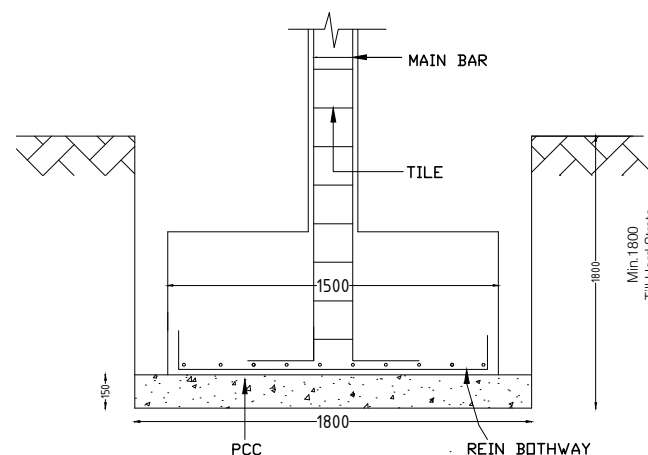

TYPICAL FOOTING SECTION (1-1')

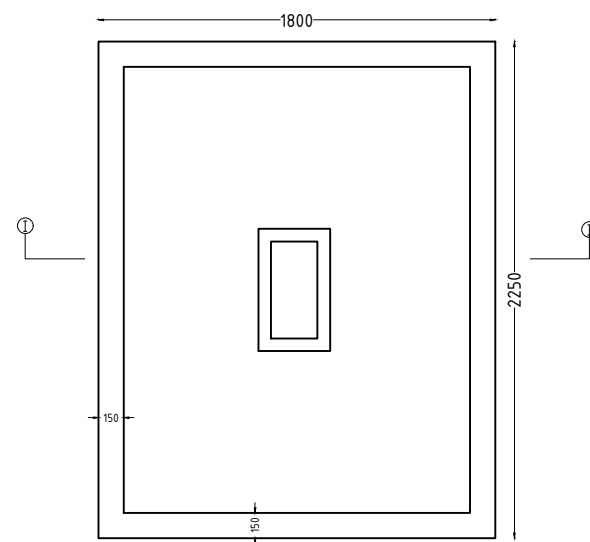

TYPICAL FOOTING PLAN

FOOTING LAYOUT

FOOTING SCHEDULE

FE500 AND M20

Footings	Column	PCC Size	Footings Size	Total	Steel	Steel	Remarks
	Nos	X - Y mm	X - Y mm	Depth mm	to X mm	to Y mm	
F1	C1	1650 X 1650	1350 X 1350	400	T10@ 175C/C	T10@ 175 C/C	Bottom bars only
F2	C2	1200 X 1200	900 X 900	230	T8@200C/C	T8@ 200 C/C	Bottom bars only

DRG NO:

DP0001 DRG CL 01 101

SHEET NO:

4 OF 9

REV.

R0

SCALE:

NTS

DESIGNED:

UPENDRA SINGH

DRAWN:

SIMRAN SONI

CHECKED:

UPENDRA SINGH

VERIFIED:

ADMIN

APPROVED:

ADMIN

ISSUED FOR:

TENDOR PURPOSE

UNIT:

MILIMETER

DATE:

12.05.2022

CLIENT:

SWATI Architecture landscape interior

ARCHITECTS | PLANERS | ENGINEERING | INTERIOR DESIGN

282 , tulip , A block , Talpuri International colony , Bhilai , C.G. Email - swati.arch@outlook.com

CHHATTISGARH STATE MINOR FOREST PRODUCE

PROJECT:

INCUBATION CENTER AT DEOBHOG GARIYABAND


TITLE:

PRIMARY PROCESSING UNIT
FOOTING LAYOUT

This drawing is the property of HUP DESIGN and is to be used only for the purpose for which it was lent and must not be in any way detrimental to the interest of the company and is subject to return on demand

NOTES-

 1. USE - M 20 GRADE OF CONC. AS/IS 426-5000
2. USE - FE 500 GRADE OF REINF. BY CLIENT
3. PROVIDE CLEAR COVER TO MAIN REINF.
- FOUNDATION- 50MM
- COLUMN - 40MM
- BEAM - 25MM
- SLAB - 20MM OR DIA OF BAR, WHICHEVER IS MORE,
- R.C.C. WALL - 25MM
- 4.TIES SHOULD BE BEND INSIDE WITH 10# LENGTH IN BEAM & COLUMN



- 5.FOLLOW - IS-456-2000 FOR R.C.C. WORK
- 6.STRIPPING TIME FOR SHUTTERING / FORMWORK UNDER NORMAL CONDITION.

TYPE OF WORK	MINIMUM PERIOD BEFORE STRIKING FORM WORK
--------------	--

a) VERTICAL FORMWORK TO COLUMN, WALLS, BEAM 16-24 HOUR

b) SOFFITS FORMWORK TO SLABS (PROPS TO BE REFIXED- IMMEDIATELY AFTER REMOVAL OF FORMWORK) 3 DAYS

c) SOFFIT FORMWORK TO BEAMS (PROPS TO BE REFIXED IMMEDIATELY AFTER REMOVAL OF FORMWORK) 7DAYS

d) PROPS TO SLABS:
1) SPANNING UP TO 4.5M 7DAYS
2) SPANNING OVER 4.5M 14 DAYS

e) PROPS TO BEAMS & ARCHES:
1) SPANNING UP TO 6M 14DAYS
2) SPANNING OVER 6M 21DAYS

7. CURING FOR R.C.C. MEMBER MINIMUM 14 DAYS CONTINUOUSLY PREFERABLE - 28 DAYS.

8. START EARLY CURING TO AVOID SRINKAGE CRACKS, WHEN CONCRETE APPEARS TO HARDEN.

9) PROVIDE FOLLOWING SLUMP IN CONCRETE GENERALLY.

a) SHALLOW SECTIONS, PAYMENTS, MASS CONC. LIGTH REINFORCEMENT SECTION IN SLAB, BEAM, WALL, COLUMN 25-75

b) HEAVILY REINFORCEMENT SECTION IN SLAB 50-100

c) HEAVILY REINFORCEMENT SECTION IN BEAMS, WALLS, COLUMNS SLIPFORM, OR PUMPED CONC. 75-100

d) TRENCH FILL, PILLING, PUMPED CONC. 100-150

10) PROVIDE LAP/ DEVELOPEMENT LENGTH IN REINFORCEMENT BARS GRADE OF CONC.


M20- 47Ø

M25-41Ø


M30-38Ø

11) REFER RELEVANT DRG. WITH THIS DRG.

12) AVOID CORE CUTING.

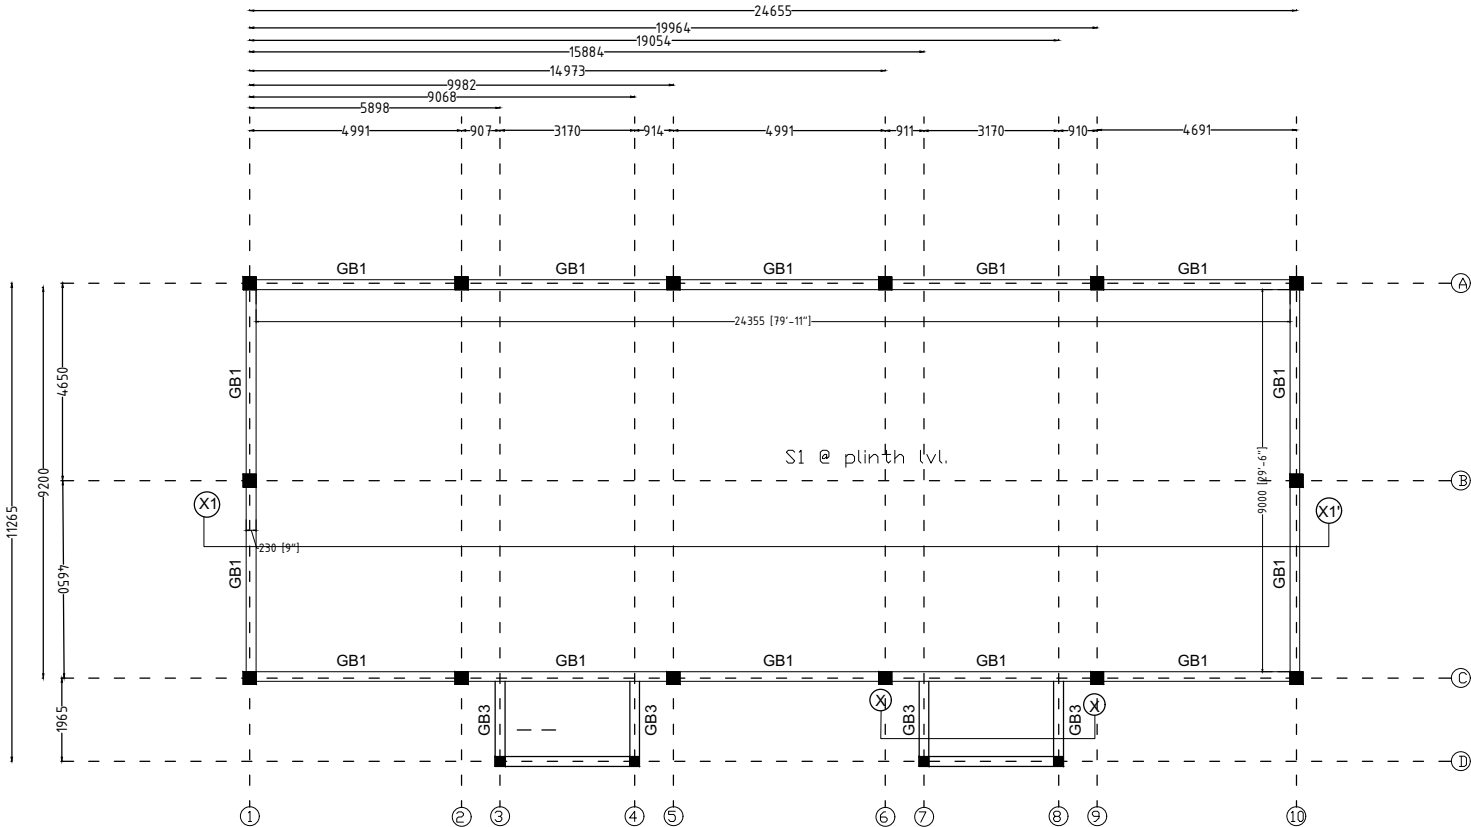

GROUND BEAM PLAN

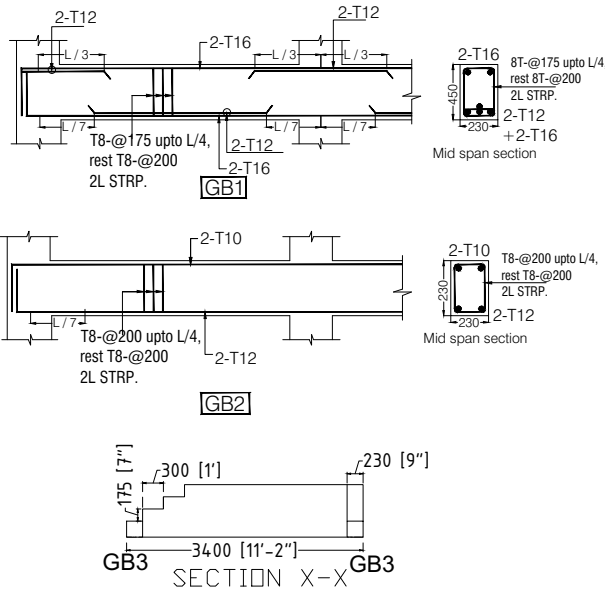

GROUND BEAM SECTIONAL DETAIL

BEAM SCHEDULE FOR GROUND/ PLINTH LVL.

Beam No.	Beam Size	Top Bar	Bottom Bar	Stirrups	Notes
GB1	230X375	2-T16	2-T12	2-T16	T8 @200C/C
GB2	230X230	2-T12	-	2-T10	-

SLAB SCHEDULE FOR GROUND FLOOR LVL.

SLAB NAME	THICKNESS (mm)	Main Steel	Other Steel	remarks
S1	150 (MESH)	T8 @ 200 c/c	T8 @ 200 c/c	All straight

DRG NO:	SHEET NO:	REV.	SCALE:
DP0001 DRG CL 01 101	5 OF 9	R0	NTS
DESIGNED:	DRAWN:	CHECKED:	VERIFIED:
UPENDRA SINGH	SIMRAN SONI	UPENDRA SINGH	ADMIN
ISSUED FOR:	UNIT:	DATE:	
TENDOR PURPOSE	MILIMETER	12.05.2022	

This drawing is the property of HUP DESIGN and is to be used only for the purpose for which it was lent and must not be in any way detrimental to the interest of the company and is subject to return on demand

SWATI Architecture landscape interior
ARCHITECTS | PLANERS | ENGINEERING | INTERIOR DESIGN
282 , tulip , A block , Talpuri International colony , Bhilai , C.G. Email - swati.arch@outlook.com

 
CHHATTISGARH STATE MINOR FOREST PRODUSE

INCUBATION CENTER AT DEOBHOG GARIYABAND

PRIMARY PROCESSING UNIT
BEAM LAYOUT


NOTES-

1. USE - M 20 GRADE OF CONC. AS/IS 426-5000
2. USE - FE 500 GRADE OF REINF. BY CLIENT
3. PROVIDE CLEAR COVER TO MAIN REINF.
- FOUNDATION- 50MM
- COLUMN - 40MM
- BEAM - 25MM
- SLAB - 20MM OR DIA OF BAR, WHICHEVER IS MORE,
- R.C.C. WALL - 25MM
- 4.TIES SHOULD BE BEND INSIDE WITH 10# LENGTH IN BEAM & COLUMN



- 5.FOLLOW - IS-456-2000 FOR R.C.C. WORK
- 6.STRIPPING TIME FOR SHUTTERING / FORMWORK UNDER NORMAL CONDITION.



TYPE OF WORK	MINIMUM PERIOD BEFORE STRIKING FORM WORK
a) VERTICAL FORMWORK TO COLUMN, WALLS, BEAM	16-24 HOUR
b) SOFFITS FORMWORK TO SLABS (PROPS TO BE REFIXED- - IMMEDIATELY AFTER REMOVAL OF FORMWORK)	3 DAYS
c) SOFFIT FORMWORK TO BEAMS (PROPS TO BE REFIXED IMMEDIATELY AFTER REMOVAL OF FORMWORK)	7DAYS
d) PROPS TO SLABS:	
1) SPANNING UP TO 4.5M	7DAYS
2) SPANNING OVER 4.5M	14 DAYS
e) PROPS TO BEAMS & ARCHES:	
1) SPANNING UP TO 6M	14DAYS
2) SPANNING OVER 6M	21DAYS
7. CURING FOR R.C.C. MEMBER MINIMUM 14 DAYS CONTINOUSELY PREFERABLE - 28 DAYS.	
8. START EARLY CURING TO AVOID SRINKAGE CRACKS, WHEN CONCRETE APPEARS TO HARDEN.	
9) PROVIDE FOLLOWING SLUMP IN CONCRETE GEN- -ERALLY.	
a) SHALLOW SECTIONS, PAYMENTS, MASS CONC. LIGTH REINFORCEMENT SECTION IN SLAB, BEAM, WALL, COLUMN	25-75
b) HEAVILY REINFORCEMENT SECTION IN SLAB	50-100
c) HEAVILY REINFORCEMENT SECTION IN BEAMS, WALLS, COLUMNS SLIPFORM, OR PUMPED CONC.	75-100
d) TRENCH FILL, PILLING, PUMPED CONC.	100-150
10) PROVIDE LAP/ DEVELOPEMENT LENGTH IN REINFORCEMENT BARS GRADE OF CONC.	
	M20- 47Ø
	M25-41Ø
	M30-38Ø
11) REFER RELEVANT DRG. WITH THIS DRG.	
12) AVOID CORE CUTING.	

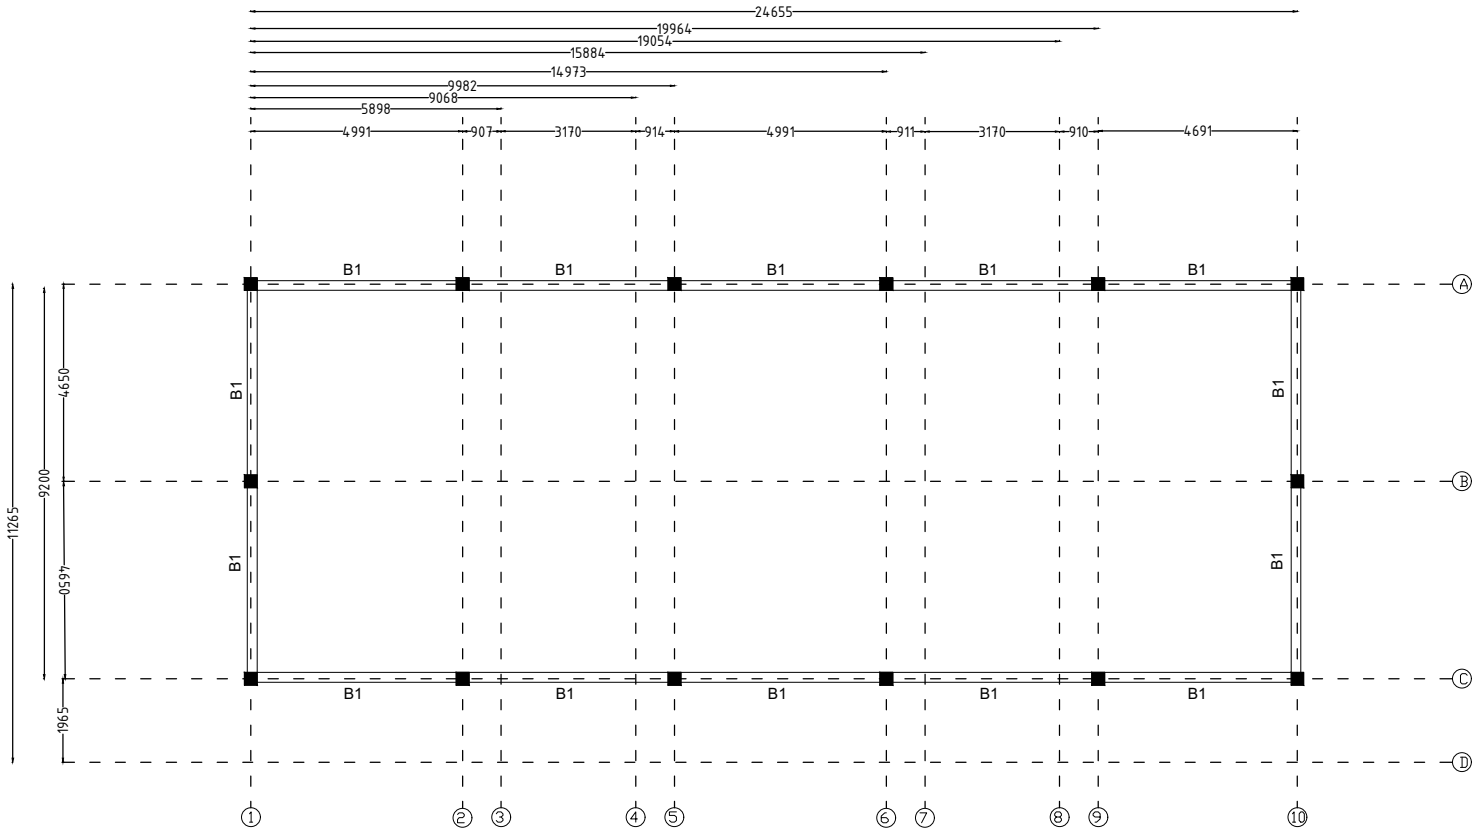

BEAM PLAN (2.4 M ABOVE BEAM)

BEAM SCHEDULE FOR 2.4m LVL. ABOVE PLINTH

Beam	Size	Reinforcement					Stirrups			Slab Thk.
		Top	Bottom	Top	Bottom	Top	Bottom	Top	Bottom	
B1	230X300	2-T12	2-T12	2-T12	2-T12	2-T12	T8 @200C/C	T8 @175C/C	T8 @175C/C	SLAB THK. INCLUDED

 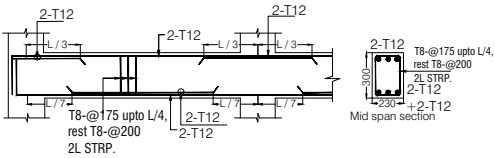

Mid span section


DRG NO:	SHEET NO:	REV.	SCALE:
DP0001 DRG CL 01 101	6 OF 9	R0	NTS
DESIGNED:	DRAWN:	CHECKED:	VERIFIED:
UPENDRA SINGH	SIMRAN SONI	UPENDRA SINGH	ADMIN
ISSUED FOR:	UNIT:	DATE:	
TENDOR PURPOSE	MILIMETER	12.05.2022	

This drawing is the property of HUP DESIGN and is to be used only for the purpose for which it was lent and must not be in any way detrimental to the interest of the company and is subject to return on demand

SWATI Architecture landscape interior ARCHITECTS PLANERS ENGINEERING INTERIOR DESIGN 282 , tulip , A block , Talpuri International colony , Bhilai , C.G. Email - swati.arch@outlook.com	
CHHATTISGARH STATE MINOR FOREST PRODUSE	
INCUBATION CENTER AT DEOBHOG GARIYABAND	
TITLE:	
PRIMARY PROCESSING UNIT BEAM LAYOUT	


NOTES-

 1. USE - M 20 GRADE OF CONC. AS/IS 426-5000
2. USE - FE 500 GRADE OF REINF. BY CLIENT
3. PROVIDE CLEAR COVER TO MAIN REINF.
- FOUNDATION- 50MM
- COLUMN - 40MM
- BEAM - 25MM
- SLAB - 20MM OR DIA OF BAR, WHICHEVER IS MORE,
- R.C.C. WALL - 25MM
- 4.TIES SHOULD BE BEND INSIDE WITH 10# LENGTH IN BEAM & COLUMN




- 5.FOLLOW - IS-456-2000 FOR R.C.C. WORK
- 6.STRIPPING TIME FOR SHUTTERING / FORMWORK UNDER NORMAL CONDITION.

TYPE OF WORK	MINIMUM PERIOD BEFORE STRIKING FORM WORK
a) VERTICAL FORMWORK TO COLUMN, WALLS, BEAM	16-24 HOUR
b) SOFFITS FORMWORK TO SLABS (PROPS TO BE REFIXED- IMMEDIATELY AFTER REMOVAL OF FORMWORK)	3 DAYS
c) SOFFIT FORMWORK TO BEAMS (PROPS TO BE REFIXED IMMEDIATELY AFTER REMOVAL OF FORMWORK)	7DAYS
d) PROPS TO SLABS:	
1) SPANNING UP TO 4.5M	7DAYS
2) SPANNING OVER 4.5M	14 DAYS
e) PROPS TO BEAMS & ARCHES:	
1) SPANNING UP TO 6M	14DAYS
2) SPANNING OVER 6M	21DAYS
7. CURING FOR R.C.C. MEMBER MINIMUM 14 DAYS CONTINUOUSLY PREFERABLE - 28 DAYS.	
8. START EARLY CURING TO AVOID SRINKAGE CRACKS, WHEN CONCRETE APPEARS TO HARDEN.	
9) PROVIDE FOLLOWING SLUMP IN CONCRETE GENERALLY.	
a) SHALLOW SECTIONS, PAYMENTS, MASS CONC. LIGTH REINFORCEMENT SECTION IN SLAB, BEAM, WALL, COLUMN	25-75
b) HEAVILY REINFORCEMENT SECTION IN SLAB	50-100
c) HEAVILY REINFORCEMENT SECTION IN BEAMS, WALLS, COLUMNS SLIPFORM, OR PUMPED CONC.	75-100
d) TRENCH FILL, PILLING, PUMPED CONC.	100-150
10) PROVIDE LAP/ DEVELOPEMENT LENGTH IN REINFORCEMENT BARS GRADE OF CONC.	M20- 47Ø M25-41Ø M30-38Ø
11) REFER RELEVANT DRG. WITH THIS DRG.	
12) AVOID CORE CUTING.	

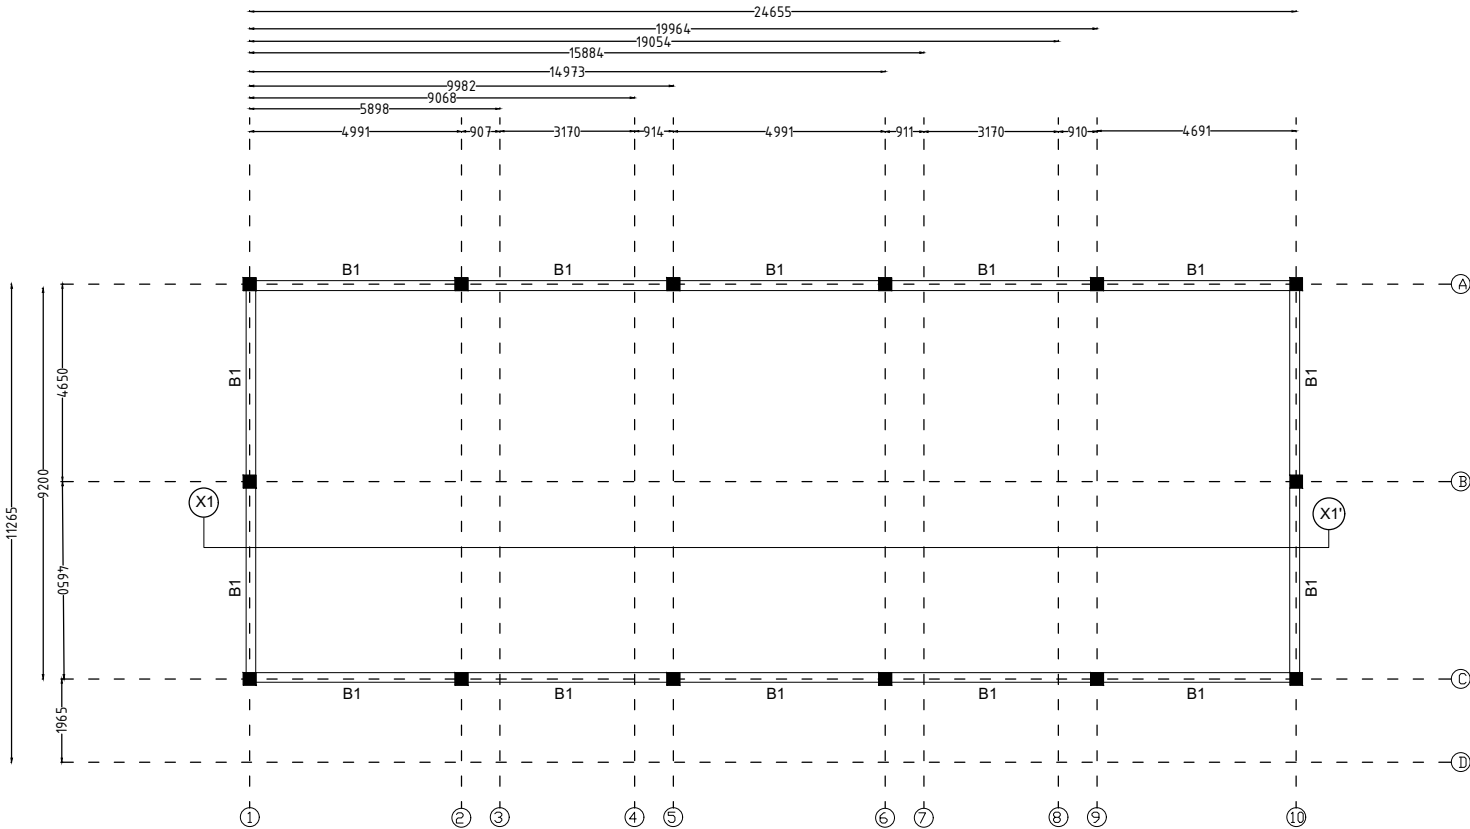

BEAM PLAN (4.5 M ABOVE BEAM)

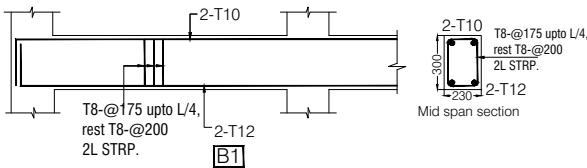

BEAM SCHEDULE FOR 4.5m LVL. ABOVE PLINTH

Beam ID	Size	Top Bar	Bottom Bar	Stirrups	Other	Notes
B1	230X300	2-T12	-	2-T10	-	T8 @200C/C, T8 @175C/C, T8 @175C/C, SLAB THK. INCLUDED

DRG NO:
DP0001 DRG CL 01 101

SHEET NO:
7 OF 9

REV.
R0

SCALE:
NTS

DESIGNED:
UPENDRA SINGH

DRAWN:
SIMRAN SONI

CHECKED:
UPENDRA SINGH

VERIFIED:
ADMIN

APPROVED:
ADMIN

ISSUED FOR:
TENDOR PURPOSE

UNIT:
MILIMETER

DATE:
12.05.2022

This drawing is the property of HUP DESIGN and is to be used only for the purpose for which it was lent and must not be in any way detrimental to the interest of the company and is subject to return on demand

SWATI Architecture landscape interior

ARCHITECTS | PLANERS | ENGINEERING | INTERIOR DESIGN

282 , tulip , A block , Talpuri International colony , Bhilai , C.G. Email - swati.arch@outlook.com

CLIENT:

CHHATTISGARH STATE MINOR FOREST PRODUSE

PROJECT:

INCUBATION CENTER AT DEOBHOG GARIYABAND

 
TITLE:

PRIMARY PROCESSING UNIT
BEAM LAYOUT

34

NOTES-

1. USE - M 20 GRADE OF CONC. AS/IS 426-5000
 2. USE - FE 500 GRADE OF REINF. BY CLIENT
 3. PROVIDE CLEAR COVER TO MAIN REINF.
- FOUNDATION- 50MM
COLUMN - 40MM
BEAM - 25MM
SLAB - 20MM OR DIA OF BAR, WHICHEVER IS MORE,
R.C.C. WALL - 25MM
4. TIES SHOULD BE BEND INSIDE WITH 10# LENGTH IN BEAM & COLUMN



5. FOLLOW - IS-456-2000 FOR R.C.C. WORK
6. STRIPPING TIME FOR SHUTTERING / FORMWORK UNDER NORMAL CONDITION.

TYPE OF WORK	MINIMUM PERIOD BEFORE STRIKING FORM WORK
--------------	--

- | | |
|--|------------|
| a) VERTICAL FORMWORK TO COLUMN, WALLS, BEAM | 16-24 HOUR |
| b) SOFFITS FORMWORK TO SLABS (PROPS TO BE REFIXED- IMMEDIATELY AFTER REMOVAL OF FORMWORK) | 3 DAYS |
| c) SOFFIT FORMWORK TO BEAMS (PROPS TO BE REFIXED IMMEDIATELY AFTER REMOVAL OF FORMWORK) | 7DAYS |
| d) PROPS TO SLABS: | |
| 1) SPANNING UP TO 4.5M | 7DAYS |
| 2) SPANNING OVER 4.5M | 14 DAYS |
| e) PROPS TO BEAMS & ARCHES: | |
| 1) SPANNING UP TO 6M | 14DAYS |
| 2) SPANNING OVER 6M | 21DAYS |

7. CURING FOR R.C.C. MEMBER MINIMUM 14 DAYS CONTINUOUSLY PREFERABLE - 28 DAYS.
8. START EARLY CURING TO AVOID SHRINKAGE CRACKS, WHEN CONCRETE APPEARS TO HARDEN.
- 9) PROVIDE FOLLOWING SLUMP IN CONCRETE GENERALLY.


- | | |
|---|---------|
| a) SHALLOW SECTIONS, PAYMENTS, MASS CONC. LIGHT REINFORCEMENT SECTION IN SLAB, BEAM, WALL, COLUMN | 25-75 |
| b) HEAVILY REINFORCEMENT SECTION IN SLAB | 50-100 |
| c) HEAVILY REINFORCEMENT SECTION IN BEAMS, WALLS, COLUMNS SLIPFORM, OR PUMPED CONC. | 75-100 |
| d) TRENCH FILL, PILLING, PUMPED CONC. | 100-150 |
| 10) PROVIDE LAP/ DEVELOPEMENT LENGTH IN REINFORCEMENT BARS GRADE OF CONC. | |

M20- 47Ø


M25-41Ø

M30-38Ø


- 11) REFER RELEVANT DRG. WITH THIS DRG.
- 12) AVOID CORE CUTTING.

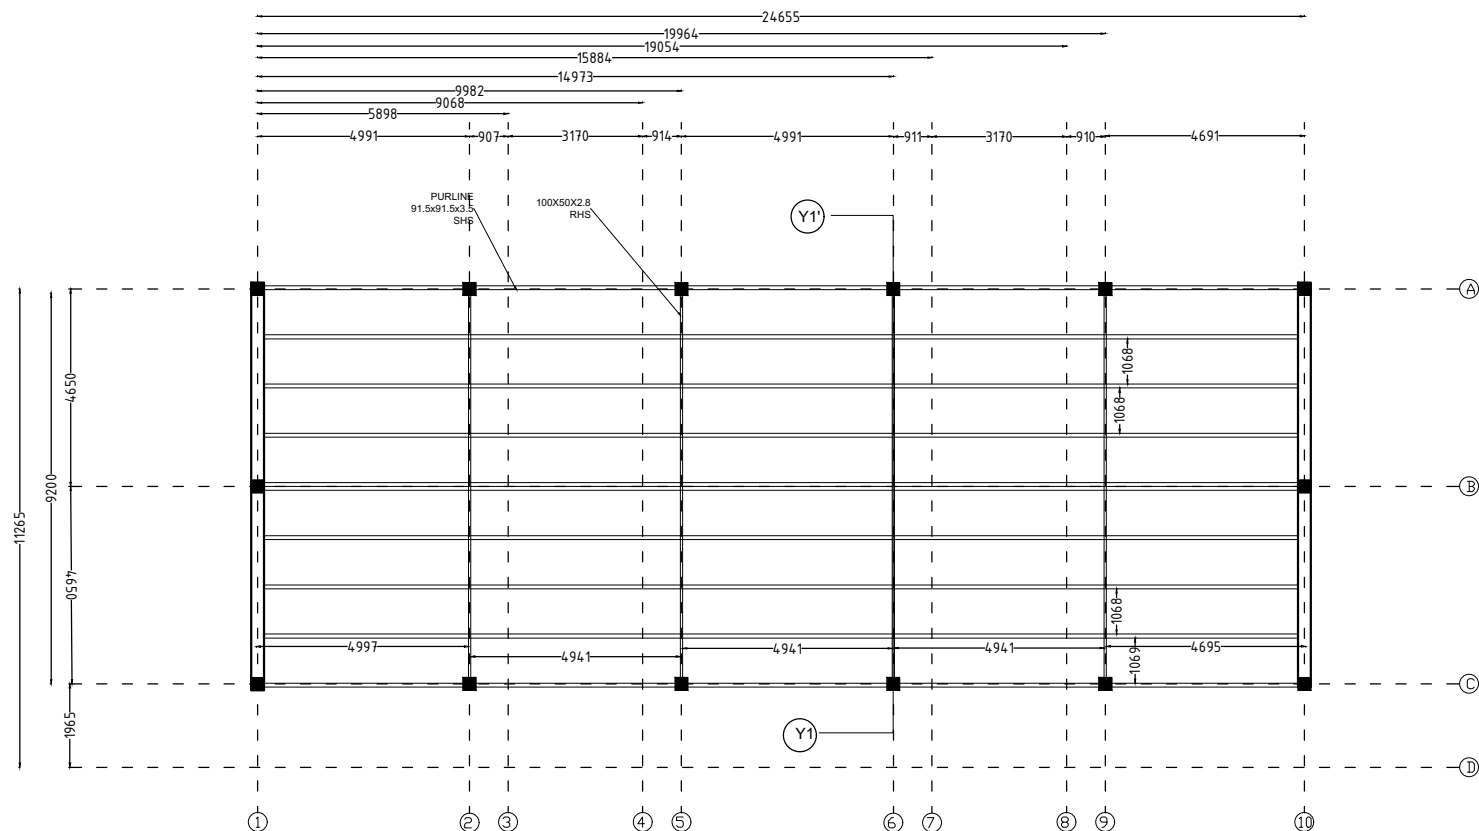


ROOF TRUSS PLAN

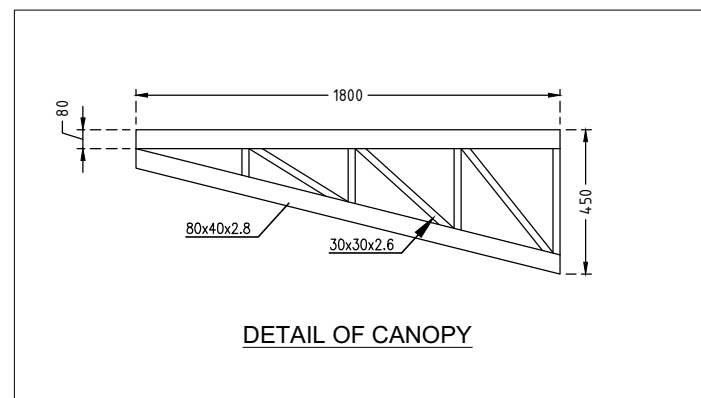

DETAIL OF CANOPY

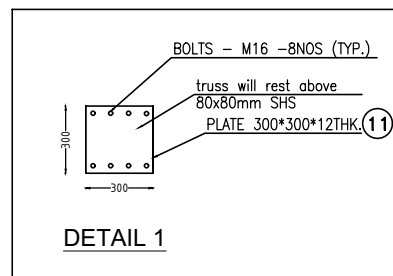

DETAIL 1

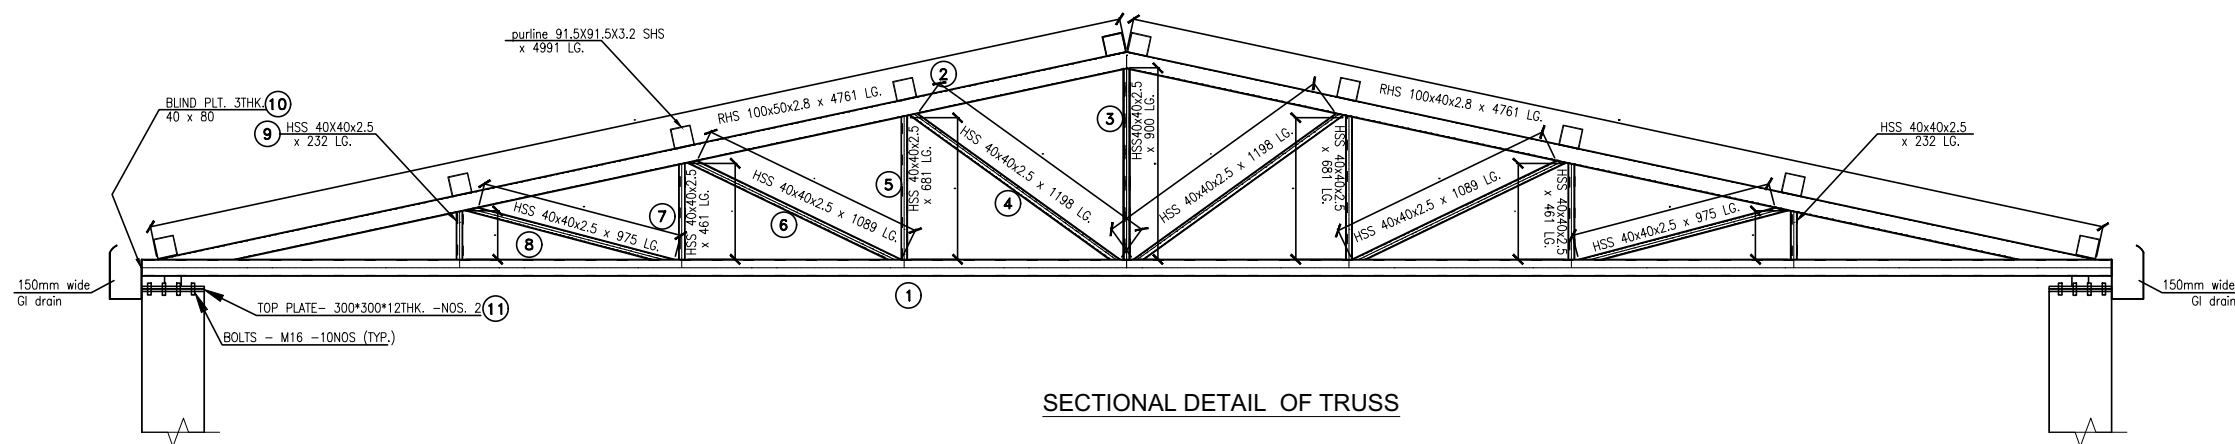

SECTIONAL DETAIL OF TRUSS

DRG NO:	SHEET NO:	REV.	SCALE:
DP0001 DRG CL 01 101	8 OF 9	R0	NTS
DESIGNED:	DRAWN:	CHECKED:	VERIFIED:
UPENDRA SINGH	SIMRAN SONI	UPENDRA SINGH	ADMIN
ISSUED FOR:	UNIT:	DATE:	
TENDOR PURPOSE	MILIMETER	12.05.2022	
This drawing is the property of HUP DESIGN and is to be used only for the purpose for which it was lent and must not be in any way detrimental to the interest of the company and is subject to return on demand			


SWATI Architecture landscape interior

ARCHITECTS | PLANERS | ENGINEERING | INTERIOR DESIGN
282 , tulip , A block , Talpuri International colony , Bhilai , C.G. Email - swati.arch@outlook.com

CHHATTISGARH STATE MINOR FOREST PRODUCE


INCUBATION CENTER AT DEOBHOG GARIYABAND

PRIMARY PROCESSING UNIT
TRUSS DETAIL

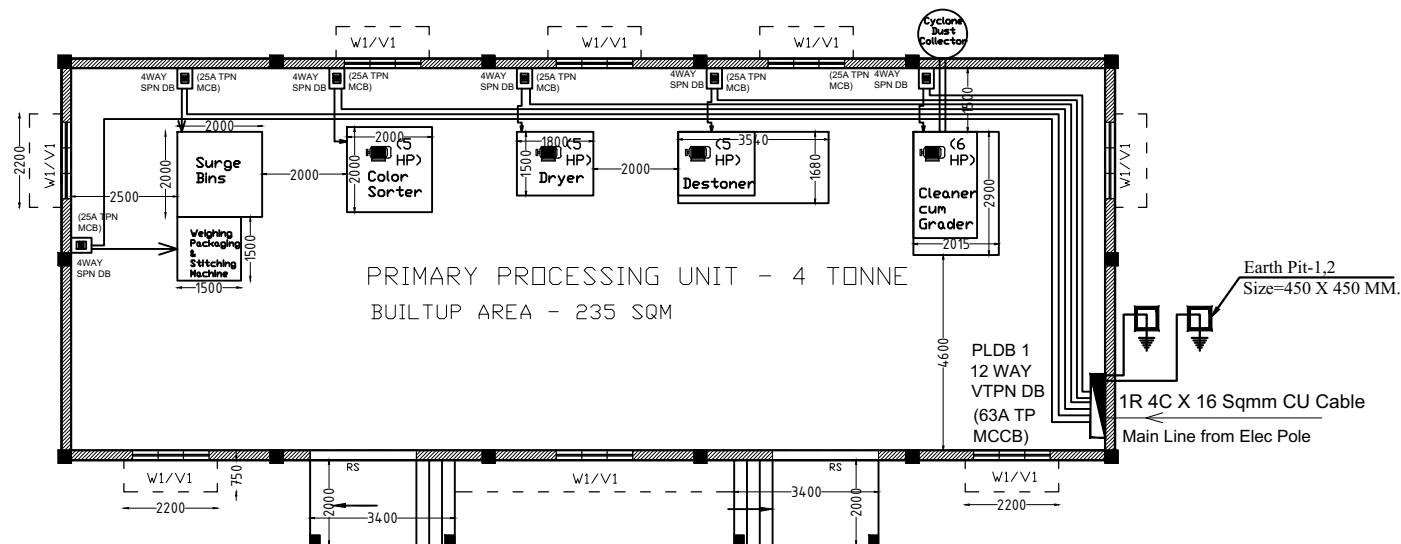

PRIMARY PROCESSING


01	LED 50W	50W FLOOD LIGHT (HIGH BAY)	12 No.
02		WALL LIGHT	02
03	PP-1	16A SWITCH SOCKET	No.
04	LP-1	6A SWITCH SOCKET	No.
05	4WAY SPN DB	4WAY SPN DB	No.
06		PLDB 1 12 WAY VTPN DB	No.
07		1400 mm Ceiling Fan	08
08	Led 20w	20w Led Tube Light	14 No.
09	Ex Fan	450 mm Ex Fan	05
10	LP-1	6A SWITCH SOCKET	No.
11	SB1	SWITCH BOARD	No.
12		6 X 6 SQMM CU WIRE	No.
13		3 X 1.5 SQMM CU WIRE	
14		Earth Pit-1 Size=450 X 450 MM.	2 SET

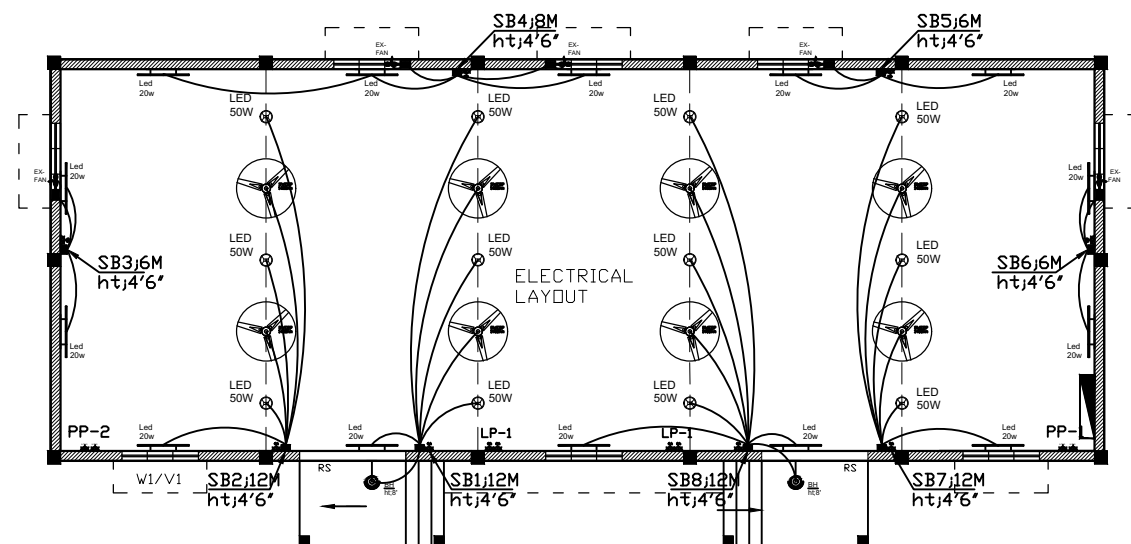

ELECTRICAL LAYOUT

MACHINE LIST			
1 - CLEANER CUM GRADER , NOS 1	6 HP	6 X 6 Sqmm CU wire	
2 - DESTONER (2 TONNER / HR) FIVE FANS	5 HP	6 X 6 Sqmm CU wire	
3 - COLOR SHORTER , NOS 1	5 HP	6 X 6 Sqmm CU wire	
4 - BAGFILLING AND PACKAGING MACHINE , 2 NOS	2 HP	6 X 6 Sqmm CU wire	
5 - ELEVATOR (NOS4) HEIGHT MAX 20 FT2, HR	2 HP	6 X 6 Sqmm CU wire	
6 - HOLDING BIN (CAPACITY 1 TON) , NOS 1	2 HP	6 X 6 Sqmm CU wire	
TOTAL LOAD	3P MCCB (17 KW) 22 HP	1R 4C 16 Sqmm Ar. CU Cable	
	100A (40 AMP)		

DRG NO:		SHEET NO:		REV.		SCALE:		SWATI Architecture landscape interior ARCHITECTS PLANERS ENGINEERING INTERIOR DESIGN 282 , tulip , A block , Talpuri International colony , Bhilai , C.G. Email - swati.arch@outlook.com				
DP0001 DRG CL 01 101		9 OF 9		R0		NTS						
DESIGNED:		DRAWN:		CHECKED:		VERIFIED:		APPROVED:		CLIENT:		
UPENDRA SINGH		SIMRAN SONI		UPENDRA SINGH		ADMIN		ADMIN		CHHATTISGARH STATE MINOR FOREST PRODUCE		
ISSUED FOR:				UNIT:		DATE:		PROJECT:		INCUBATION CENTER AT DEOBHOG GARIYABAND		
TENDOR PURPOSE				MILIMETER		12.05.2022						
This drawing is the property of HUP DESIGN and is to be used only for the purpose for which it was lent and must not be in any way detrimental to the interest of the company and is subject to return on demand								TITLE:		PRIMARY PROCESSING UNIT		36
										ELECTRICAL LAYOUT		

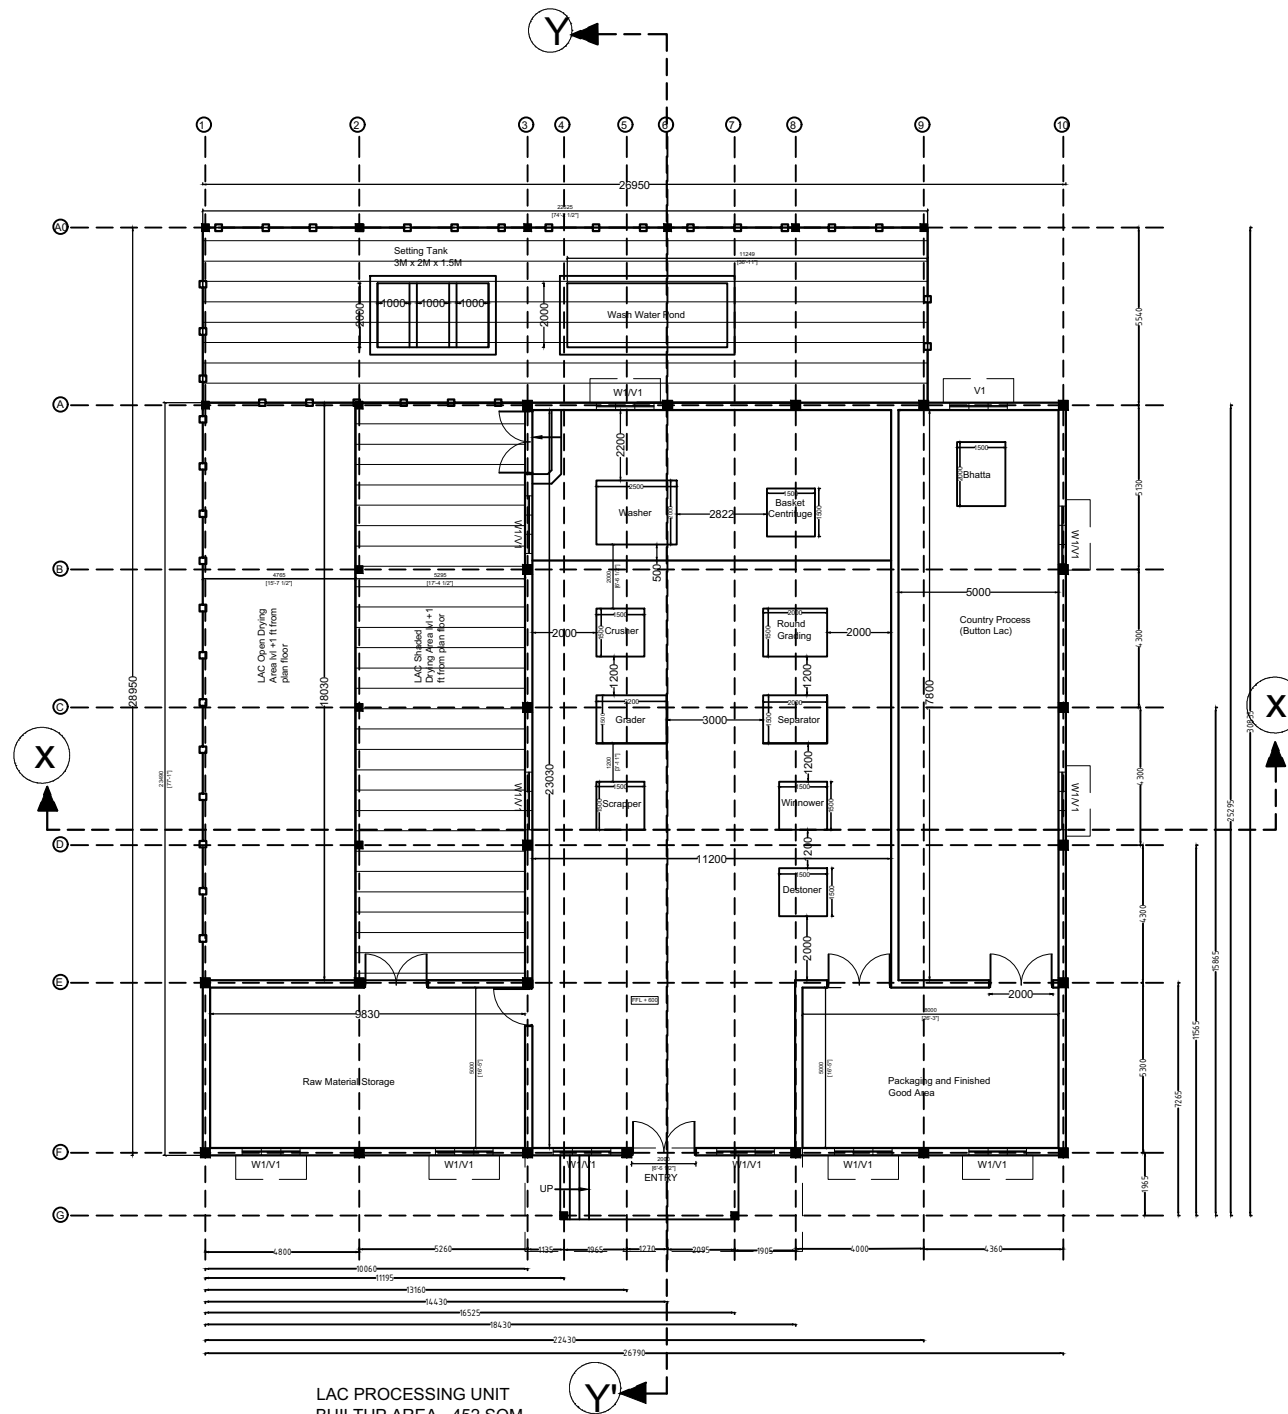


LAC PROCESSING UNIT
BUILTUP AREA - 452 SQM
OPEN DRYING AREA - 90 SQM
SHADED DRYING AREA - 90 SQM
FILTRATION TANK - 15 SQM

LIST OF DRAWING	
LAC PROCESSING UNIT	
DP0001 DRG CL 01 107	
1 - PLAN LAYOUT	
2 - SECTION / ELEVATION	
3 - COLUMN LAYOUT	
4 - FOOTING LAYOUT	
5 - GROUND BEAM LAYOUT	
6 - BEAM LAYOUT (2.5 M ABOVE)	
7 - BEAM LAYOUT (4.5 M ABOVE)	
8 - TRUSS DETAIL	
9 - ELECTRICAL LAYOUT	

OPENING SCHEDULE			
NAME		SAYMBOL	
WINDOW		- W1	
VENTILATOR		- V1	
ROLLING SHUTTER		- R1	
DOOR		- D1	

SN	SAYMBOL	NOS	SIZE
01	W1	10	1.8M X 1.5M
02	V1	10	1.8 M X 1 M
03	D1	01	1 M X 2.1M
04	D2	05	2M X 2.1 M


DRG NO: DP0001 DRG CL 01 107					SHEET NO: 1 OF 9		REV. R0		SCALE: NTS		SWATI Architecture landscape interior ARCHITECTS PLANERS ENGINEERING INTERIOR DESIGN 282 , tulip , A block , Talpuri International colony , Bhilai , C.G. Email - swati.arch@outlook.com				
DESIGNED: UPENDRA SINGH		DRAWN: SIMRAN SONI		CHECKED: UPENDRA SINGH		VERIFIED: ADMIN		APPROVED: ADMIN		CLIENT: CHHATTISGARH STATE MINOR FOREST PRODUCE					
ISSUED FOR: TENDOR PURPOSE						UNIT: MILIMETER		DATE: 12.05.2022		PROJECT: INCUBATION CENTER AT DEOBHOG GARIYABAND					
This drawing is the property of HUP DESIGN and is to be used only for the purpose for which it was lent and must not be in any way detrimental to the interest of the company and is subject to return on demand										TITLE: LAC PROCESSING UNIT BEAM LAYOUT				37	

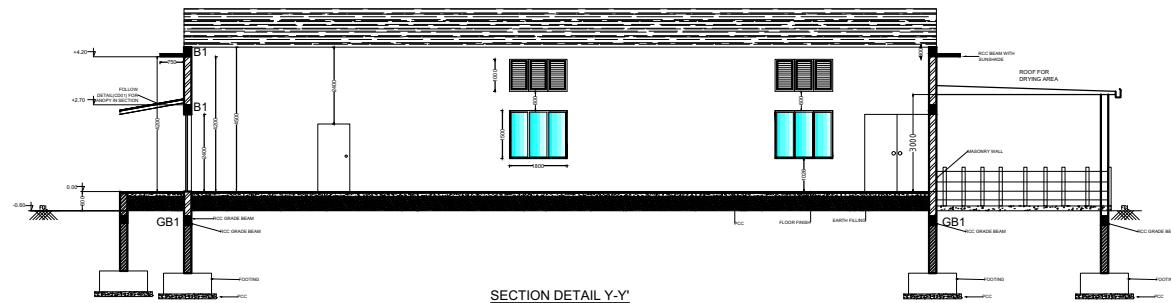


SECTION DETAIL Y-Y



FRONT ELEVATION

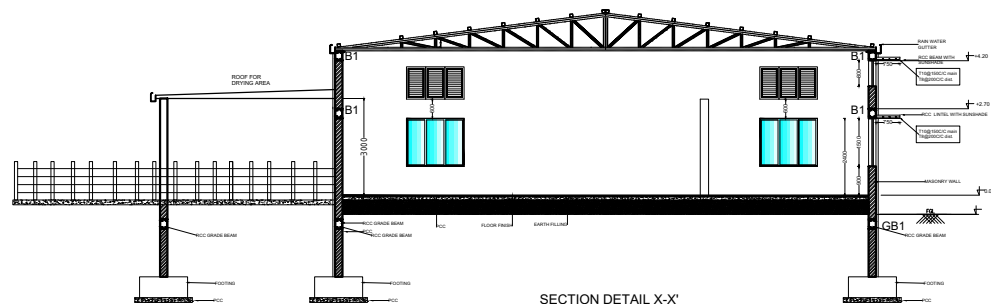


SECTION DETAIL X-X'

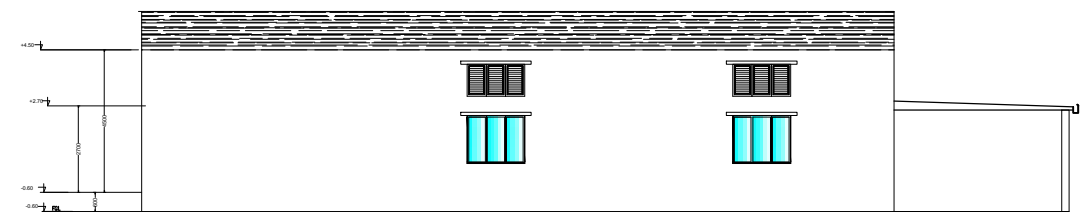


SIDE ELEVATION

DRG NO: DP0001 DRG CL 01 107	SHEET NO: 2 OF 9	REV. R0	SCALE: NTS	SWATI Architecture landscape interior ARCHITECTS PLANERS ENGINEERING INTERIOR DESIGN 282 , tulip , A block , Talpuri International colony , Bhilai , C.G. Email - swati.arch@outlook.com	
DESIGNED: UPENDRA SINGH	DRAWN: SIMRAN SONI	CHECKED: UPENDRA SINGH	VERIFIED: ADMIN	APPROVED: ADMIN	CLIENT: CHHATTISGARH STATE MINOR FOREST PRODUCE
ISSUED FOR: TENDOR PURPOSE		UNIT: MILIMETER	DATE: 12.05.2022	PROJECT: INCUBATION CENTER AT DEOBHOG GARIYABAND	
This drawing is the property of HUP DESIGN and is to be used only for the purpose for which it was lent and must not be in any way detrimental to the interest of the company and is subject to return on demand				TITLE: SECTION / ELEVATION BEAM LAYOUT	38

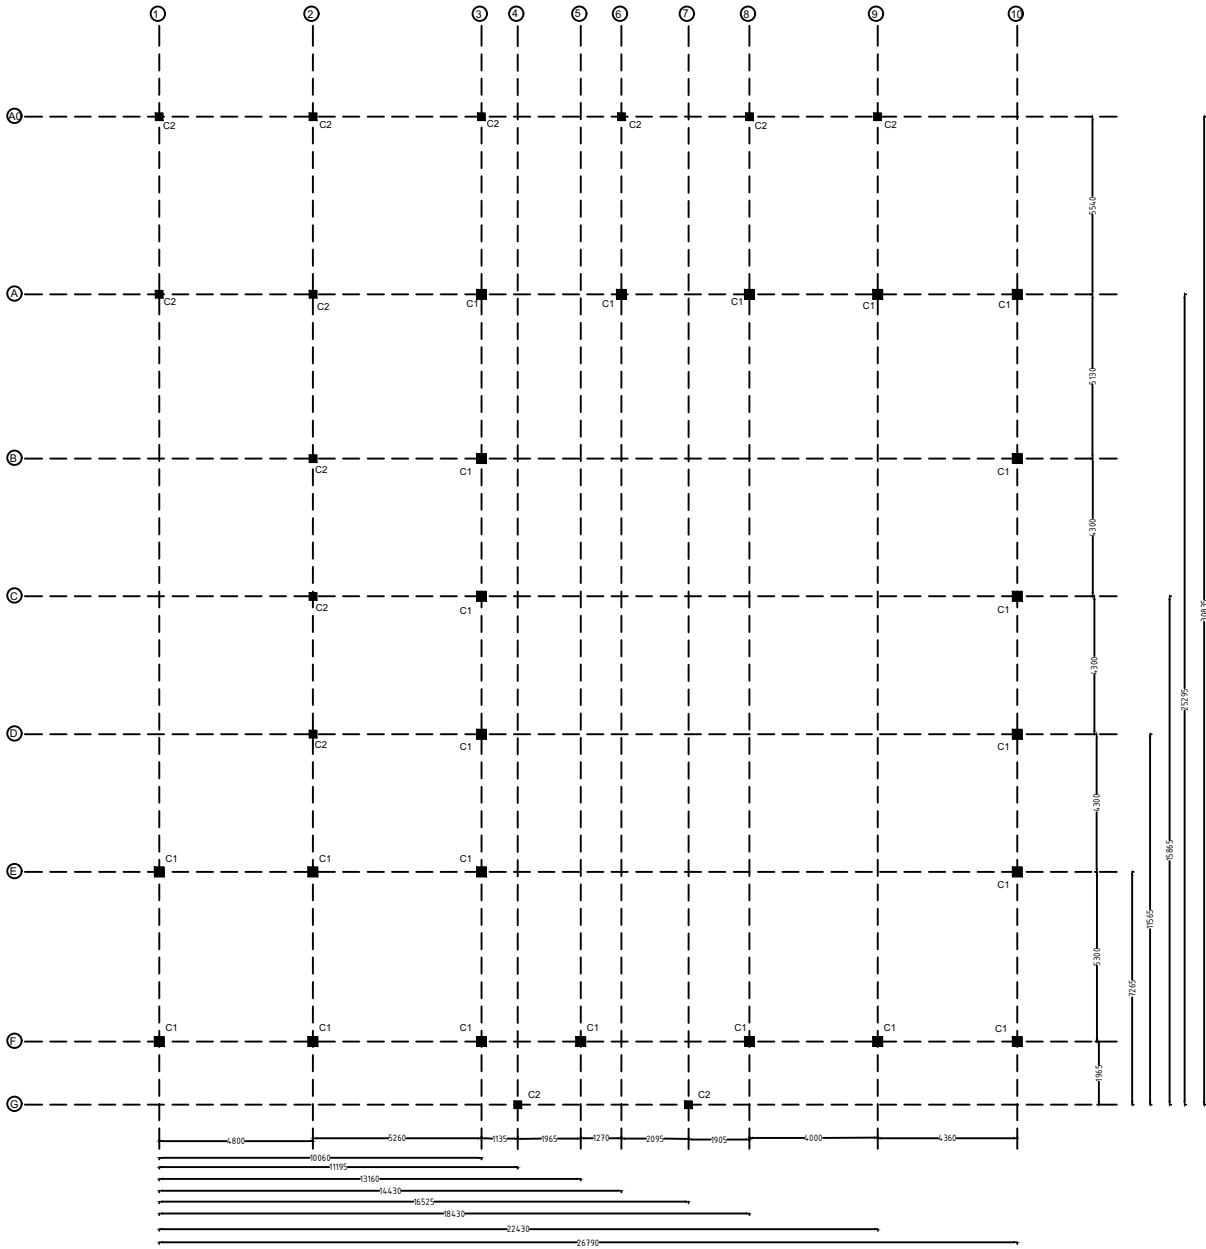

COLUMN LAYOUT

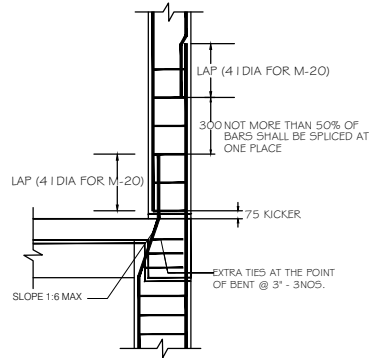

COLUMN DETAIL


TYPICAL COLUMN DETAIL'S

COLUMN NAME	Pile/col detail	STIRRUPS	REMARKS
C1	 300 300		FOUNDATION TO TERRACE
C2	 230 230		TERMINATE AT GROUND LVL

GENERAL NOTES

- NOTES-
- USE - M 20 GRADE OF CONC. AS/IS 426-5000
 - USE - FE 500 GRADE OF REINF. BY CLIENT
 - PROVIDE CLEAR COVER TO MAIN REINF.
- FOUNDATION- 50MM
COLUMN - 40MM
BEAM - 25MM
SLAB - 20MM OR DIA OF BAR, WHICHEVER IS MORE,
R.C.C. WALL - 25MM
- 4.TIES SHOULD BE BEND INSIDE WITH 10# LENGTH IN BEAM & COLUMN
- 
- 5.FOLLOW - IS-456-2000 FOR R.C.C. WORK
6.STRIPPING TIME FOR SHUTTERING / FORMWORK UNDER NORMAL CONDITION.
- | TYPE OF WORK | MINIMUM PERIOD BEFORE STRIKING FORM WORK |
|--|--|
| a) VERTICAL FORMWORK TO COLUMN, WALLS, BEAM | 16-24 HOUR |
| b) SOFFITS FORMWORK TO SLABS (PROPS TO BE REFIXED- IMMEDIATELY AFTER REMOVAL OF FORMWORK) | 3 DAYS |
| c) SOFFIT FORMWORK TO BEAMS (PROPS TO BE REFIXED IMMEDIATELY AFTER REMOVAL OF FORMWORK) | 7DAYS |
| d) PROPS TO SLABS: | |
| 1) SPANNING UP TO 4.5M | 7DAYS |
| 2) SPANNING OVER 4.5M | 14 DAYS |
| e) PROPS TO BEAMS & ARCHES: | |
| 1) SPANNING UP TO 6M | 14DAYS |
| 2) SPANNING OVER 6M | 21DAYS |
7. CURING FOR R.C.C. MEMBER MINIMUM 14 DAYS CONTINUOUSLY PREFERABLE - 28 DAYS.
8. START EARLY CURING TO AVOID SRINKAGE CRACKS, WHEN CONCRETE APPEARS TO HARDEN.
9) PROVIDE FOLLOWING SLUMP IN CONCRETE GENERALLY.
- | | |
|---|---------|
| a) SHALLOW SECTIONS, PAVMENTS, MASS CONC. LIGHT REINFORCEMENT SECTION IN SLAB, BEAM, WALL, COLUMN | 25-75 |
| b) HEAVILY REINFORCEMENT SECTION IN SLAB | 50-100 |
| c) HEAVILY REINFORCEMENT SECTION IN BEAMS, WALLS, COLUMNS SLIPFORM, OR PUMPED CONC. | 75-100 |
| d) TRENCH FILL, PILLING, PUMPED CONC. | 100-150 |
- 10) PROVIDE LAP/ DEVELOPEMENT LENGTH IN REINFORCEMENT BARS GRADE OF CONC.
- | |
|----------|
| M20- 47Ø |
| M25-41Ø |
| M30-38Ø |
- 11) REFER RELEVANT DRG. WITH THIS DRG.
12) AVOID CORE CUTING.

DRG NO: DP0001 DRG CL 01 107	SHEET NO: 3 OF 9	REV. R0	SCALE: NTS	SWATI Architecture landscape interior ARCHITECTS PLANERS ENGINEERING INTERIOR DESIGN 282 , tulip , A block , Talpuri International colony , Bhilai , C.G. Email - swati.arch@outlook.com	
DESIGNED: UPENDRA SINGH	DRAWN: SIMRAN SONI	CHECKED: UPENDRA SINGH	VERIFIED: ADMIN	APPROVED: ADMIN	CLIENT: CHHATTISGARH STATE MINOR FOREST PRODUCE
ISSUED FOR: TENDOR PURPOSE	UNIT: MILIMETER	DATE: 12.05.2022	PROJECT: INCUBATION CENTER AT DEOBHOG GARIYABAND		
This drawing is the property of HUP DESIGN and is to be used only for the purpose for which it was lent and must not be in any way detrimental to the interest of the company and is subject to return on demand				TITLE: LAC PROCESSING UNIT COLUMN LAYOUT	39

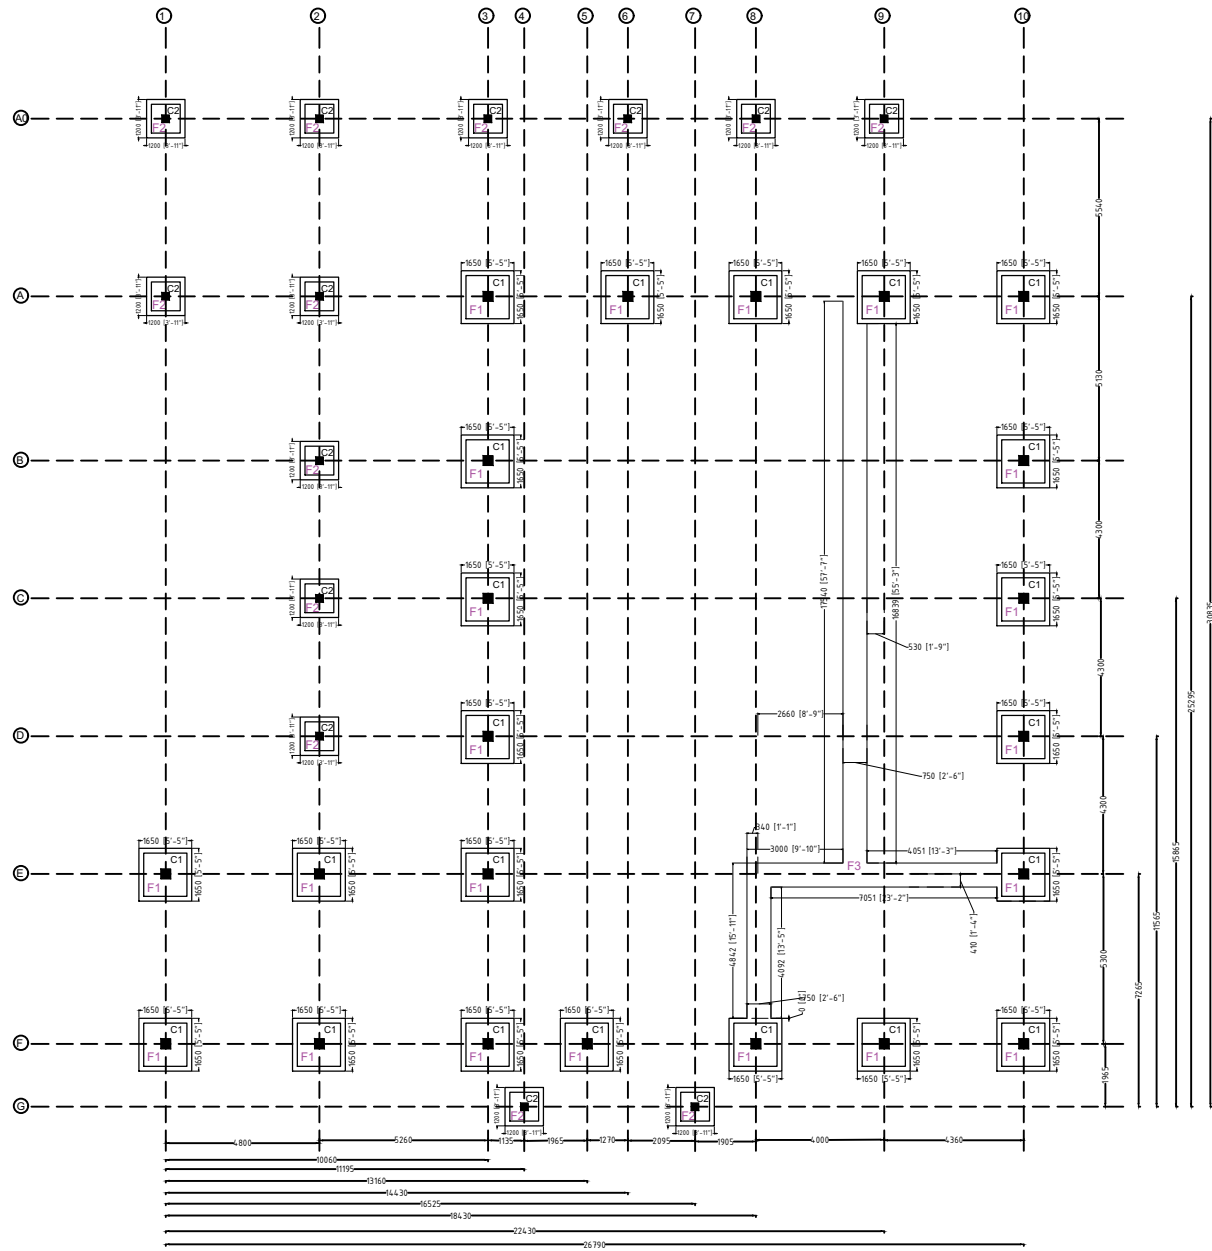


FOOTING LAYOUT


FOOTING SCHEDULE

FE500 AND M20

Footings	Column	PCC Size	Footings Size	Total	Steel	Steel	Remarks
	Nos	X - Y mm	X - Y mm	Depth mm	to X mm	to Y mm	
F1	C1	1650 X 1650	1350 X 1350	400	T10@ 175C/C	T10@ 175 C/C	Bottom bars only
F2	C2	1200 X 1200	900 X 900	230	T8@200C/C	T8@ 200 C/C	Bottom bars only

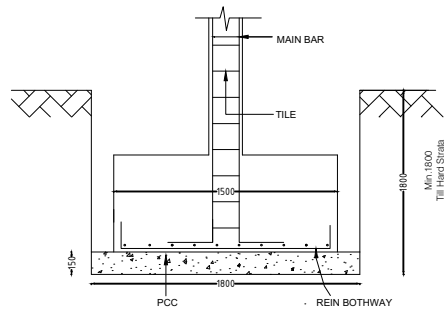

TYPICAL FOOTING SECTION (1-1')

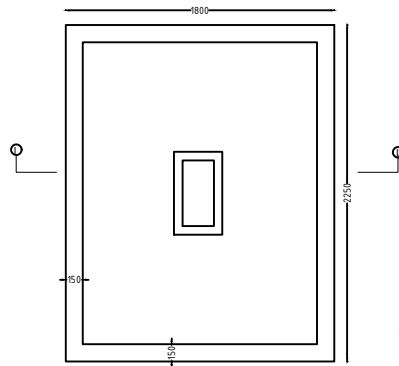


TYPICAL FOOTING PLAN

GENERAL NOTES

NOTES-

 - USE - M 20 GRADE OF CONC. AS/IS 426-5000
 - USE - FE 500 GRADE OF REINF. BY CLIENT
 - PROVIDE CLEAR COVER TO MAIN REINF.
- FOUNDATION- 50MM
COLUMN - 40MM
BEAM - 25MM
SLAB - 20MM OR DIA OF BAR, WHICHEVER IS MORE,
R.C.C. WALL - 25MM
- TIES SHOULD BE BEND INSIDE WITH 10# LENGTH IN BEAM & COLUMN



- FOLLOW - IS-456-2000 FOR R.C.C. WORK
- STRIPPING TIME FOR SHUTTERING / FORMWORK UNDER NORMAL CONDITION.

TYPE OF WORK	MINIMUM PERIOD BEFORE STRIKING FORM WORK
--------------	--

- VERTICAL FORMWORK TO COLUMN, WALLS, BEAM 16-24 HOUR
- SOFFITS FORMWORK TO SLABS (PROPS TO BE REFIXED- IMMEDIATELY AFTER REMOVAL OF FORMWORK) 3 DAYS
- SOFFIT FORMWORK TO BEAMS (PROPS TO BE REFIXED IMMEDIATELY AFTER REMOVAL OF FORMWORK) 7DAYS
- PROPS TO SLABS:
 - 1) SPANNING UP TO 4.5M 7DAYS
 - 2) SPANNING OVER 4.5M 14 DAYS
- PROPS TO BEAMS & ARCHES:
 - 1) SPANNING UP TO 6M 14DAYS
 - 2) SPANNING OVER 6M 21DAYS

- CURING FOR R.C.C. MEMBER MINIMUM 14 DAYS CONTINOUSELY PREFERABLE - 28 DAYS.
- START EARLY CURING TO AVOID SRINKAGE CRACKS, WHEN CONCRETE APPEARS TO HARDEN.
- PROVIDE FOLLOWING SLUMP IN CONCRETE GENERALLY.

- SHALLOW SECTIONS, PAVMENTS, MASS CONC. LIGTH REINFORCEMENT SECTION IN SLAB, BEAM, WALL, COLUMN 25-75
 - HEAVILY REINFORCEMENT SECTION IN SLAB 50-100
 - HEAVILY REINFORCEMENT SECTION IN BEAMS, WALLS, COLUMNS SLIPFORM, OR PUMPED CONC. 75-100
 - TRENCH FILL, PILLING, PUMPED CONC. 100-150
- PROVIDE LAP/ DEVELOPEMENT LENGTH IN REINFORCEMENT BARS GRADE OF CONC.

M20- 47Ø
M25-41Ø
M30-38Ø

- REFER RELEVANT DRG. WITH THIS DRG.
- AVOID CORE CUTING.

DRG NO:

DP0001 DRG CL 01 107

SHEET NO:

4 OF 9

REV.

R0

SCALE:

NTS

DESIGNED:

UPENDRA SINGH SIMRAN SONI

DRAWN:

UPENDRA SINGH

CHECKED:

ADMIN

VERIFIED:

ADMIN

APPROVED:

ADMIN

ISSUED FOR:

TENDOR PURPOSE

UNIT:

MILIMETER

DATE:



12.05.2022

SWATI Architecture landscape interior
ARCHITECTS | PLANERS | ENGINEERING | INTERIOR DESIGN
282 , tulip , A block , Talpuri International colony , Bhilai , C.G. Email - swati.arch@outlook.com

CLIENT:
CHHATTISGARH STATE MINOR FOREST PRODUCE

PROJECT:
INCUBATION CENTER AT DEOBHOG GARIYABAND

TITLE:
**LAC PROCESSING UNIT
FOOTING LAYOUT**

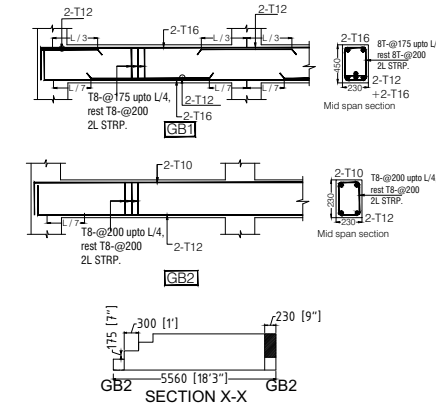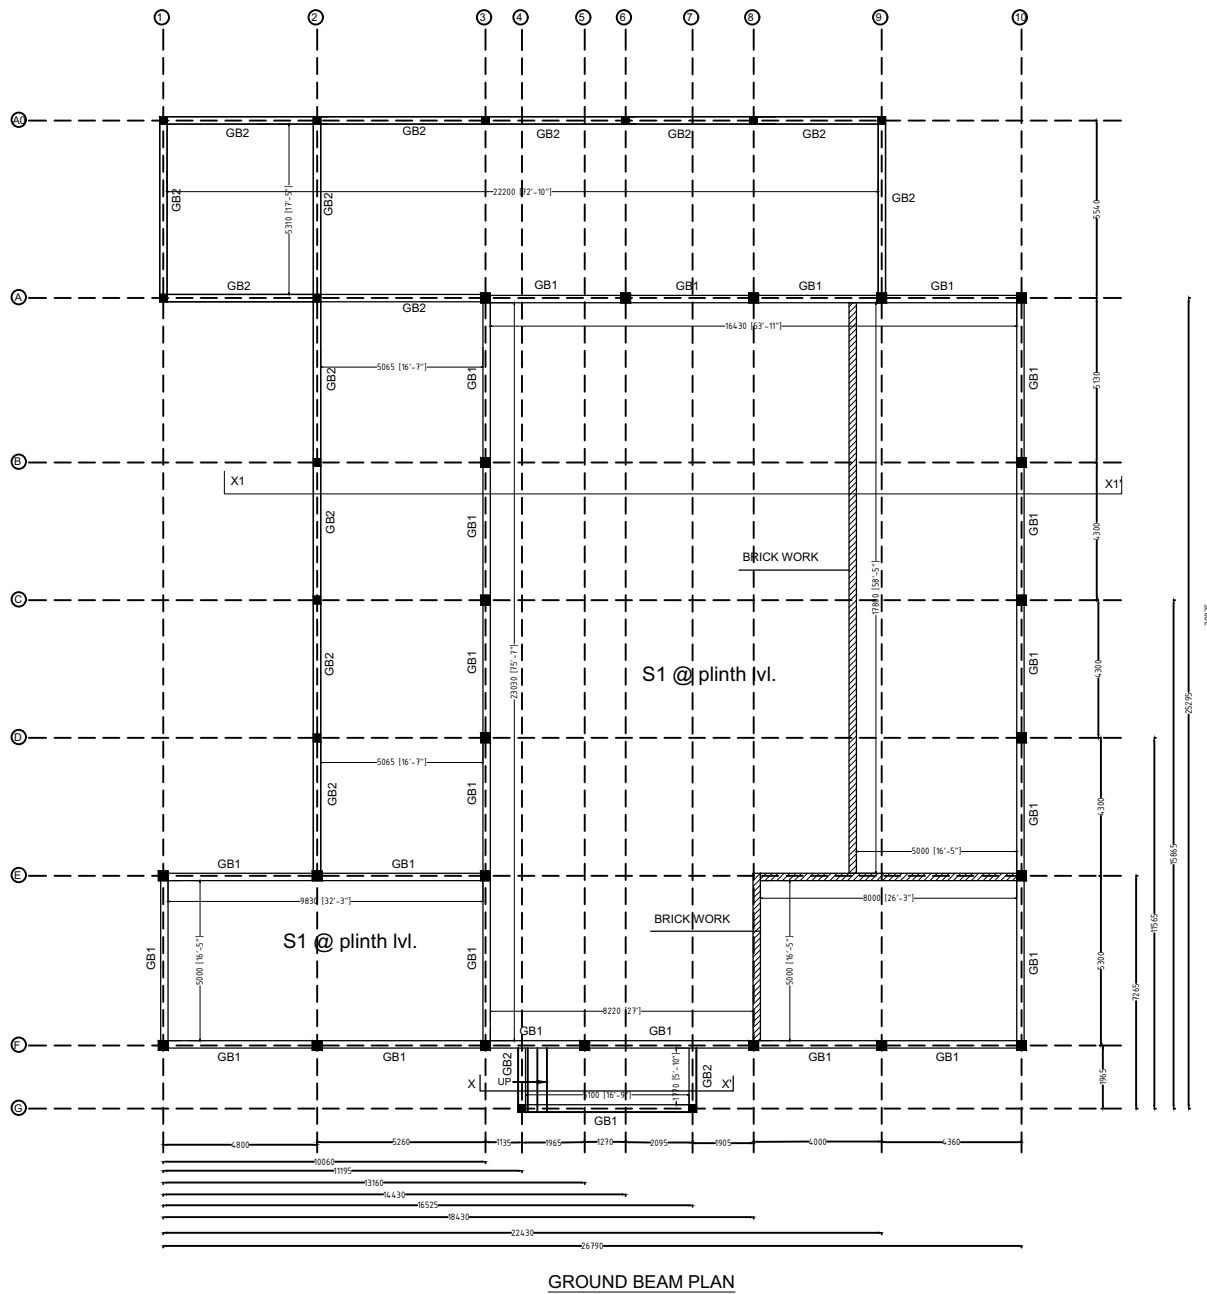

GROUND BEAM SECTIONAL DETAIL

BEAM SCHEDULE FOR GROUND/ PLINTH LVL.									
Beam	Size	Top	Bottom	Top	Bottom	Top	Bottom	Top	Bottom
GB1	230x375	2-T16	2-T12	2-T16	2-T12	2-T12	T8 @200C/C	T8 @175C/C	T8 @175C/C
GB2	230x230	2-T12	-	2-T10	-	-	T8 @200C/C	T8 @200C/C	T8 @200C/C

SLAB SCHEDULE FOR GROUND FLOOR LVL.				
SLAB NAME	THICKNESS (mm)	Main Steel	Other Steel	remarks
S1	150 (MESH)	T8 @ 200 c/c	T8 @ 200 c/c	All straight

GENERAL NOTES

- NOTES-
- USE - M 20 GRADE OF CONC. AS/IS 426-5000
 - USE - FE 500 GRADE OF REINF. BY CLIENT
 - PROVIDE CLEAR COVER TO MAIN REINF.
- FOUNDATION- 50MM
COLUMN - 40MM
BEAM - 25MM
SLAB - 20MM OR DIA OF BAR, WHICHEVER IS MORE,
R.C.C. WALL - 25MM
- 4.TIES SHOULD BE BEND INSIDE WITH 10# LENGTH IN BEAM & COLUMN
- 5.FOLLOW - IS-456-2000 FOR R.C.C. WORK
- 6.STRIPPING TIME FOR SHUTTERING / FORMWORK UNDER NORMAL CONDITION.
- TYPE OF WORK MINIMUM PERIOD BEFORE STRIKING FORM WORK
- VERTICAL FORMWORK TO COLUMN, WALLS, BEAM 16-24 HOUR
 - SOFFITS FORMWORK TO SLABS (PROPS TO BE REFIXED- IMMEDIATELY AFTER REMOVAL OF FORMWORK) 3 DAYS
 - SOFFIT FORMWORK TO BEAMS (PROPS TO BE REFIXED IMMEDIATELY AFTER REMOVAL OF FORMWORK) 7DAYS
 - PROPS TO SLABS:
 - 1) SPANNING UP TO 4.5M 7DAYS
 - 2) SPANNING OVER 4.5M 14 DAYS
 - PROPS TO BEAMS & ARCHES:
 - 1) SPANNING UP TO 6M 14DAYS
 - 2) SPANNING OVER 6M 21DAYS
7. CURING FOR R.C.C. MEMBER MINIMUM 14 DAYS CONTINOUSELY PREFERABLE - 28 DAYS.
8. START EARLY CURING TO AVOID SRINKAGE CRACKS, WHEN CONCRETE APPEARS TO HARDEN.
- 9) PROVIDE FOLLOWING SLUMP IN CONCRETE GEN-ERALLY.
- SHALLOW SECTIONS, PAVMENTS, MASS CONC. LIGTH REINFORCEMENT SECTION IN SLAB, BEAM, WALL, COLUMN 25-75
 - HEAVILY REINFORCEMENT SECTION IN SLAB 50-100
 - HEAVILY REINFORCEMENT SECTION IN BEAMS, WALLS, COLUMNS SLIPFORM, OR PUMPED CONC. 75-100
 - TRENCH FILL, PILLING, PUMPED CONC. 100-150
- 10) PROVIDE LAP/ DEVELOPEMENT LENGTH IN REINFORCEMENT BARS GRADE OF CONC.
- M20- 47Ø
M25-41Ø
M30-38Ø
- 11) REFER RELEVANT DRG. WITH THIS DRG.
- 12) AVOID CORE CUTING.

DRG NO:
DP0001 DRG CL 01 107

SHEET NO:
5 OF 9

REV.
R0

SCALE:
NTS

DESIGNED:
UPENDRA SINGH

DRAWN:
SIMRAN SONI

CHECKED:
UPENDRA SINGH

VERIFIED:
ADMIN

APPROVED:
ADMIN

ISSUED FOR:
TENDOR PURPOSE

UNIT:
MILIMETER

DATE:
12.05.2022

CLIENT:
CHHATTISGARH STATE MINOR FOREST PRODUSE


PROJECT:
INCUBATION CENTER AT DEOBHOG GARIYABAND

TITLE:
LAC PROCESSING UNIT
BEAM LAYOUT

SWATI Architecture landscape interior
ARCHITECTS | PLANERS | ENGINEERING | INTERIOR DESIGN
282 , tulip , A block , Talpuri International colony , Bhilai , C.G. Email - swati.arch@outlook.com

41


This drawing is the property of HUP DESIGN and is to be used only for the purpose for which it was lent and must not be in any way detrimental to the interest of the company and is subject to return on demand

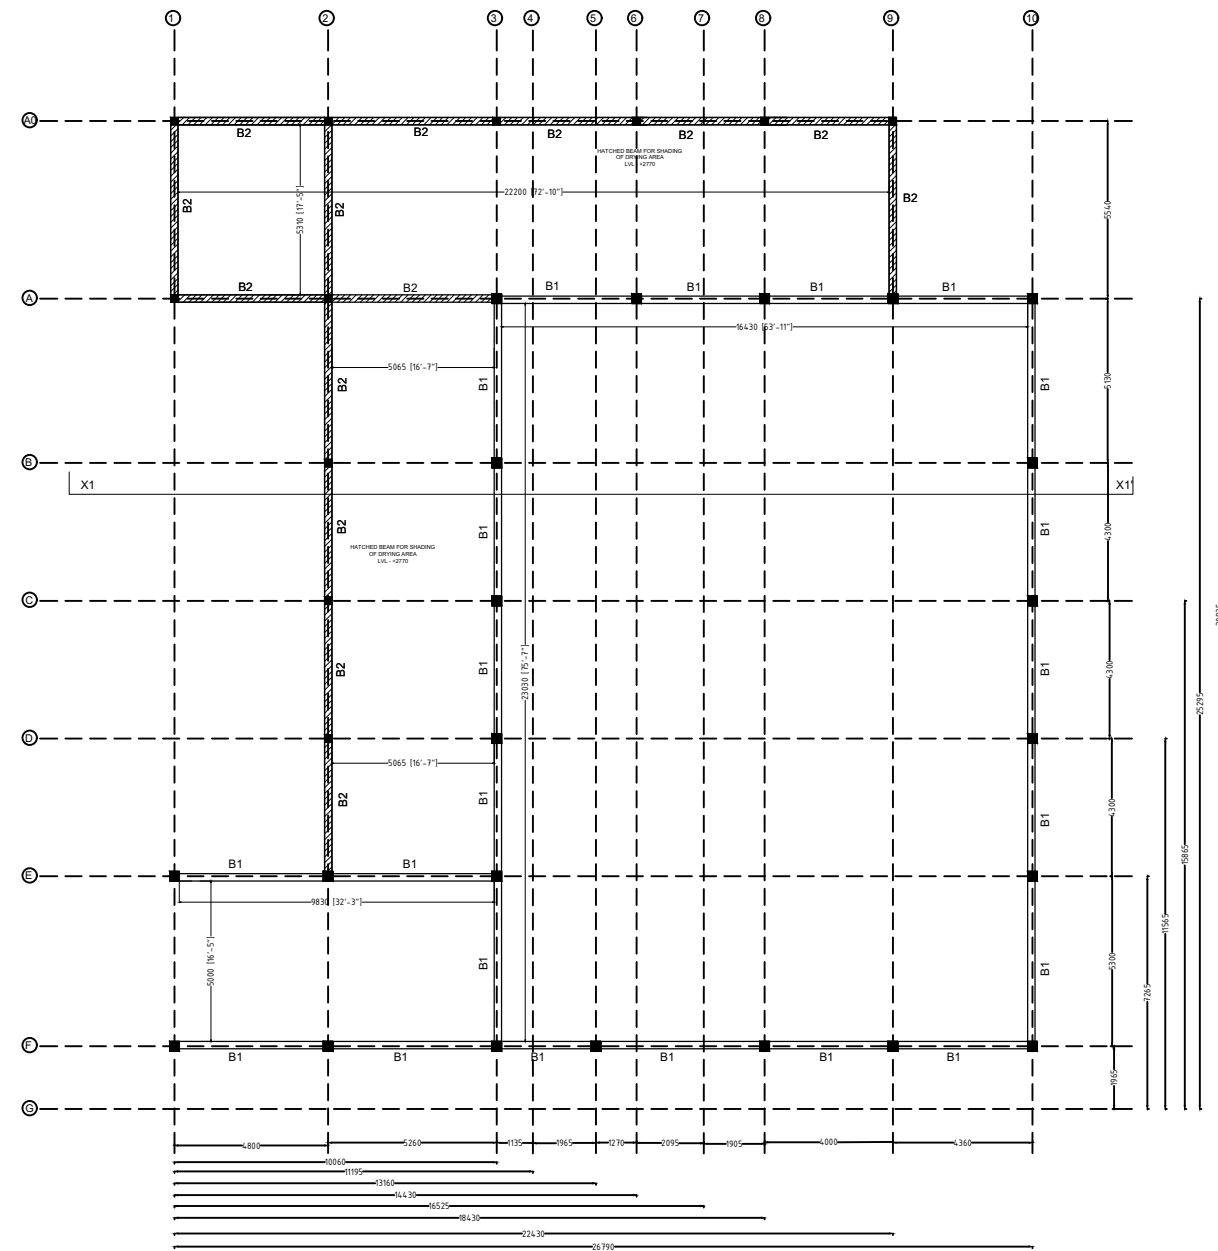

BEAM PLAN(2.4 m ABOVE PLINTH LVL)

BEAM SCHEDULE FOR 2.4m LVL. ABOVE PLINTH

Beam ID	Span	Top Reinforcement	Bottom Reinforcement	Top Reinforcement	Bottom Reinforcement	Top Reinforcement	Top Reinforcement	Top Reinforcement	Notes
B1	230X300	2-T12	2-T12	2-T12	2-T12	2-T12	T8 @200C/C	T8 @175C/C	T8 @175C/C
									SLAB THK INCLUDED

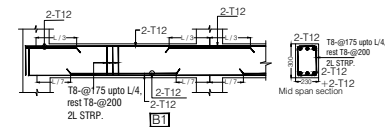

GENERAL NOTES

- NOTES-
- USE - M 20 GRADE OF CONC. AS/IS 426-5000
 - USE - FE 500 GRADE OF REINF. BY CLIENT
 - PROVIDE CLEAR COVER TO MAIN REINF.
- FOUNDATION- 50MM
COLUMN - 40MM
BEAM - 25MM
SLAB - 20MM OR DIA OF BAR, WHICHEVER IS MORE,
R.C.C. WALL - 25MM
- TIES SHOULD BE BEND INSIDE WITH 10# LENGTH IN BEAM & COLUMN
- 5.FOLLOW - IS-456-2000 FOR R.C.C. WORK
6.STRIPPING TIME FOR SHUTTERING / FORMWORK UNDER NORMAL CONDITION.
- | TYPE OF WORK | MINIMUM PERIOD BEFORE STRIKING FORM WORK |
|--|--|
| a) VERTICAL FORMWORK TO COLUMN, WALLS, BEAM | 16-24 HOUR |
| b) SOFFITS FORMWORK TO SLABS (PROPS TO BE REFIXED- IMMEDIATELY AFTER REMOVAL OF FORMWORK) | 3 DAYS |
| c) SOFFIT FORMWORK TO BEAMS (PROPS TO BE REFIXED IMMEDIATELY AFTER REMOVAL OF FORMWORK) | 7DAYS |
| d) PROPS TO SLABS: | |
| 1) SPANNING UP TO 4.5M | 7DAYS |
| 2) SPANNING OVER 4.5M | 14 DAYS |
| e) PROPS TO BEAMS & ARCHES: | |
| 1) SPANNING UP TO 6M | 14DAYS |
| 2) SPANNING OVER 6M | 21DAYS |
- CURING FOR R.C.C. MEMBER MINIMUM 14 DAYS CONTINOUSELY PREFERABLE - 28 DAYS.
 - START EARLY CURING TO AVOID SRINKAGE CRACKS, WHEN CONCRETE APPEARS TO HARDEN.
 - PROVIDE FOLLOWING SLUMP IN CONCRETE GEN-ERALLY.
- | | |
|---|---------|
| a) SHALLOW SECTIONS, PAVMENTS, MASS CONC. LIGTH REINFORCEMENT SECTION IN SLAB, BEAM, WALL, COLUMN | 25-75 |
| b) HEAVILY REINFORCEMENT SECTION IN SLAB | 50-100 |
| c) HEAVILY REINFORCEMENT SECTION IN BEAMS, WALLS, COLUMNS SLIPFORM, OR PUMPED CONC. | 75-100 |
| d) TRENCH FILL, PILLING, PUMPED CONC. | 100-150 |
- PROVIDE LAP/ DEVELOPEMENT LENGTH IN REINFORCEMENT BARS GRADE OF CONC.
- M20- 47Ø
M25-41Ø
M30-38Ø
- REFER RELEVANT DRG. WITH THIS DRG.
 - AVOID CORE CUTING.

DRG NO:	SHEET NO:	REV.	SCALE:
DP0001 DRG CL 01 107	6 OF 9	R0	NTS
DESIGNED:	DRAWN:	CHECKED:	VERIFIED:
UPENDRA SINGH	SIMRAN SONI	UPENDRA SINGH	ADMIN
ISSUED FOR:	UNIT:	DATE:	
TENDOR PURPOSE	MILIMETER	12.05.2022	

This drawing is the property of HUP DESIGN and is to be used only for the purpose for which it was lent and must not be in any way detrimental to the interest of the company and is subject to return on demand

SWATI Architecture landscape interior

ARCHITECTS | PLANERS | ENGINEERING | INTERIOR DESIGN


282 , tulip , A block , Talpuri International colony , Bhilai , C.G. Email - swati.archi@outlook.com

CHHATTISGARH STATE MINOR FOREST PRODUCE


INCUBATION CENTER AT DEOBHOG GARIYABAND

LAC PROCESSING UNIT
BEAM LAYOUT

42

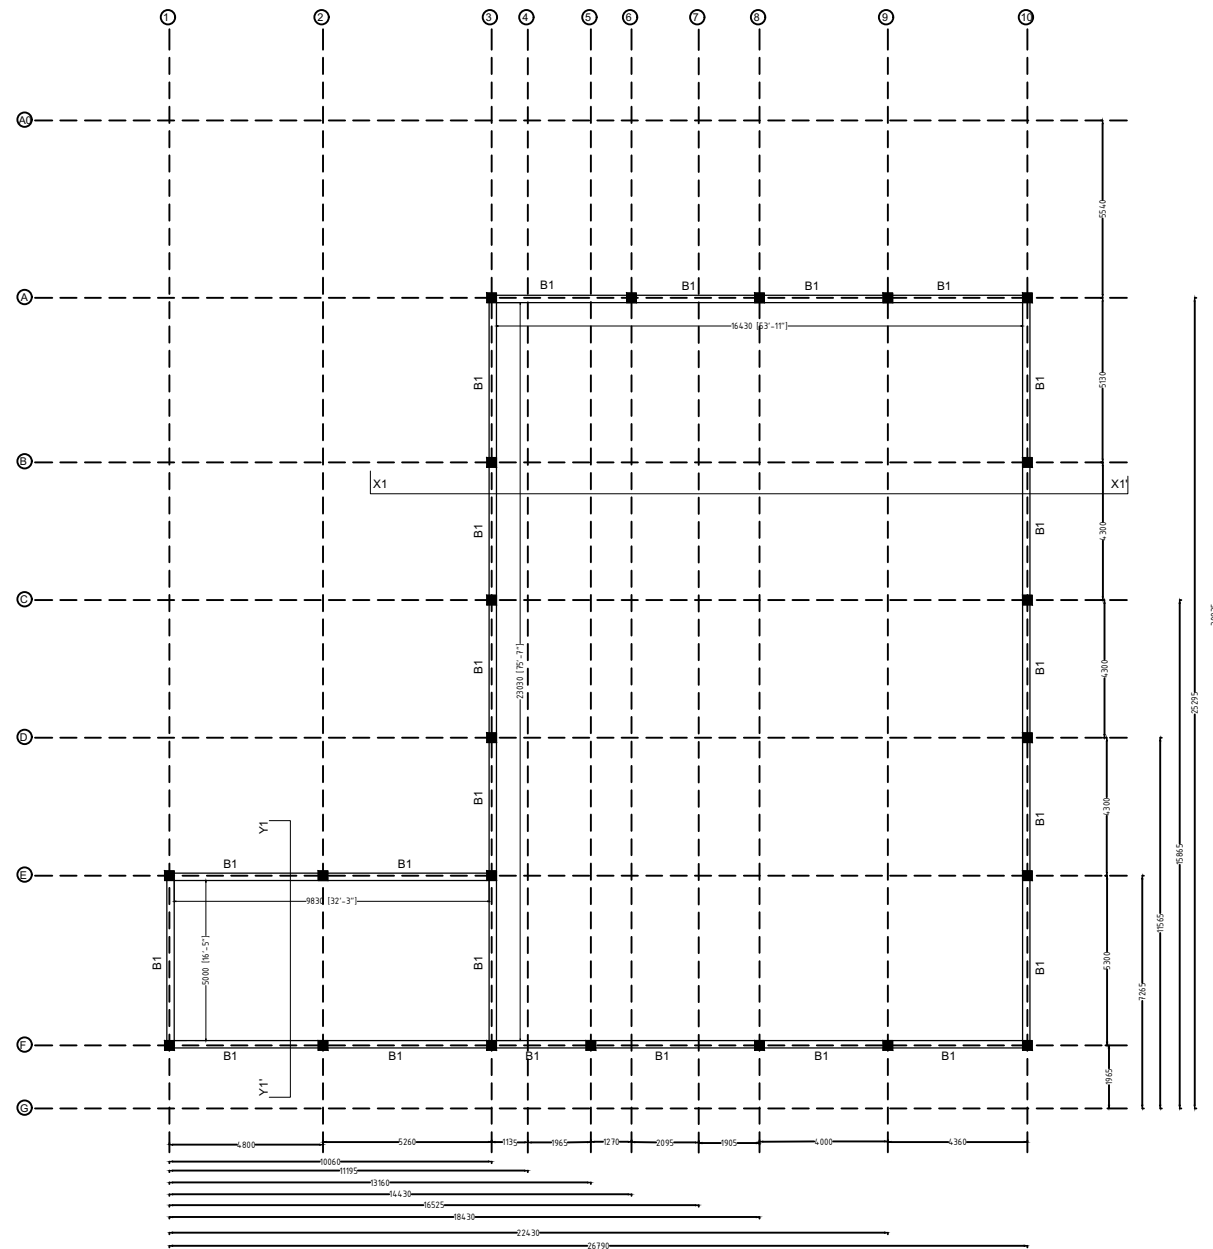

BEAM PLAN (4.5 ABOVE PLINTH LVL)

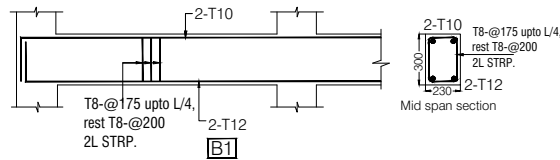


BEAM SCHEDULE FOR 4.5m LVL. ABOVE PLINTH


Beam ID	Size	Reinforcement	Notes
B1	230X300	2-T12	-
B1	230X300	2-T10	-
B1	230X300	2-T10	-
GENERAL NOTES


- NOTES-
- USE - M 20 GRADE OF CONC. AS/IS 426-5000
 - USE - FE 500 GRADE OF REINF. BY CLIENT
 - PROVIDE CLEAR COVER TO MAIN REINF.
- FOUNDATION- 50MM
COLUMN - 40MM
BEAM - 25MM
SLAB - 20MM OR DIA OF BAR, WHICHEVER IS MORE,
R.C.C. WALL - 25MM
- 4.TIES SHOULD BE BEND INSIDE WITH 10# LENGTH IN BEAM & COLUMN
- 5.FOLLOW - IS-456-2000 FOR R.C.C. WORK
- 6.STRIPPING TIME FOR SHUTTERING / FORMWORK UNDER NORMAL CONDITION.
- | TYPE OF WORK | MINIMUM PERIOD BEFORE STRIKING FORM WORK |
|--|--|
| a) VERTICAL FORMWORK TO COLUMN, WALLS, BEAM | 16-24 HOUR |
| b) SOFFITS FORMWORK TO SLABS (PROPS TO BE REFIXED- IMMEDIATELY AFTER REMOVAL OF FORMWORK) | 3 DAYS |
| c) SOFFIT FORMWORK TO BEAMS (PROPS TO BE REFIXED IMMEDIATELY AFTER REMOVAL OF FORMWORK) | 7DAYS |
| d) PROPS TO SLABS: | |
| 1) SPANNING UP TO 4.5M | 7DAYS |
| 2) SPANNING OVER 4.5M | 14 DAYS |
| e) PROPS TO BEAMS & ARCHES: | |
| 1) SPANNING UP TO 6M | 14DAYS |
| 2) SPANNING OVER 6M | 21DAYS |
7. CURING FOR R.C.C. MEMBER MINIMUM 14 DAYS CONTINOUSELY PREFERABLE - 28 DAYS.
8. START EARLY CURING TO AVOID SRINKAGE CRACKS, WHEN CONCRETE APPEARS TO HARDEN.
- 9) PROVIDE FOLLOWING SLUMP IN CONCRETE GEN-ERALLY.
- | | |
|---|---------|
| a) SHALLOW SECTIONS, PAVMENTS, MASS CONC. LIGTH REINFORCEMENT | 25-75 |
| b) HEAVILY REINFORCEMENT SECTION IN SLAB | 50-100 |
| c) HEAVILY REINFORCEMENT SECTION IN BEAMS, WALLS, COLUMNS SLIPFORM, OR PUMPED CONC. | 75-100 |
| d) TRENCH FILL, PILLING, PUMPED CONC. | 100-150 |
- 10) PROVIDE LAP/ DEVELOPEMENT LENGTH IN REINFORCEMENT BARS GRADE OF CONC.
- M20- 47Ø
M25-41Ø
M30-38Ø
- 11) REFER RELEVANT DRG. WITH THIS DRG.
- 12) AVOID CORE CUTING.

DRG NO: DP0001 DRG CL 01 107	SHEET NO: 7 OF 9	REV. R0	SCALE: NTS	SWATI Architecture landscape interior ARCHITECTS PLANERS ENGINEERING INTERIOR DESIGN 282 , tulip , A block , Talpuri International colony , Bhilai , C.G. Email - swati.arch@outlook.com	
DESIGNED: UPENDRA SINGH	DRAWN: SIMRAN SONI	CHECKED: UPENDRA SINGH	VERIFIED: ADMIN	APPROVED: ADMIN	CLIENT: CHHATTISGARH STATE MINOR FOREST PRODUSE
ISSUED FOR: TENDOR PURPOSE				UNIT: MILIMETER	DATE: 12.05.2022
PROJECT: INCUBATION CENTER AT DEOBHOG GARIYABAND				TITLE: LAC PROCESSING UNIT BEAM LAYOUT	
This drawing is the property of HUP DESIGN and is to be used only for the purpose for which it was lent and must not be in any way detrimental to the interest of the company and is subject to return on demand				43	

 44

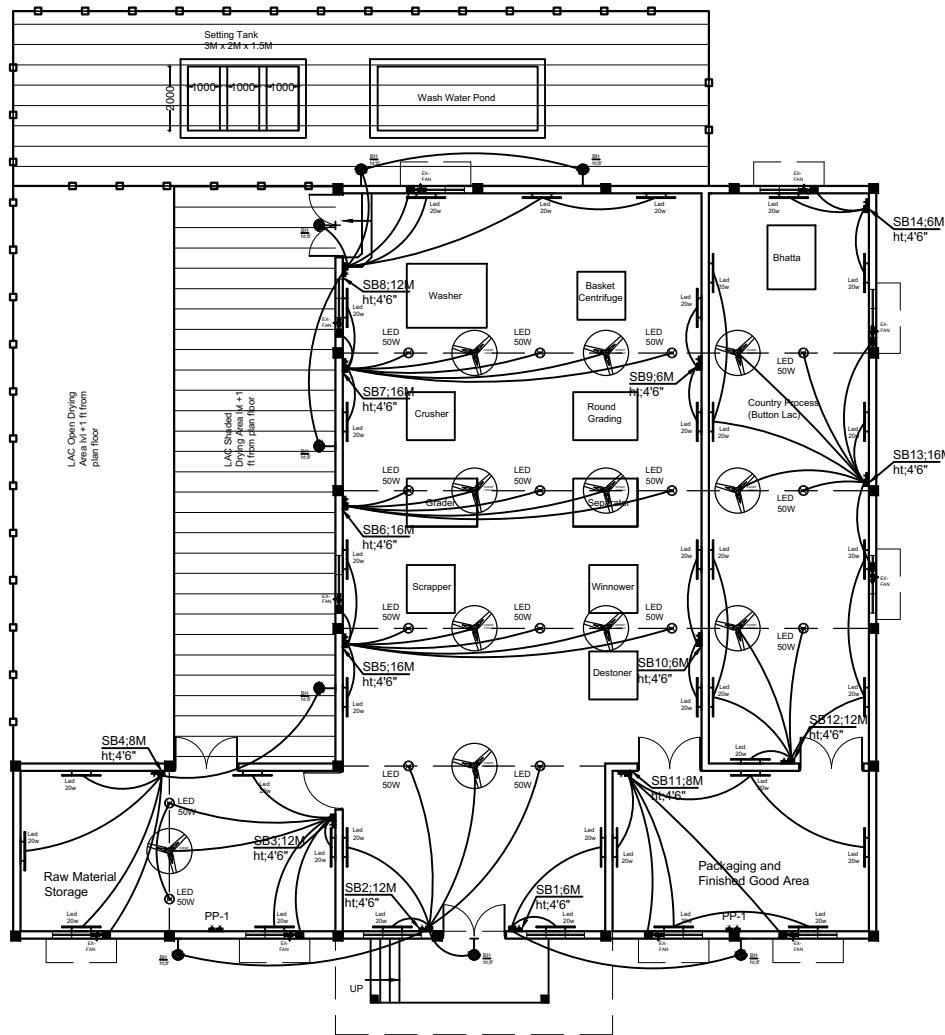

ELECTRICAL LAYOUT

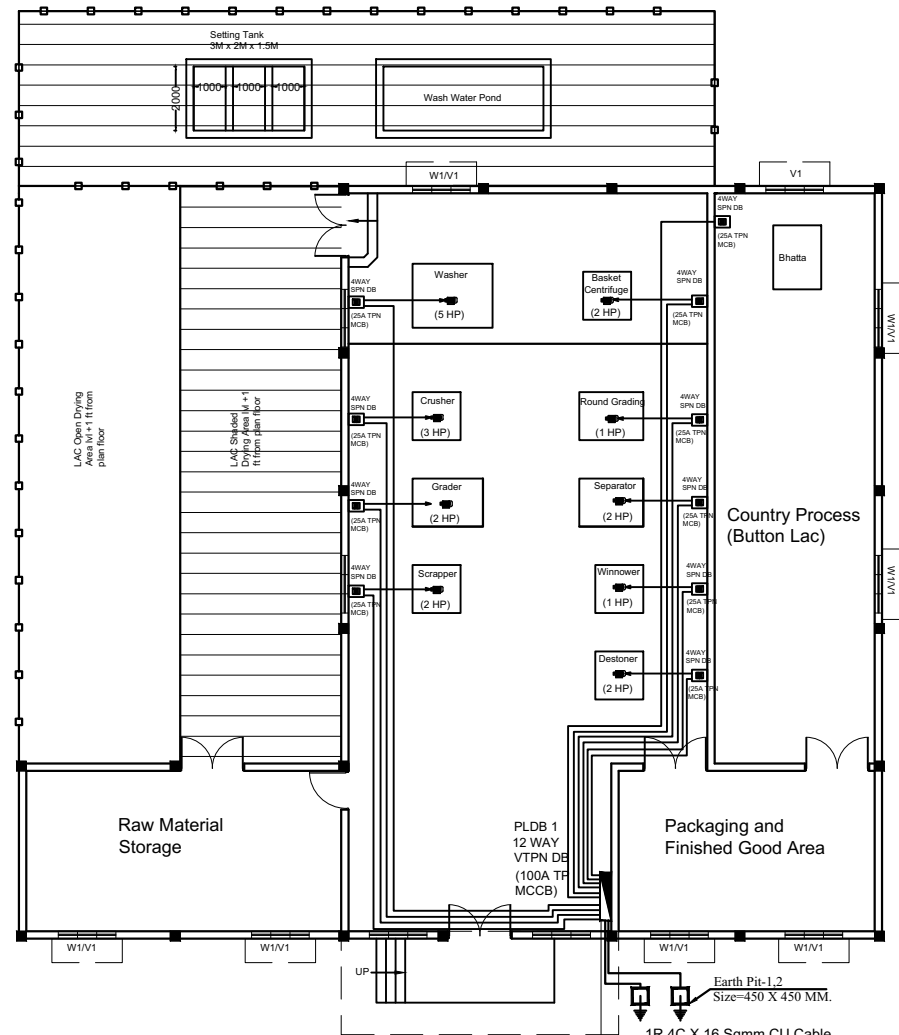


LAC PROCESSING UNIT

MACHINE LIST					
1 - SCRAPPER - 100kg/hr- nos 1	2 HP	01	2 HP	6 X 6 Sqmm CU wire	
2 - GRADING MACHINE - 100kg/hr - nos 1	2 HP	01	2 HP	6 X 6 Sqmm CU wire	
3 - CRUSHER - 100kg/ HR - nos 1	3 HP	01	3 HP	6 X 6 Sqmm CU wire	
4 - WASHER - 100kg/hr - nos1	5 HP	01	5 HP	6 X 6 Sqmm CU wire	
5 - BASKET CENTRIFUGE -50 KG / BATCH - nos 1	2 HP	01	2 HP	6 X 6 Sqmm CU wire	
6 - ROUND GRADING MACHINE -100 KG / HR nos 1	1 HP	01	1 HP	6 X 6 Sqmm CU wire	
7 - WINNOWER - 100KG / HR - nos 1	1 HP	01	1 HP	6 X 6 Sqmm CU wire	
8 - DESTONER - 100KG / HR - NOS 1	2 HP	01	2 HP	6 X 6 Sqmm CU wire	
9 - SEPARATOR - 100 KG / HR - NOS 1	2 HP	01	2 HP	6 X 6 Sqmm CU wire	
TOTAL LOAD	3P MCCB 100A	(15 KW)	(40 AMP)	20 HP	1R 4C 16 Sqmm Ar. CU Cable

01	LED 50W	50W FLOOD LIGHT (HIGH BAY)	16 No.
02	WALL LIGHT	WALL LIGHT	08 No.
03	PP-1	16A SWITCH SOCKET	04 No.
04	LP-1	6A SWITCH SOCKET	02 No.
05	4WAY SPN DB	4WAY SPN DB	09 No.
06	PLDB 1 12 WAY VTPN DB	PLDB 1 12 WAY VTPN DB	01 No.
07	1400 mm Ceiling Fan	1400 mm Ceiling Fan	04 No.
08	20w Led Tube Light	20w Led Tube Light	36 No.
09	450 mm Ex Fan	450 mm Ex Fan	10 No.
10	LP-1	6A SWITCH SOCKET	14 No.
11	SB1	SWITCH BOARD	14 No.
12	6 X 6 SQMM CU WIRE	6 X 6 SQMM CU WIRE	
13	3 X 1.5 SQMM CU WIRE	3 X 1.5 SQMM CU WIRE	
14	Earth Pit-1 Size=450 X 450 MM.	Earth Pit-1 Size=450 X 450 MM.	2 SET

DRG NO: SHEET NO: REV. SCALE:					SWATI Architecture landscape interior ARCHITECTS PLANERS ENGINEERING INTERIOR DESIGN 282 , tulip , A block , Talpuri International colony , Bhilai , C.G. Email - swati.arch@outlook.com		
DP0001 DRG CL 01 107 9 OF 9 R0 NTS							
DESIGNED: DRAWN: CHECKED: VERIFIED: APPROVED:					CLIENT:		
UPENDRA SINGH SIMRAN SONI UPENDRA SINGH ADMIN ADMIN					CHHATTISGARH STATE MINOR FOREST PRODUCE		
ISSUED FOR: TENDOR PURPOSE UNIT: DATE:					PROJECT:		
MILIMETER 12.05.2022					INCUBATION CENTER AT DEOBHOG GARIYABAND		
This drawing is the property of HUP DESIGN and is to be used only for the purpose for which it was lent and must not be in any way detrimental to the interest of the company and is subject to return on demand					TITLE:		
					LAC PROCESSING UNIT ELECTRICAL LAYOUT		
					45		

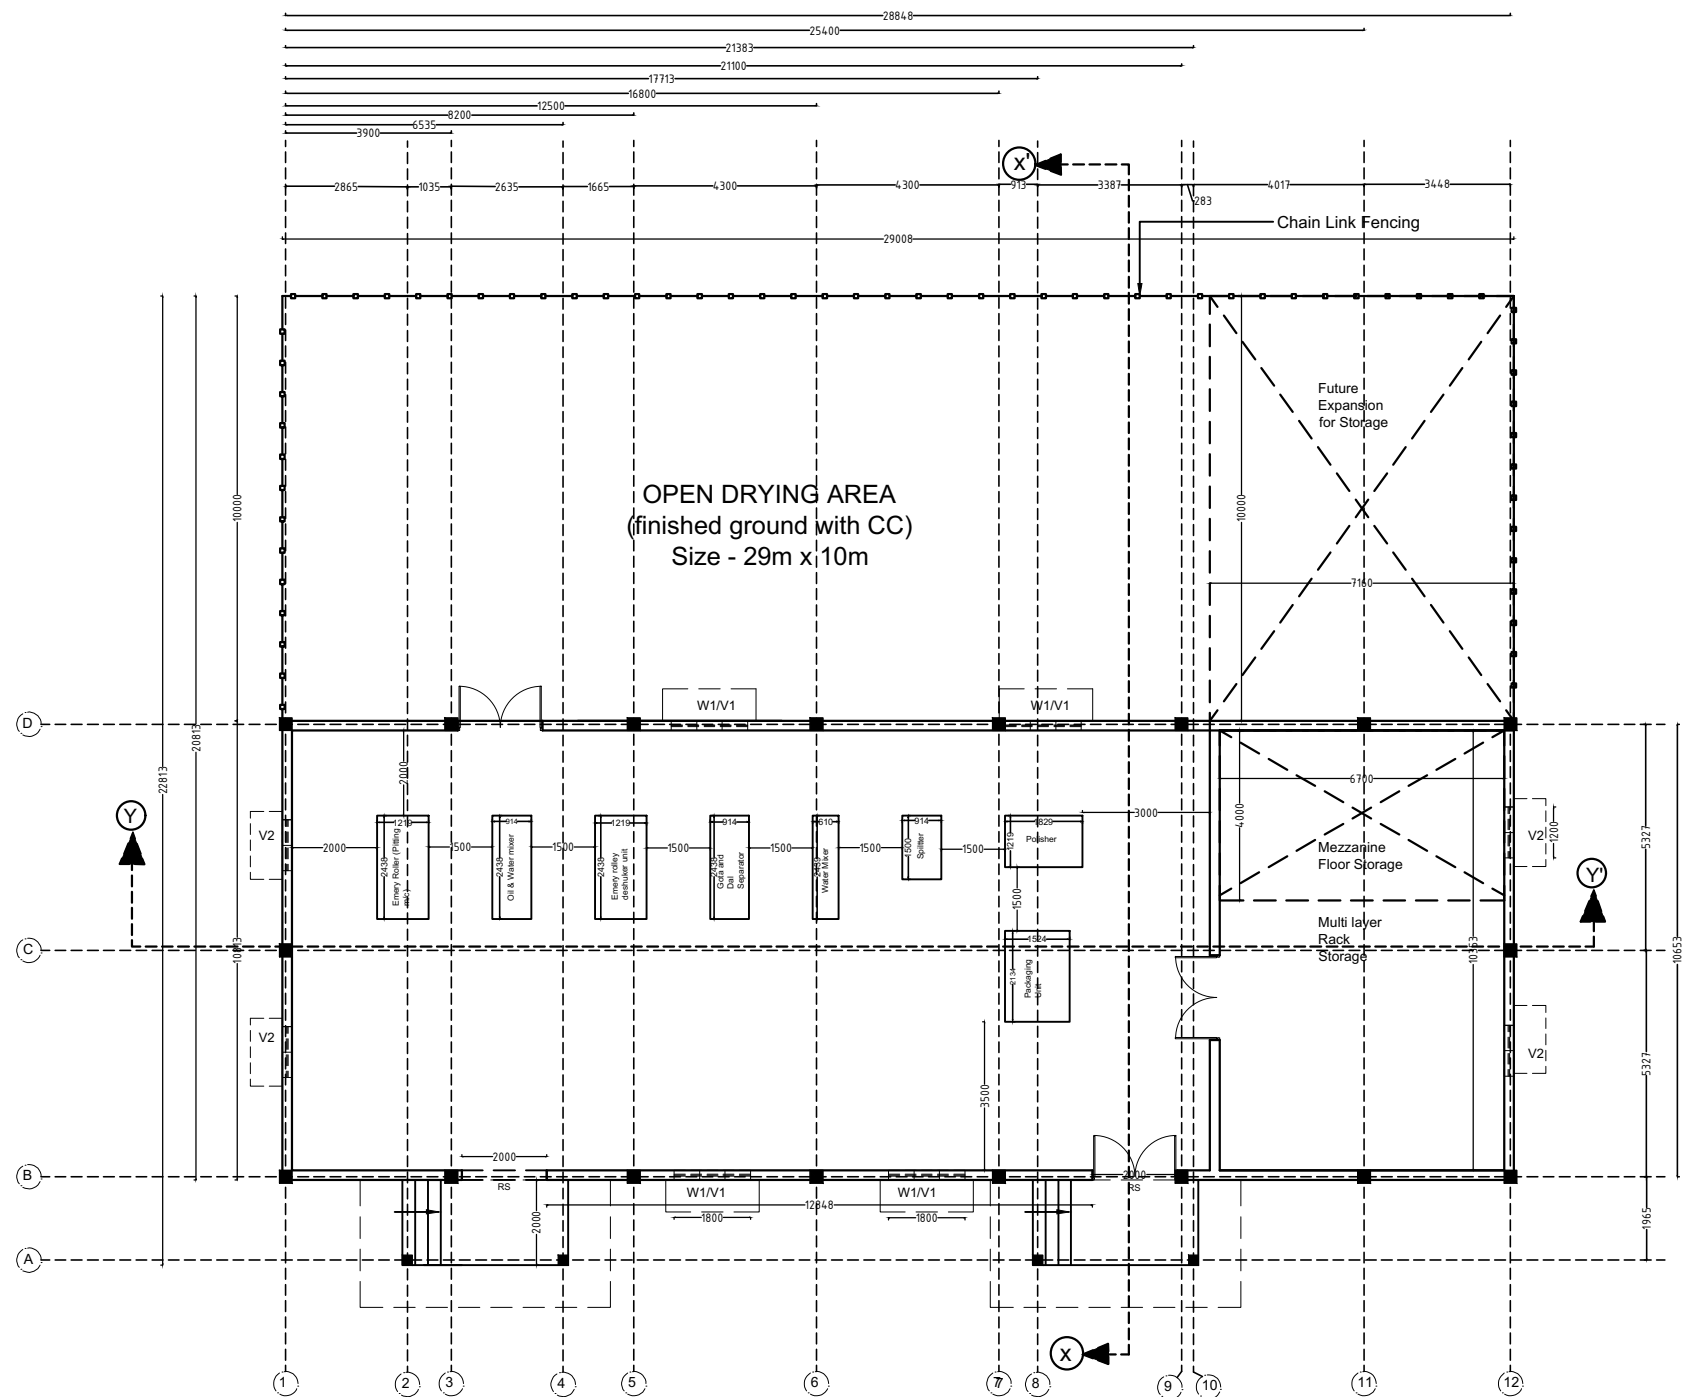

PULSE MILLING UNIT
BUILTUP AREA - 314 SQM
DRYING PLATFORM AREA - 290 SQM


- LIST OF DRAWING**
PULSE MILLING UNIT
DP0001 DRG CL 01 106
- 1 - PLAN LAYOUT
 - 2 - SECTION / ELEVATION
 - 3 - COLUMN LAYOUT
 - 4 - FOOTING LAYOUT
 - 5 - GROUND BEAM LAYOUT
 - 6 - BEAM LAYOUT (2.5 M ABOVE)
 - 7 - BEAM LAYOUT (4.5 M ABOVE)
 - 8 - TRUSS DETAIL
 - 9 - ELECTRICAL LAYOUT

OPENING SCHEDULE


NAME	SAYMBOL
WINDOW	- W1
VENTILATOR	- V1
ROLLING SHUTTER	- R1
DOOR	- D1

SN	SAYMBOL	NOS	SIZE
01	W1	04	1.8M X 1.5M
02	V1	08	1.8 M X 1 M
03	D2	03	2M X 2.1 M
04	R1	01	2.5M X 2.4 M


DRG NO: DP0001 DRG CL 01 106	SHEET NO: 1 OF 9	REV. R0	SCALE: NTS	SWATI Architecture landscape interior ARCHITECTS PLANERS ENGINEERING INTERIOR DESIGN 282 , tulip , A block , Talpuri International colony , Bhilai , C.G. Email - swati.arch@outlook.com
DESIGNED: UPENDRA SINGH	DRAWN: SIMRAN SONI	CHECKED: UPENDRA SINGH	VERIFIED: ADMIN	APPROVED: ADMIN
ISSUED FOR: TENDOR PURPOSE	UNIT: MILIMETER	DATE: 12.05.2022	CLIENT: CHHATTISGARH STATE MINOR FOREST PRODUCE	PROJECT: INCUBATION CENTER AT DEOBHOG GARIYABAND
This drawing is the property of HUP DESIGN and is to be used only for the purpose for which it was lent and must not be in any way detrimental to the interest of the company and is subject to return on demand				TITLE: PULSE MILLING UNIT PLAN LAYOUT

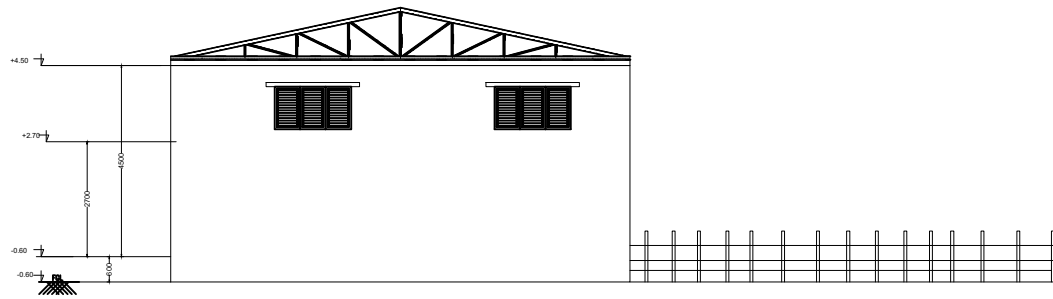


SIDE ELEVATION

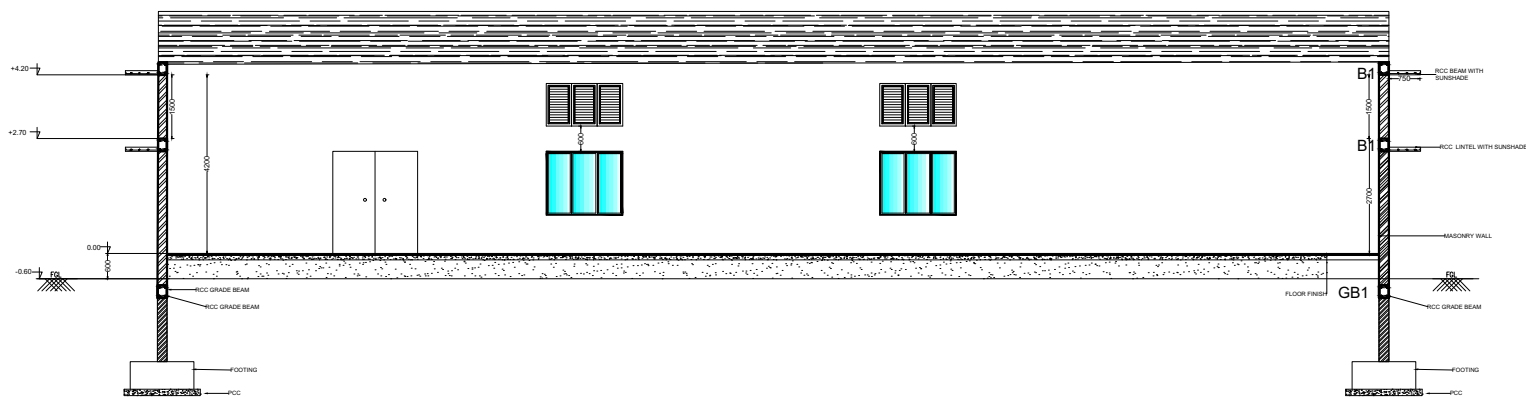

SECTION Y-Y'

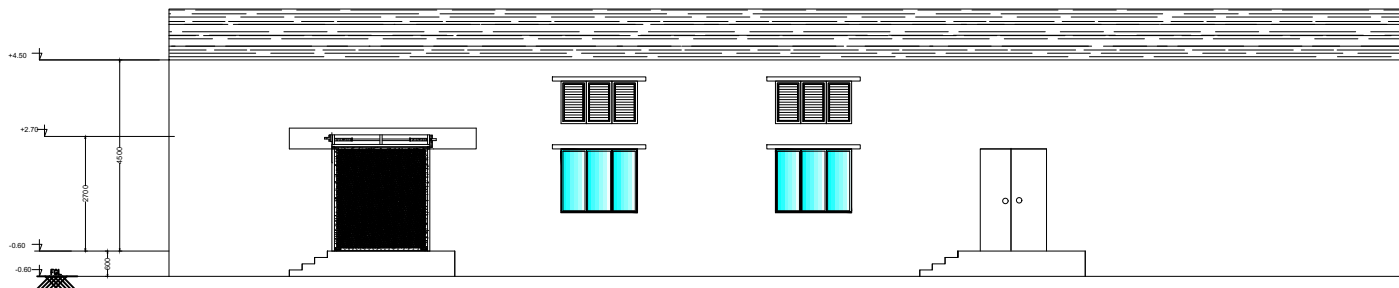


FRONT ELEVATION

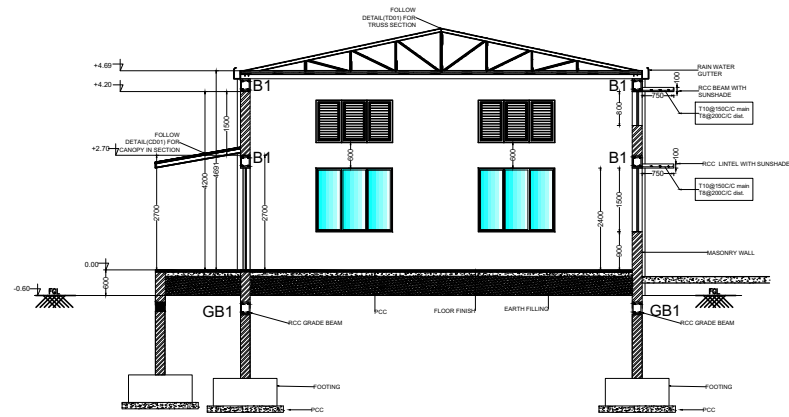


SECTION X-X'

DRG NO: DP0001 DRG CL 01 106					SHEET NO: 2 OF 9	REV. R0	SCALE: NTS	SWATI Architecture landscape interior ARCHITECTS PLANERS ENGINEERING INTERIOR DESIGN 282 , tulip , A block , Talpuri International colony , Bhilai , C.G. Email - swati.arch@outlook.com	
DESIGNED: UPENDRA SINGH		DRAWN: SIMRAN SONI		CHECKED: UPENDRA SINGH	VERIFIED: ADMIN	APPROVED: ADMIN		CLIENT:	CHHATTISGARH STATE MINOR FOREST PRODUCE
ISSUED FOR: TENDOR PURPOSE					UNIT: MILIMETER	DATE: 12.05.2022		PROJECT:	INCUBATION CENTER AT DEOBHOG GARIYABAND
This drawing is the property of HUP DESIGN and is to be used only for the purpose for which it was lent and must not be in any way detrimental to the interest of the company and is subject to return on demand								TITLE:	PULSE MILLING UNIT SECTION / ELEVATION 47

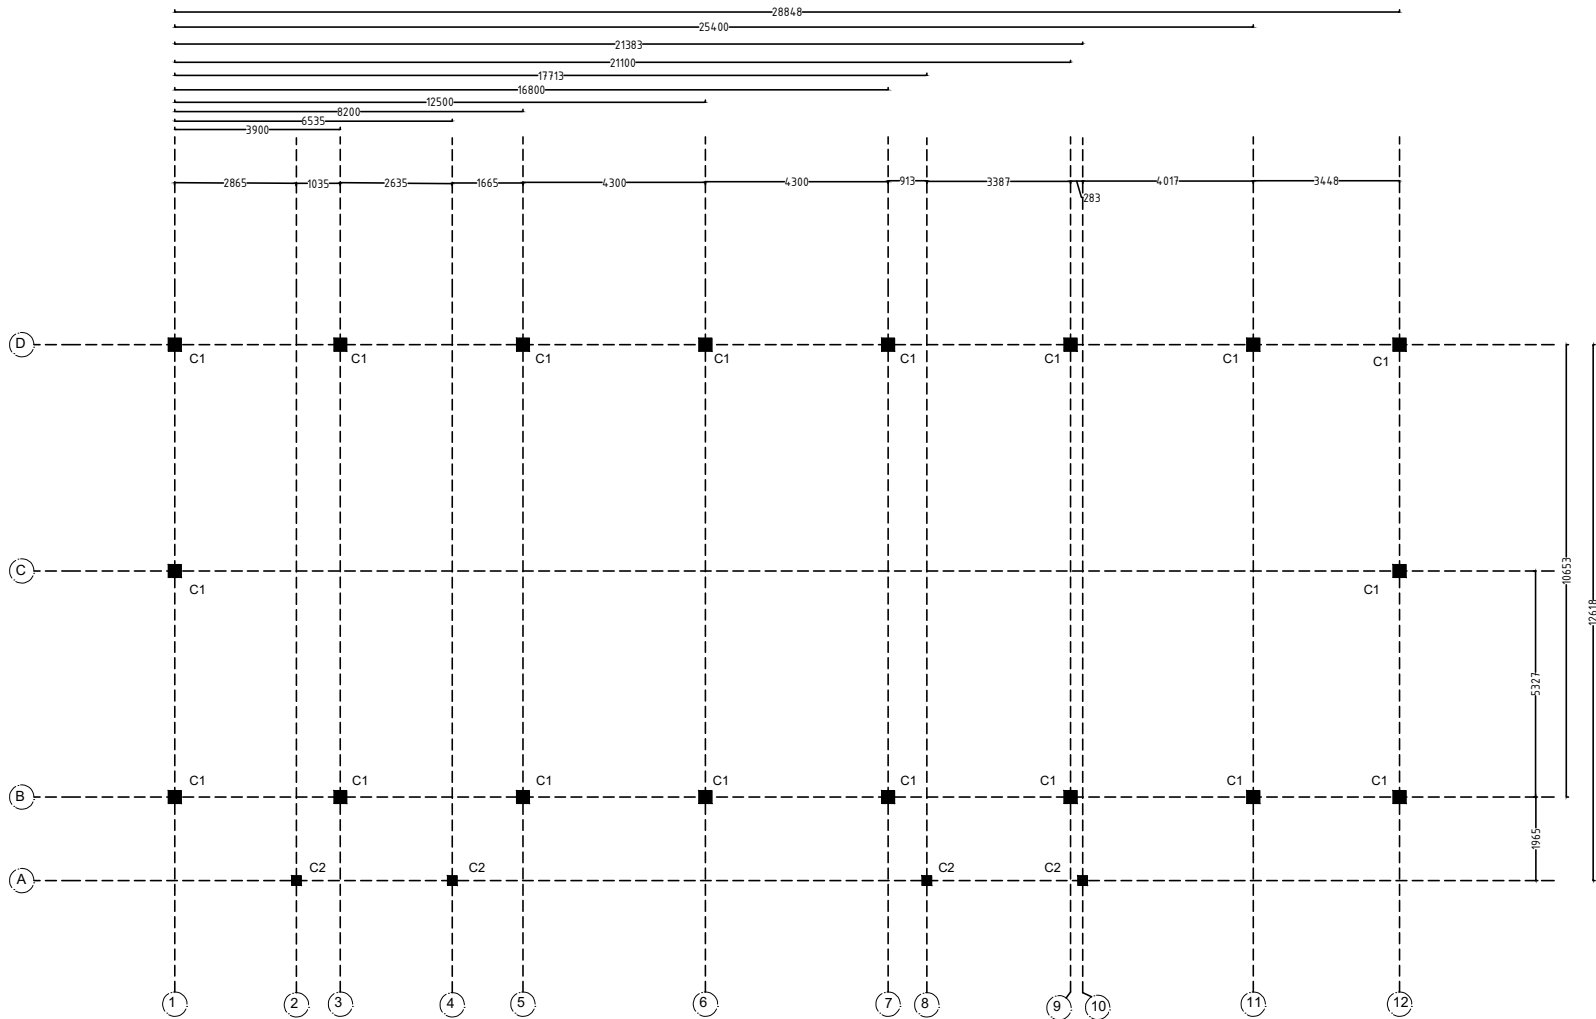

COLUMN LAYOUT

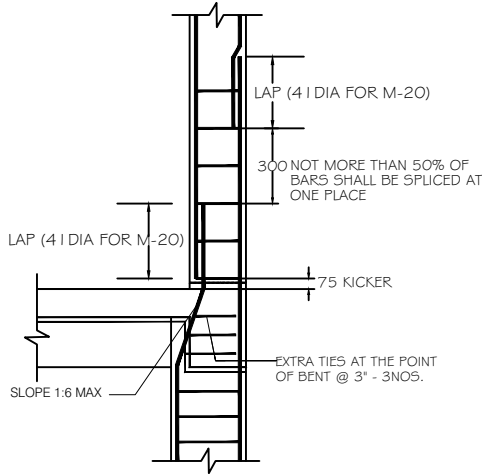


COLUMN DETAIL

GENERAL NOTES

NOTES-

 1. USE - M 20 GRADE OF CONC. AS/IS 426-5000
 2. USE - FE 500 GRADE OF REINF. BY CLIENT
 3. PROVIDE CLEAR COVER TO MAIN REINF.
- FOUNDATION- 50MM
COLUMN - 40MM
BEAM - 25MM
SLAB - 20MM OR DIA OF BAR, WHICHEVER IS MORE,
R.C.C. WALL - 25MM
4. TIES SHOULD BE BEND INSIDE WITH 10# LENGTH IN BEAM & COLUMN



5. FOLLOW - IS-456-2000 FOR R.C.C. WORK
6. STRIPPING TIME FOR SHUTTERING / FORMWORK UNDER NORMAL CONDITION.

TYPE OF WORK	MINIMUM PERIOD BEFORE STRIKING FORM WORK
a) VERTICAL FORMWORK TO COLUMN, WALLS, BEAM	16-24 HOUR
b) SOFFITS FORMWORK TO SLABS (PROPS TO BE REFIXED- IMMEDIATELY AFTER REMOVAL OF FORMWORK)	3 DAYS
c) SOFFIT FORMWORK TO BEAMS (PROPS TO BE REFIXED IMMEDIATELY AFTER REMOVAL OF FORMWORK)	7DAYS
d) PROPS TO SLABS:	
1) SPANNING UP TO 4.5M	7DAYS
2) SPANNING OVER 4.5M	14 DAYS
e) PROPS TO BEAMS & ARCHES:	
1) SPANNING UP TO 6M	14DAYS
2) SPANNING OVER 6M	21DAYS

7. CURING FOR R.C.C. MEMBER MINIMUM 14 DAYS CONTINUOUSLY PREFERABLE - 28 DAYS.
 8. START EARLY CURING TO AVOID SRINKAGE CRACKS, WHEN CONCRETE APPEARS TO HARDEN.
 9. PROVIDE FOLLOWING SLUMP IN CONCRETE GENERALLY.
- | | |
|---|---------|
| a) SHALLOW SECTIONS, PAYMENTS, MASS CONC. LIGHT REINFORCEMENT SECTION IN SLAB, BEAM, WALL, COLUMN | 25-75 |
| b) HEAVILY REINFORCEMENT SECTION IN SLAB | 50-100 |
| c) HEAVILY REINFORCEMENT SECTION IN BEAMS, WALLS, COLUMNS SLIPFORM, OR PUMPED CONC. | 75-100 |
| d) TRENCH FILL, FILLING, PUMPED CONC. | 100-150 |
- 10) PROVIDE LAP/ DEVELOPEMENT LENGTH IN REINFORCEMENT BARS GRADE OF CONC.
- M20- 47Ø
M25-41Ø
M30-38Ø
- 11) REFER RELEVANT DRG. WITH THIS DRG.
 - 12) AVOID CORE CUTING.

TYPICAL COLUMN DETAIL'S

COLUMN NAME	Pile/col detail	STIRRUPS	REMARKS
C1	 8-T12 TB@ 200 c/c 2-Tie		FOUNDATION TO TERRACE
C1	 4-T12 TB@ 200 c/c 1-Tie		TERMINATE AT GROUND LVL

DRG NO: DP0001 DRG CL 01 106		SHEET NO: 3 OF 9	REV. R0	SCALE: NTS	SWATI Architecture landscape interior ARCHITECTS PLANERS ENGINEERING INTERIOR DESIGN 282 , tulip , A block , Talpuri International colony , Bhilai , C.G. Email - swati.arch@outlook.com		
DESIGNED:	DRAWN:	CHECKED:	VERIFIED:	APPROVED:	CLIENT:	CHHATTISGARH STATE MINOR FOREST PRODUCE	
UPENDRA SINGH	SIMRAN SONI	UPENDRA SINGH	ADMIN	ADMIN			
ISSUED FOR: TENDOR PURPOSE			UNIT: MILIMETER	DATE: 12.05.2022	PROJECT:	INCUBATION CENTER AT DEOBHOG GARIYABAND	
This drawing is the property of HUP DESIGN and is to be used only for the purpose for which it was lent and must not be in any way detrimental to the interest of the company and is subject to return on demand					TITLE:	PULSE MILLING UNIT COLUMN LAYOUT	48

GENERAL NOTES

NOTES-

1. USE - M 20 GRADE OF CONC. AS/IS 426-5000
 2. USE - FE 500 GRADE OF REINF. BY CLIENT
 3. PROVIDE CLEAR COVER TO MAIN REINF.
- FOUNDATION- 50MM
COLUMN - 40MM
BEAM - 25MM
SLAB - 20MM OR DIA OF BAR, WHICHEVER IS MORE,
R.C.C. WALL - 25MM
4. TIES SHOULD BE BEND INSIDE WITH 10# LENGTH IN BEAM & COLUMN

5. FOLLOW - IS-456-2000 FOR R.C.C. WORK
6. STRIPPING TIME FOR SHUTTERING / FORMWORK UNDER NORMAL CONDITION.

TYPE OF WORK	MINIMUM PERIOD BEFORE STRIKING FORM WORK
--------------	--


- | | |
|--|------------|
| a) VERTICAL FORMWORK TO COLUMN, WALLS, BEAM | 16-24 HOUR |
| b) SOFFITS FORMWORK TO SLABS (PROPS TO BE REFIXED- IMMEDIATELY AFTER REMOVAL OF FORMWORK) | 3 DAYS |
| c) SOFFIT FORMWORK TO BEAMS (PROPS TO BE REFIXED IMMEDIATELY AFTER REMOVAL OF FORMWORK) | 7DAYS |
| d) PROPS TO SLABS: | |
| 1) SPANNING UP TO 4.5M | 7DAYS |
| 2) SPANNING OVER 4.5M | 14 DAYS |
| e) PROPS TO BEAMS & ARCHES: | |
| 1) SPANNING UP TO 6M | 14DAYS |
| 2) SPANNING OVER 6M | 21DAYS |

7. CURING FOR R.C.C. MEMBER MINIMUM 14 DAYS CONTINUOUSLY PREFERABLE - 28 DAYS.
8. START EARLY CURING TO AVOID SHRINKAGE CRACKS, WHEN CONCRETE APPEARS TO HARDEN.
9. PROVIDE FOLLOWING SLUMP IN CONCRETE GENERALLY.


- | | |
|---|---------|
| a) SHALLOW SECTIONS, PAYMENTS, MASS CONC. LIGHT REINFORCEMENT SECTION IN SLAB, BEAM, WALL, COLUMN | 25-75 |
| b) HEAVILY REINFORCEMENT SECTION IN SLAB | 50-100 |
| c) HEAVILY REINFORCEMENT SECTION IN BEAMS, WALLS, COLUMNS SLIPFORM, OR PUMPED CONC. | 75-100 |
| d) TRENCH FILL, FILLING, PUMPED CONC. | 100-150 |
| 10) PROVIDE LAP/ DEVELOPEMENT LENGTH IN REINFORCEMENT BARS GRADE OF CONC. | |

M20- 47Ø
M25-41Ø
M30-38Ø


- 11) REFER RELEVANT DRG. WITH THIS DRG.
- 12) AVOID CORE CUTTING.

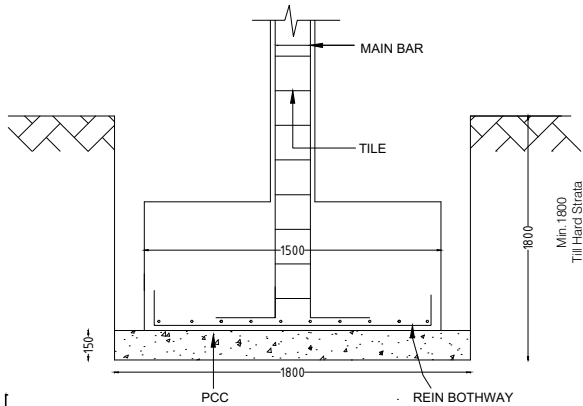

TYPICAL FOOTING SECTION (1-1')

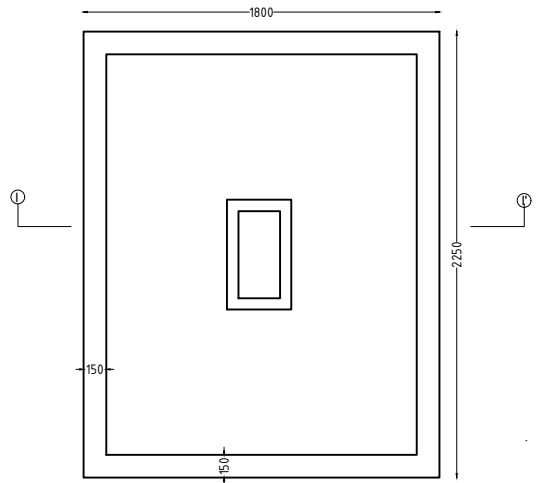

TYPICAL FOOTING PLAN

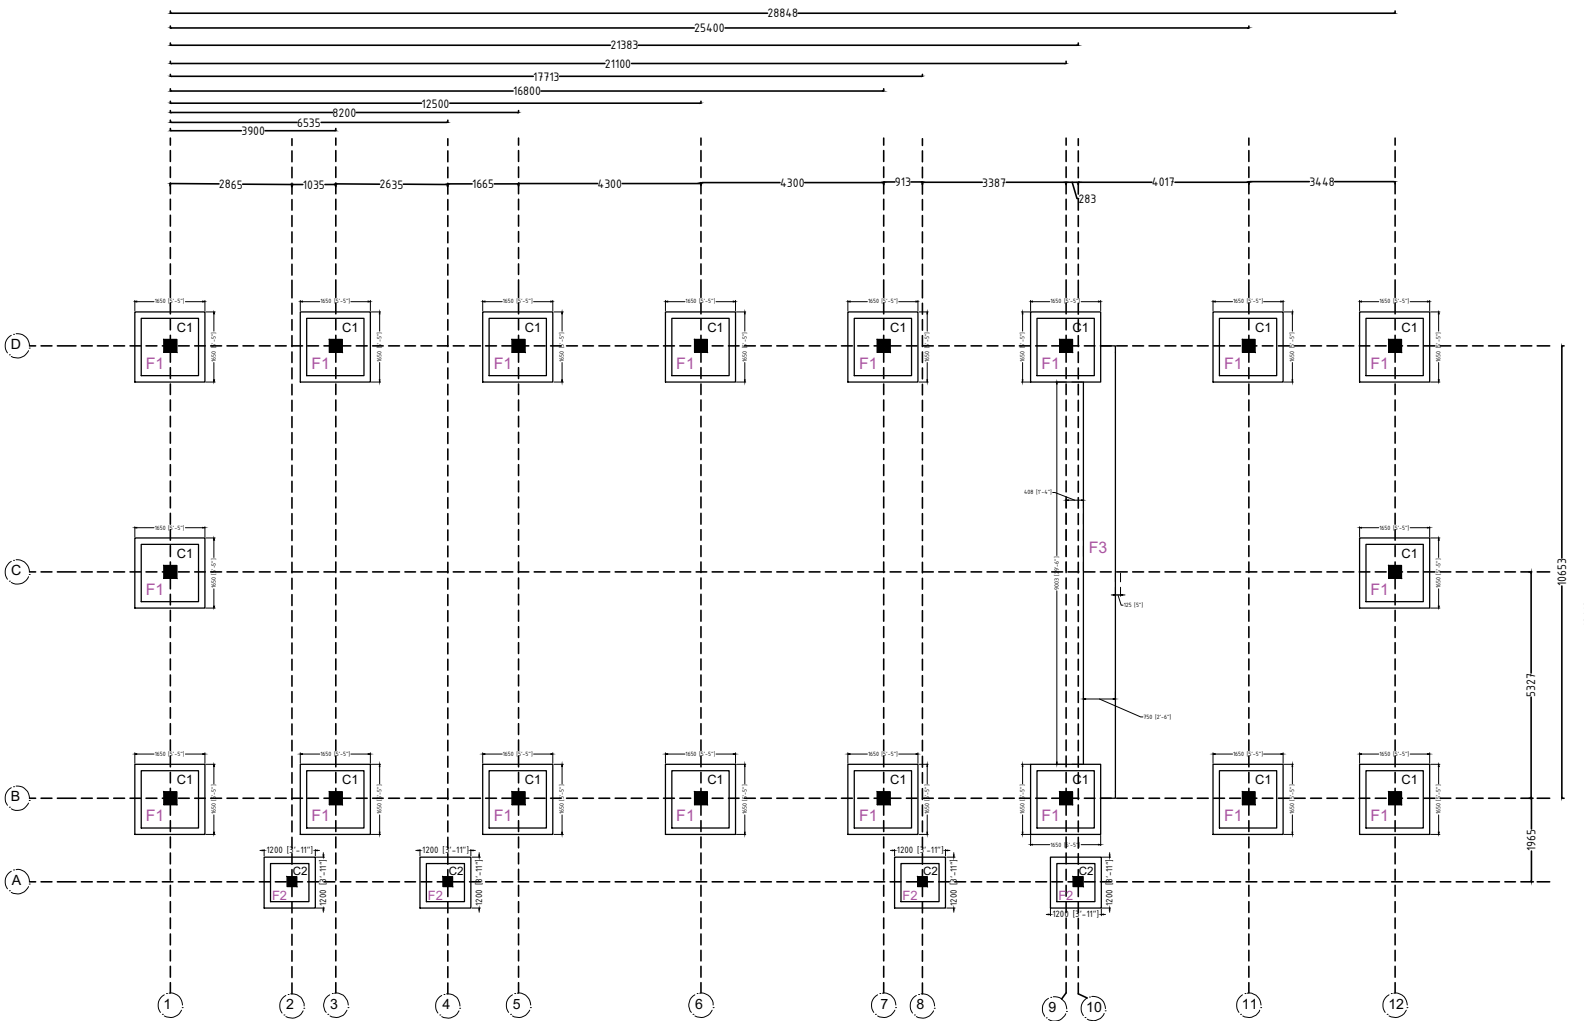

FOOTING LAYOUT

FOOTING SCHEDULE

FE500 AND M20

Footings	Column Nos	PCC Size X - Y mm	Footing Size X - Y mm	Total Depth mm	Steel to X mm	Steel to Y mm	Remarks
F1	C1	1650 X 1650	1350 X 1350	400	T10@ 175C/C	T10@ 175 C/C	Bottom bars only
F2	C2	1200 X 1200	900 X 900	230	T8@200C/C	T8@ 200 C/C	Bottom bars only

DRG NO:	SHEET NO:	REV.	SCALE:
DP0001 DRG CL 01 106	4 OF 9	R0	NTS
DESIGNED:	DRAWN:	CHECKED:	VERIFIED:
UPENDRA SINGH	SIMRAN SONI	UPENDRA SINGH	ADMIN
ISSUED FOR:	UNIT:	DATE:	
TENDOR PURPOSE	MILIMETER	12.05.2022	

This drawing is the property of HUP DESIGN and is to be used only for the purpose for which it was lent and must not be in any way detrimental to the interest of the company and is subject to return on demand


SWATI Architecture landscape interior

ARCHITECTS | PLANERS | ENGINEERING | INTERIOR DESIGN
282 , tulip , A block , Talpuri International colony , Bhillai , C.G. Email - swati.arch@outlook.com


CHHATTISGARH STATE MINOR FOREST PRODUCE

INCUBATION CENTER AT DEOBHOG GARIYABAND

TITLE:
PULSE MILLING UNIT
FOOTING LAYOUT

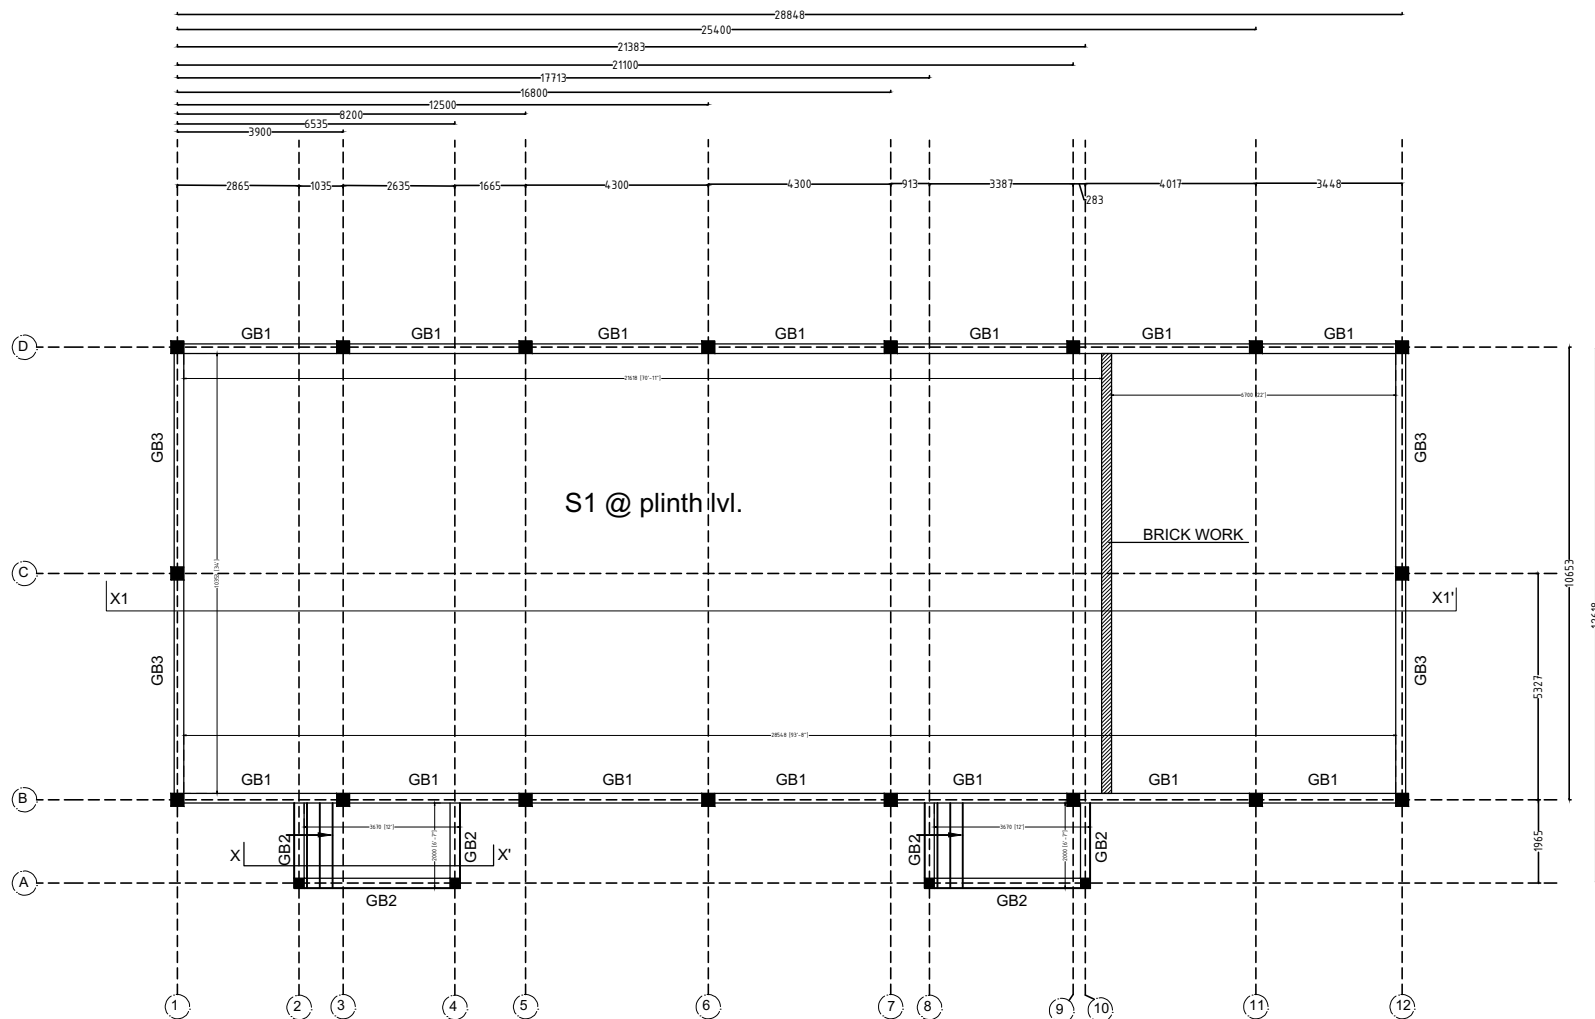

GROUND BEAM PLAN

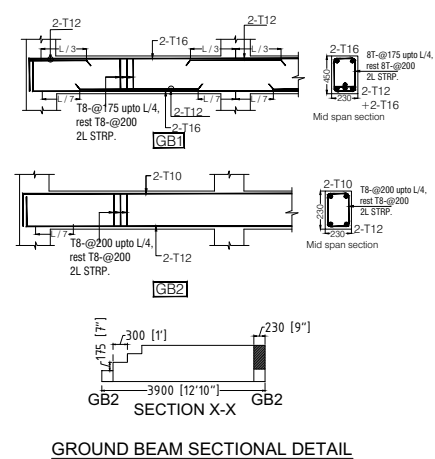


GROUND BEAM SECTIONAL DETAIL

GENERAL NOTES

NOTES-

 1. USE - M 20 GRADE OF CONC. AS/IS 426-5000
 2. USE - FE 500 GRADE OF REINF. BY CLIENT
 3. PROVIDE CLEAR COVER TO MAIN REINF.
- FOUNDATION- 50MM
COLUMN - 40MM
BEAM - 25MM
SLAB - 20MM OR DIA OF BAR, WHICHEVER IS MORE,
R.C.C. WALL - 25MM
4. TIES SHOULD BE BEND INSIDE WITH 10# LENGTH IN BEAM & COLUMN



5. FOLLOW - IS-456-2000 FOR R.C.C. WORK
6. STRIPPING TIME FOR SHUTTERING / FORMWORK UNDER NORMAL CONDITION.

TYPE OF WORK	MINIMUM PERIOD BEFORE STRIKING FORM WORK
--------------	--

- a) VERTICAL FORMWORK TO COLUMN, WALLS, BEAM 16-24 HOUR
- b) SOFFITS FORMWORK TO SLABS (PROPS TO BE REFIXED- IMMEDIATELY AFTER REMOVAL OF FORMWORK) 3 DAYS
- c) SOFFIT FORMWORK TO BEAMS (PROPS TO BE REFIXED IMMEDIATELY AFTER REMOVAL OF FORMWORK) 7DAYS
- d) PROPS TO SLABS:
 - 1) SPANNING UP TO 4.5M 7DAYS
 - 2) SPANNING OVER 4.5M 14 DAYS
- e) PROPS TO BEAMS & ARCHES:
 - 1) SPANNING UP TO 6M 14DAYS
 - 2) SPANNING OVER 6M 21DAYS

7. CURING FOR R.C.C. MEMBER MINIMUM 14 DAYS CONTINUOUSLY PREFERABLE - 28 DAYS.
8. START EARLY CURING TO AVOID SRINKAGE CRACKS, WHEN CONCRETE APPEARS TO HARDEN.
- 9) PROVIDE FOLLOWING SLUMP IN CONCRETE GENERALLY.
 - a) SHALLOW SECTIONS, PAYMENTS, MASS CONC. LIGTH REINFORCEMENT SECTION IN SLAB, BEAM, WALL, COLUMN 25-75
 - b) HEAVILY REINFORCEMENT SECTION IN SLAB 50-100
 - c) HEAVILY REINFORCEMENT SECTION IN BEAMS, WALLS, COLUMNS SLIPFORM, OR PUMPED CONC. 75-100
 - d) TRENCH FILL, PILLING, PUMPED CONC. 100-150
- 10) PROVIDE LAP/ DEVELOPEMENT LENGTH IN REINFORCEMENT BARS GRADE OF CONC.
 - M20- 47Ø
 - M25-41Ø
 - M30-38Ø
- 11) REFER RELEVANT DRG. WITH THIS DRG.
- 12) AVOID CORE CUTING.

BEAM SCHEDULE FOR GROUND/ PLINTH LVL.


BEAM	SECTION	TOP	BOTTOM	LEFT	RIGHT	REINFORCEMENT	REMARKS
GB1	230X375	2-T16	2-T12	2-T16	2-T12	2-T12	T8 @200C/C T8 @175C/C T8 @175C/C SLAB THK. INCLUDED
GB2	230X230	2-T12	-	2-T10	-	-	T8 @200C/C T8 @200C/C T8 @200C/C SLAB THK. INCLUDED

SLAB SCHEDULE FOR GROUND FLOOR LVL.


SLAB NAME	THICKNESS (mm)	Main Steel	Other Steel	remarks
S1	150 (MESH)	T8 @ 200 c/c	T8 @ 200 c/c	All straight

DRG NO: DP0001 DRG CL 01 106	SHEET NO: 5 OF 9	REV. R0	SCALE: NTS	SWATI Architecture landscape interior ARCHITECTS PLANERS ENGINEERING INTERIOR DESIGN 282 , tulip , A block , Talpuri International colony , Bhilai , C.G. Email - swati.arch@outlook.com		
DESIGNED: UPENDRA SINGH	DRAWN: SIMRAN SONI	CHECKED: UPENDRA SINGH	VERIFIED: ADMIN		APPROVED: ADMIN	
ISSUED FOR: TENDOR PURPOSE				UNIT: MILIMETER	DATE: 12.05.2022	CLIENT: CHHATTISGARH STATE MINOR FOREST PRODUCE
						PROJECT: INCUBATION CENTER AT DEOBHOG GARIYABAND
						TITLE: PULSE MILLING UNIT BEAM LAYOUT

This drawing is the property of HUP DESIGN and is to be used only for the purpose for which it was lent and must not be in any way detrimental to the interest of the company and is subject to return on demand

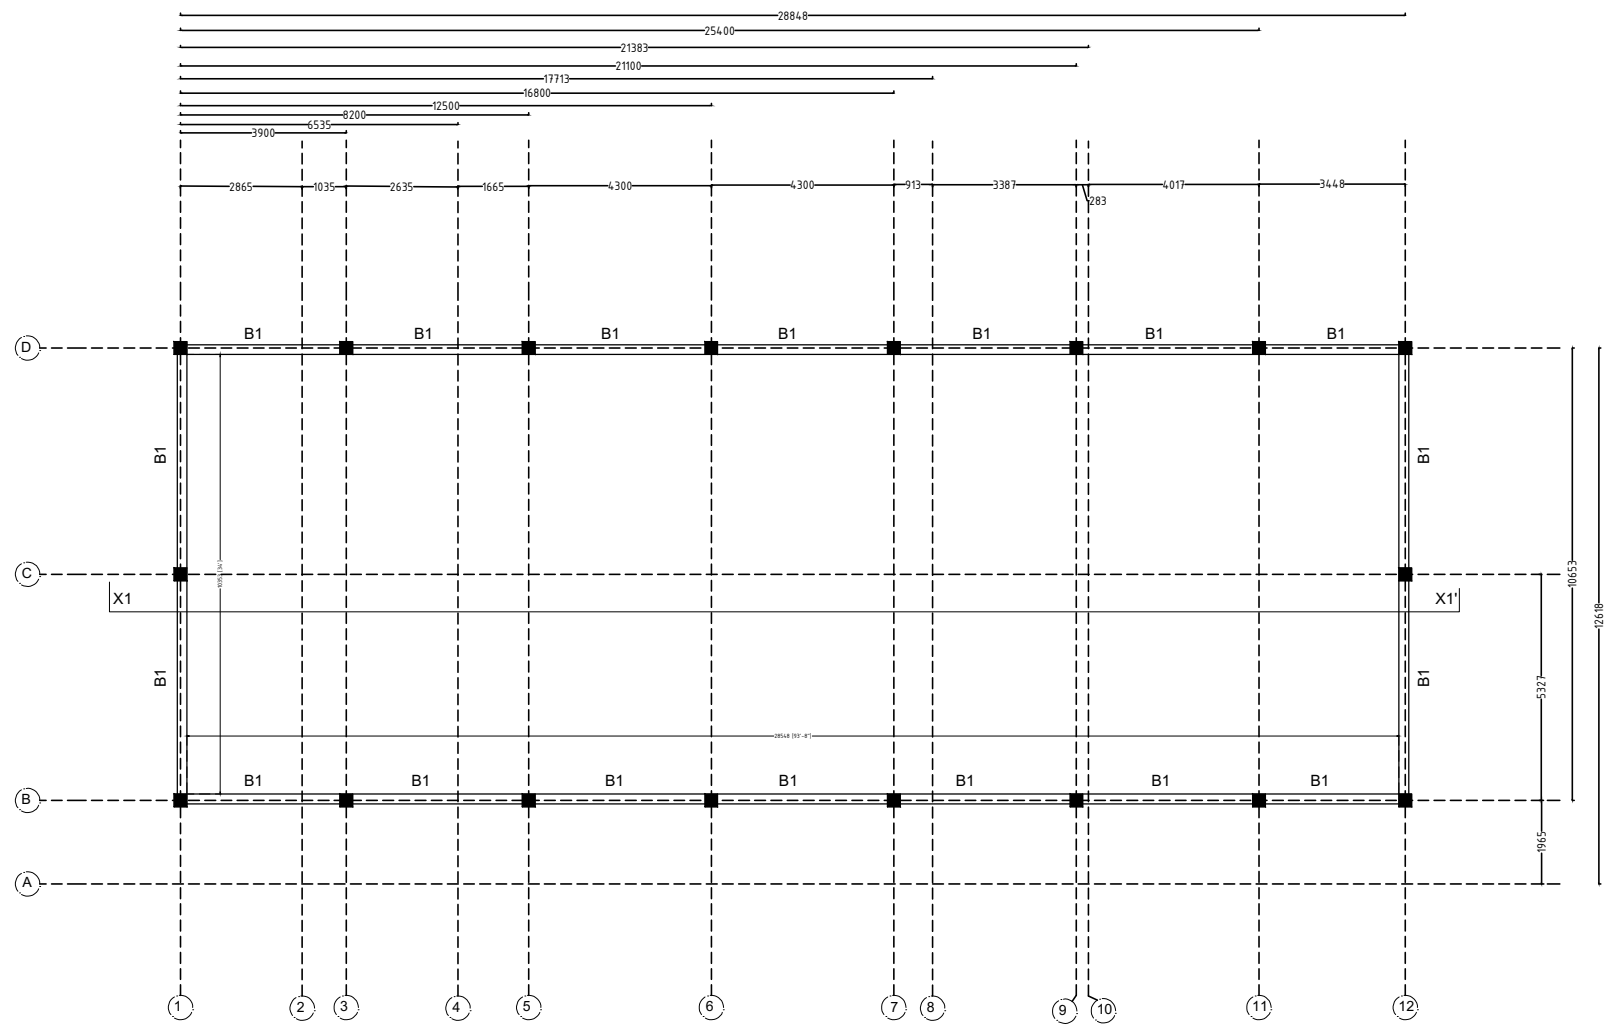

BEAM PLAN (4.5 ABOVE PLINTH LVL)

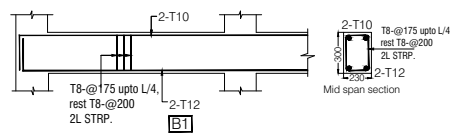


BEAM SCHEDULE FOR 4.5m LVL. ABOVE PLINTH

Beam ID	Size	Top Bar	Bottom Bar	Stirrup	Notes
B1	230X300	2-T12	-	2-T10	-

GENERAL NOTES

NOTES-

 - USE - M 20 GRADE OF CONC. AS/IS 426-5000
 - USE - FE 500 GRADE OF REINF. BY CLIENT
 - PROVIDE CLEAR COVER TO MAIN REINF.
- FOUNDATION- 50MM
COLUMN - 40MM
BEAM - 25MM
SLAB - 20MM OR DIA OF BAR, WHICHEVER IS MORE,
R.C.C. WALL - 25MM
- TIES SHOULD BE BEND INSIDE WITH 10# LENGTH IN BEAM & COLUMN



- FOLLOW - IS-456-2000 FOR R.C.C. WORK
- STRIPPING TIME FOR SHUTTERING / FORMWORK UNDER NORMAL CONDITION.

TYPE OF WORK	MINIMUM PERIOD BEFORE STRIKING FORM WORK
--------------	--

- VERTICAL FORMWORK TO COLUMN, WALLS, BEAM 16-24 HOUR
- SOFFITS FORMWORK TO SLABS (PROPS TO BE REFIXED- IMMEDIATELY AFTER REMOVAL OF FORMWORK) 3 DAYS
- SOFFIT FORMWORK TO BEAMS (PROPS TO BE REFIXED IMMEDIATELY AFTER REMOVAL OF FORMWORK) 7DAYS
- PROPS TO SLABS:
 - 1) SPANNING UP TO 4.5M 7DAYS
 - 2) SPANNING OVER 4.5M 14 DAYS
- PROPS TO BEAMS & ARCHES:
 - 1) SPANNING UP TO 6M 14DAYS
 - 2) SPANNING OVER 6M 21DAYS

- CURING FOR R.C.C. MEMBER MINIMUM 14 DAYS CONTINUOUSLY PREFERABLE - 28 DAYS.
- START EARLY CURING TO AVOID SRINKAGE CRACKS, WHEN CONCRETE APPEARS TO HARDEN.
- PROVIDE FOLLOWING SLUMP IN CONCRETE GENERALLY.

- SHALLOW SECTIONS, PAYMENTS, MASS CONC. LIGHT REINFORCEMENT SECTION IN SLAB, BEAM, WALL, COLUMN 25-75
 - HEAVILY REINFORCEMENT SECTION IN SLAB 50-100
 - HEAVILY REINFORCEMENT SECTION IN BEAMS, WALLS, COLUMNS SLIPFORM, OR PUMPED CONC. 75-100
 - TRENCH FILL, PILLING, PUMPED CONC. 100-150
- PROVIDE LAP/ DEVELOPEMENT LENGTH IN REINFORCEMENT BARS GRADE OF CONC.

- REFER RELEVANT DRG. WITH THIS DRG.
- AVOID CORE CUTING.

DRG NO:
DP0001 DRG CL 01 106

SHEET NO:
7 OF 9

REV.
R0

SCALE:
NTS

DESIGNED:
UPENDRA SINGH

DRAWN:
SIMRAN SONI

CHECKED:
UPENDRA SINGH

VERIFIED:
ADMIN

APPROVED:
ADMIN

ISSUED FOR:
TENDOR PURPOSE

UNIT:
MILIMETER

DATE:
12.05.2022

CLIENT:
CHHATTISGARH STATE MINOR FOREST PRODUSE

PROJECT:
INCUBATION CENTER AT DEOBHOG GARIYABAND

TITLE:
PULSE MILLING UNIT
BEAM LAYOUT

 
SWATI Architecture landscape interior
ARCHITECTS I PLANERS I ENGINEERING I INTERIOR DESIGN
282 , tulip , A Block , Talpuri International colony , Bhilai , C.G. Email - swati.arch@outlook.com

52

GENERAL NOTES

NOTES-

1. USE - M 20 GRADE OF CONC. AS/IS 426-5000
 2. USE - FE 500 GRADE OF REINF. BY CLIENT
 3. PROVIDE CLEAR COVER TO MAIN REINF.
- FOUNDATION- 50MM
COLUMN - 40MM
BEAM - 25MM
SLAB - 20MM OR DIA OF BAR, WHICHEVER IS MORE,
R.C.C. WALL - 25MM
- 4.TIES SHOULD BE BEND INSIDE WITH 10# LENGTH IN BEAM & COLUMN



- 5.FOLLOW - IS-456-2000 FOR R.C.C. WORK
- 6.STRIPPING TIME FOR SHUTTERING / FORMWORK UNDER NORMAL CONDITION.

TYPE OF WORK	MINIMUM PERIOD BEFORE STRIKING FORM WORK
--------------	--


- | | |
|--|------------|
| a) VERTICAL FORMWORK TO COLUMN, WALLS, BEAM | 16-24 HOUR |
| b) SOFFITS FORMWORK TO SLABS (PROPS TO BE REFIXED- IMMEDIATELY AFTER REMOVAL OF FORMWORK) | 3 DAYS |
| c) SOFFIT FORMWORK TO BEAMS (PROPS TO BE REFIXED IMMEDIATELY AFTER REMOVAL OF FORMWORK) | 7DAYS |
| d) PROPS TO SLABS: | |
| 1) SPANNING UP TO 4.5M | 7DAYS |
| 2) SPANNING OVER 4.5M | 14 DAYS |
| e) PROPS TO BEAMS & ARCHES: | |
| 1) SPANNING UP TO 6M | 14DAYS |
| 2) SPANNING OVER 6M | 21DAYS |

7. CURING FOR R.C.C. MEMBER MINIMUM 14 DAYS CONTINUOUSLY PREFERABLE - 28 DAYS.
8. START EARLY CURING TO AVOID SRINKAGE CRACKS, WHEN CONCRETE APPEARS TO HARDEN.
- 9) PROVIDE FOLLOWING SLUMP IN CONCRETE GENERALLY.


- | | |
|--|---------|
| a) SHALLOW SECTIONS, PAYMENTS, MASS CONC. LGTH REINFORCEMENT SECTION IN SLAB, BEAM, WALL, COLUMN | 25-75 |
| b) HEAVY REINFORCEMENT SECTION IN SLAB | 50-100 |
| c) HEAVY REINFORCEMENT SECTION IN BEAMS, WALLS, COLUMNS SLIPFORM, OR PUMPED CONC. | 75-100 |
| d) TRENCH FILL, PILLING, PUMPED CONC. | 100-150 |
| 10) PROVIDE LAP/ DEVELOPEMENT LENGTH IN REINFORCEMENT BARS GRADE OF CONC. | |

M20- 47Ø
M25-41Ø
M30-38Ø


- 11) REFER RELEVANT DRG. WITH THIS DRG.
- 12) AVOID CORE CUTING.

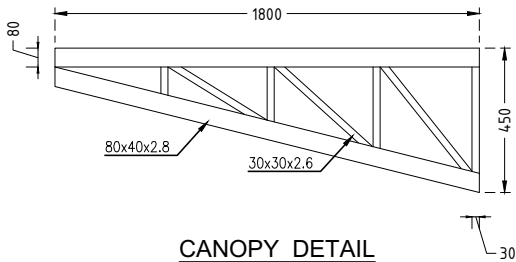


CANOPY DETAIL

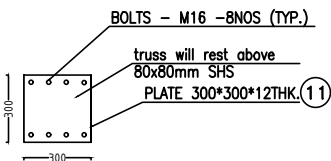

DETAIL 1

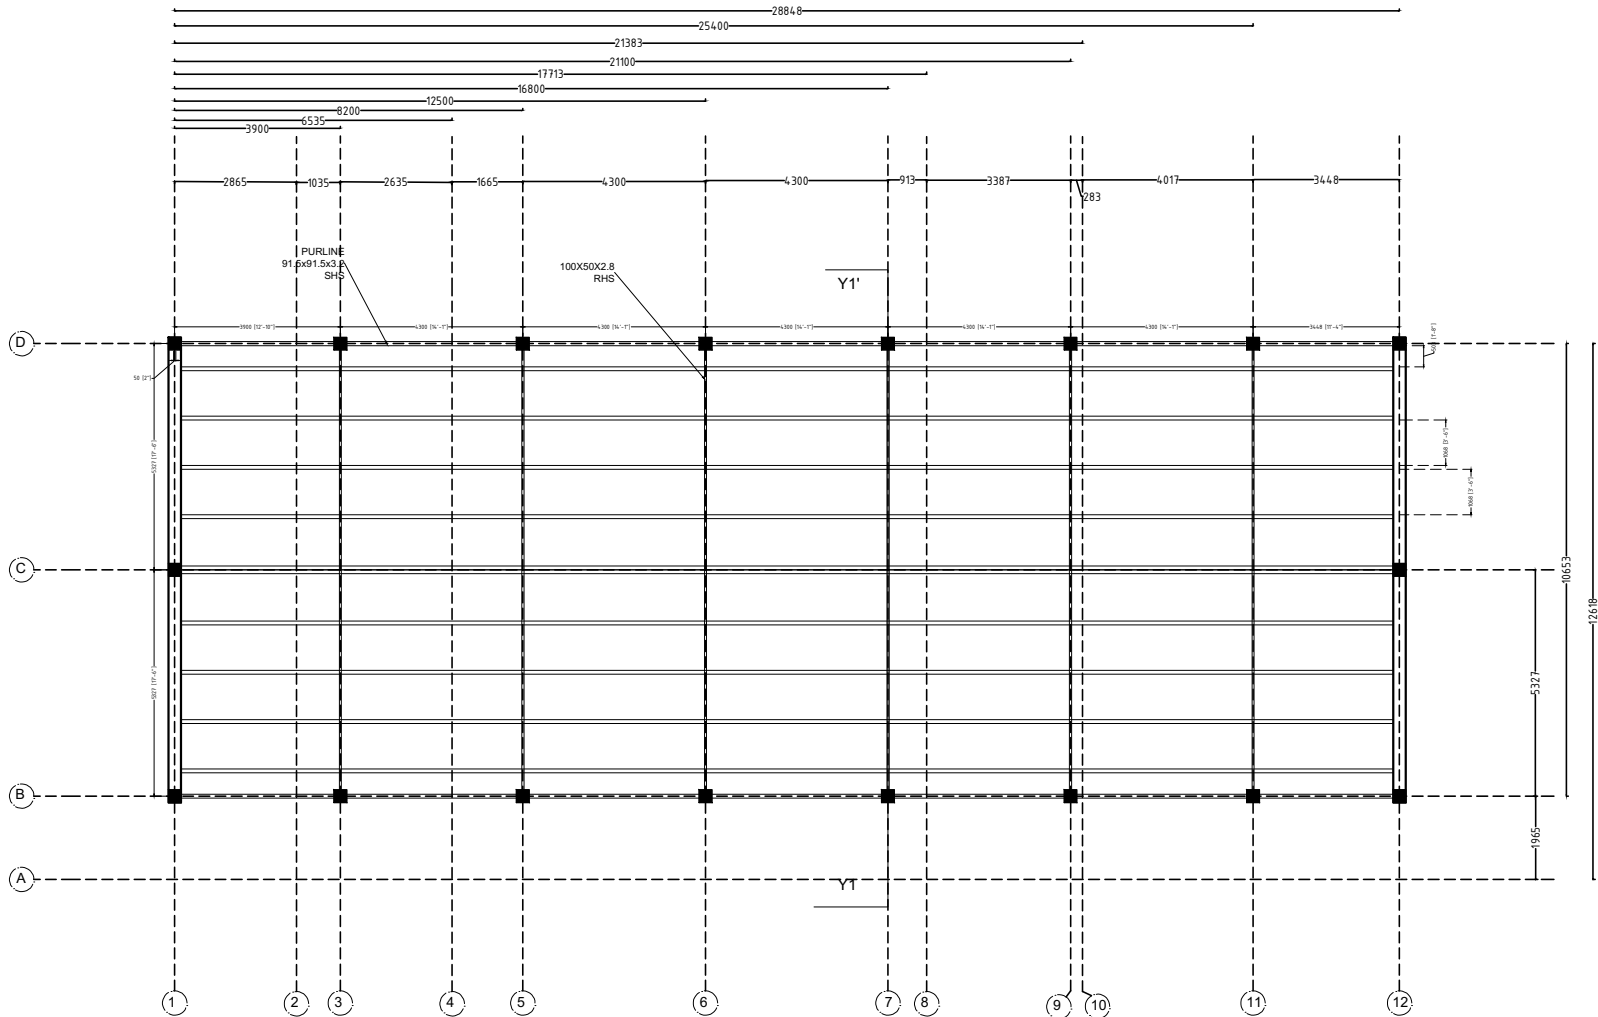


PLAN OF ROOF LVL.

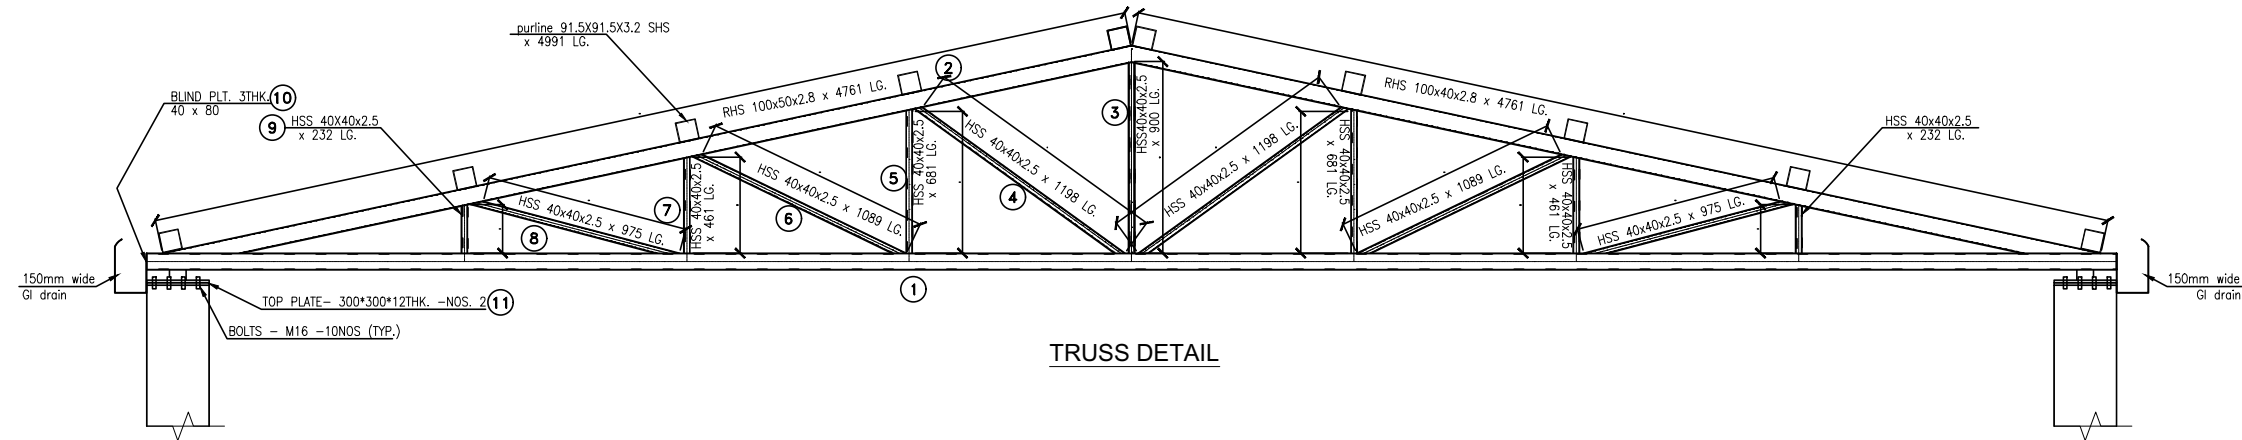


TRUSS DETAIL


DRG NO: DP0001 DRG CL 01 106		SHEET NO: 8 OF 9	REV. R0	SCALE: NTS	SWATI Architecture landscape interior ARCHITECTS PLANERS ENGINEERING INTERIOR DESIGN 282 , tulip , A block , Talpuri International colony , Bhilai , C.G. Email - swati.arch@outlook.com	
DESIGNED:	DRAWN:	CHECKED:	VERIFIED:	APPROVED:		CLIENT:
UPENDRA SINGH	SIMRAN SONI	UPENDRA SINGH	ADMIN	ADMIN		CHHATTISGARH STATE MINOR FOREST PRODUSE
ISSUED FOR: TENDOR PURPOSE		UNIT: MILIMETER	DATE: 12.05.2022	PROJECT:		INCUBATION CENTER AT DEOBHOG GARIYABAND
This drawing is the property of HUP DESIGN and is to be used only for the purpose for which it was lent and must not be in any way detrimental to the interest of the company and is subject to return on demand					TITLE: PULSE MILLING UNIT TRUSS LAYOUT 53	

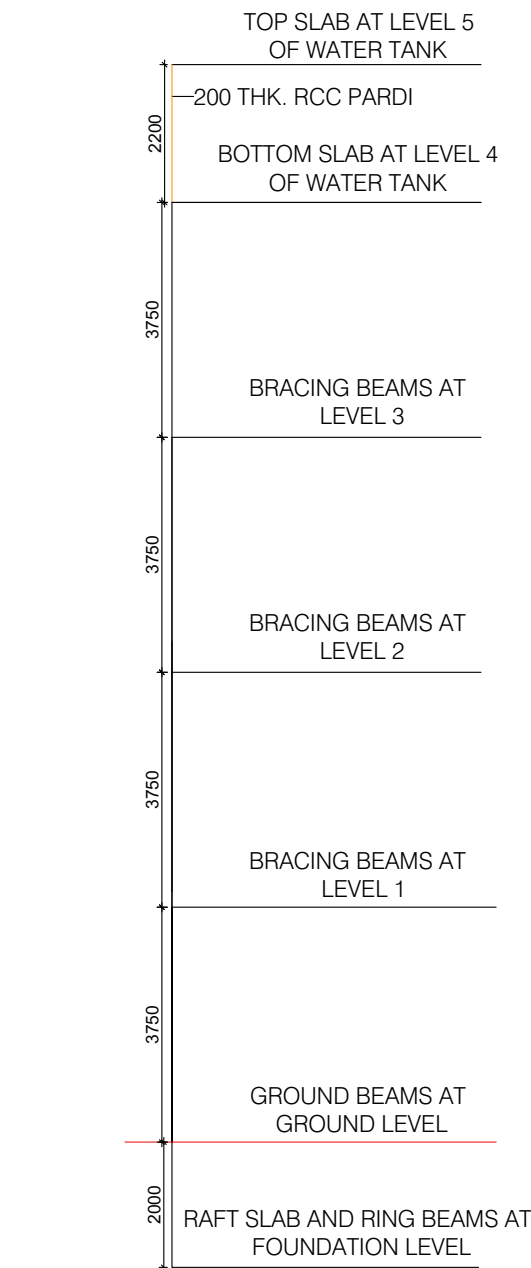


CROSSSECTIONAL PLAN AT DIFFERENT LVL.

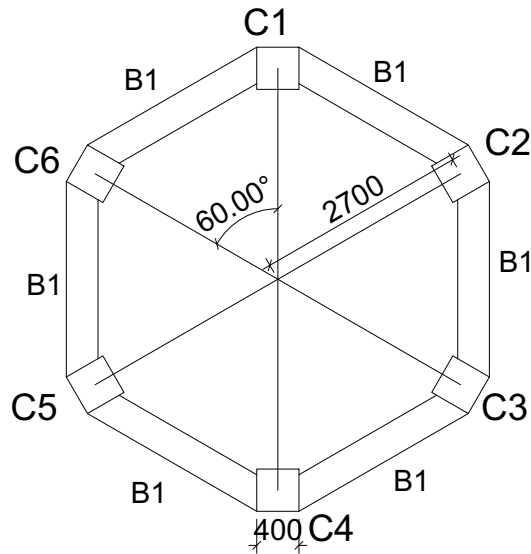


TYPICAL STRAIGHT BEAM, COLUMN PLAN
@ 1,2,3 LEVEL

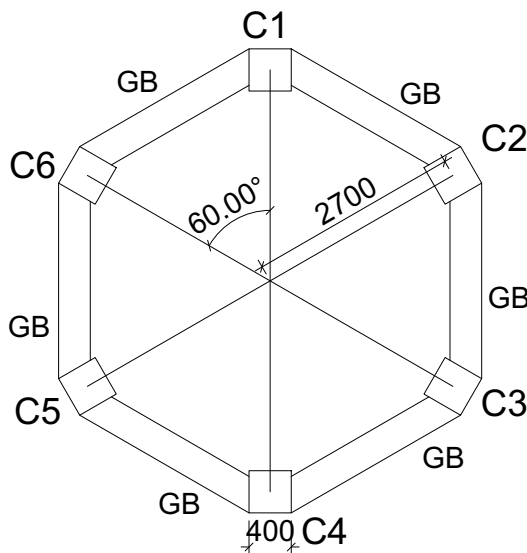


TYPICAL STRAIGHT BEAM, COLUMN PLAN
@ GROUND LEVEL

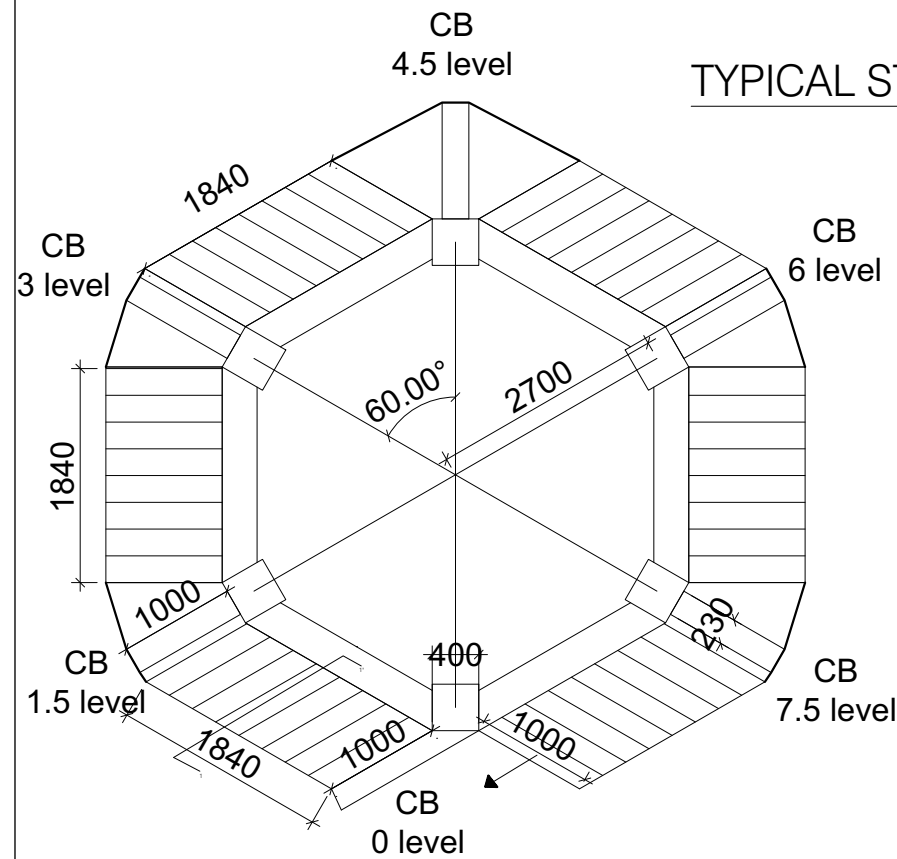


TYPICAL CANTILEVER BEAM, LANDING SLAB
AND STAIR @ DIFFERENT LEVELS

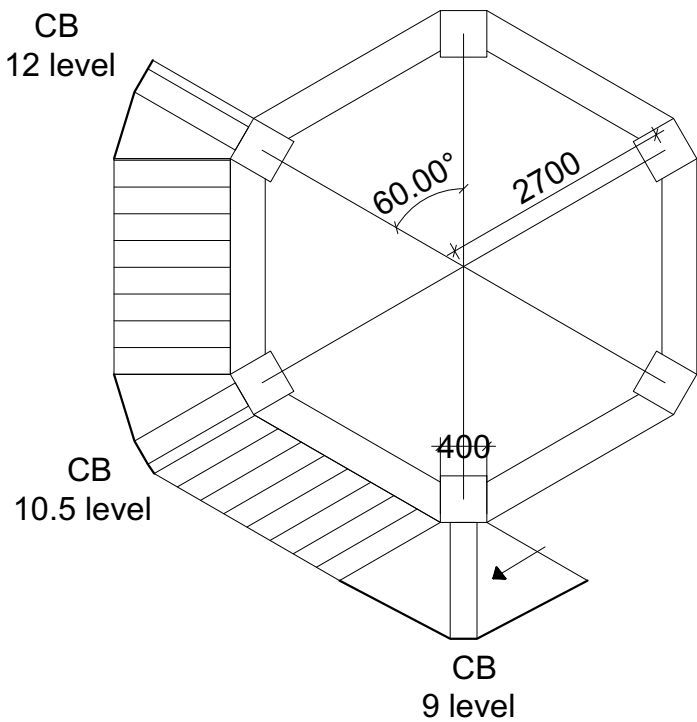


BEAM	BEAM SIZE	BOTTOM REINFORCEMENT		TOP REINFORCEMENT			STIRUPS			REMARKS
		BOTTOM STRAIGHT	CURTAIL	TOP STRAIGHT	LEFT EXTRA	RIGHT EXTRA	LEFT	RIGHT	CENTER	
B1	300X450	3-T20	-	3-T20	-	-	T8 @100C/C	T8 @100C/C	T8 @150C/C	STRAIGHT BEAM, BRACING AT LEVEL 1,2,3 ONLY
GB	300X450	3-T16	-	3-T16	-	-	T8 @150C/C	T8 @150C/C	T8 @150C/C	STRAIGHT GROUND BEAM

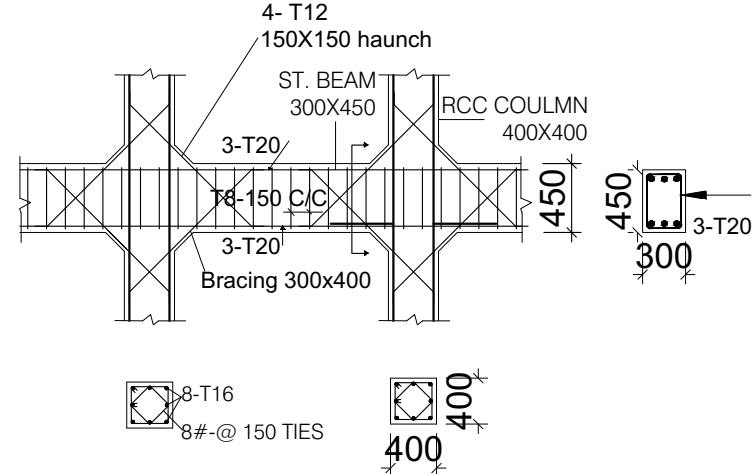

LONGITUDINAL SECTION OF BEAM (B1)
@1,2 LEVEL

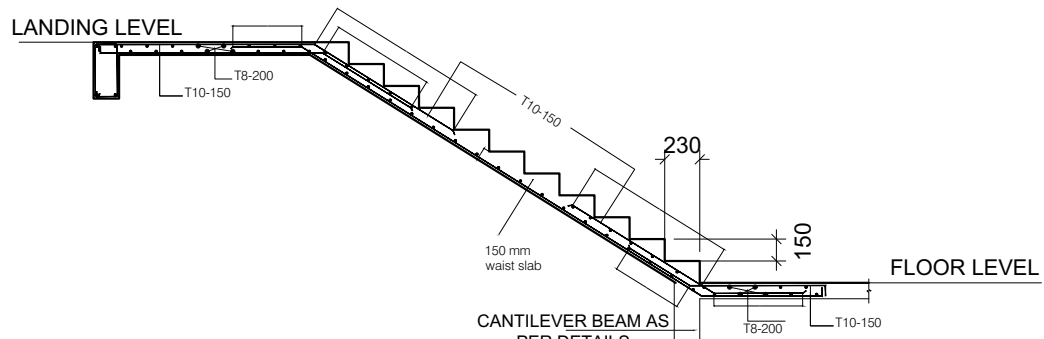

TYPICAL SECTION AT 1-1'

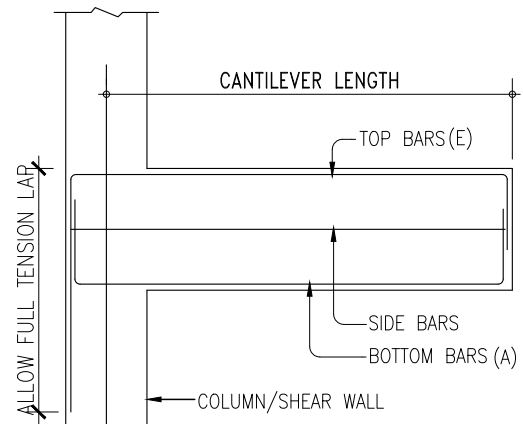

TYPICAL CANTILEVER BEAM DETAIL

BEAM	BEAM SIZE	BOTTOM REINFORCEMENT		TOP REINFORCEMENT			STIRUPS			REMARKS
		BOTTOM STRAIGHT	CURTAIL	TOP STRAIGHT	LEFT EXTRA	RIGHT EXTRA	LEFT	RIGHT	CENTER	
CB	230X375	2-T12	-	2-T16	-	-	T8 @150C/C	T8 @150C/C	T8 @150C/C	CANTILEVER BEAM including SLAB THK.


DRG NO: DP0001 DRG CL 01 801		SHEET NO: 1 OF 3		REV. R0		SCALE: NTS		SWATI Architecture landscape interior ARCHITECTS PLANERS ENGINEERING INTERIOR DESIGN 282 , tulip , A block , Talpuri International colony , Bhilai , C.G. Email - swati.arch@outlook.com							
DESIGNED:		DRAWN:		CHECKED:		VERIFIED:		APPROVED:		CLIENT:					
UPENDRA SINGH		SIMRAN SONI		UPENDRA SINGH		ADMIN		ADMIN		CHHATTISGARH STATE MINOR FOREST PRODUCE					
ISSUED FOR:				UNIT:		DATE:		PROJECT:							
TENDOR PURPOSE				MILIMETER		12.05.2022		INCUBATION CENTER AT DEOBHOG GARIYABAND							
This drawing is the property of HUP DESIGN and is to be used only for the purpose for which it was lent and must not be in any way detrimental to the interest of the company and is subject to return on demand								TITLE: OVER HEAD WATER TANK 55							

GENERAL NOTES

NOTES-

1. USE M-20 (1:1.5:3) GRADE OF CONC.AS/ IS 456-2000
2. USE - FE 500 GRADE OF REINF. AS/ IS-1786/TMT BARS
3. PROVIDE CLEAR COVER TO MAIN REINF.

FOUNDATION- 50MM
COLUMN - 40MM
BEAM - 25MM
SLAB - 15MM OR DIA OF BAR, WHICHEVER IS MORE,
R.C.C. WALL - 25MM
4.TIES SHOULD BE BEND INSIDE WITH 10# LENGTH
IN BEAM & COLUMN

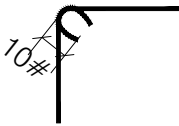

- 5.FOLLOW - IS-456-2000 FOR R.C.C. WORK
- 6.STRIPPING TIME FOR SHUTTERING / FORMWORK UNDER NORMAL CONDITION.

TYPE OF WORK MINIMUM PERIOD BEFORE STRIKING FORM WORK


- a) VERTICAL FORMWORK TO COLUMN, WALLS, BEAM 16-24 HOUR
- b) SOFFITS FORMWORK TO SLABS (PROPS TO BE REFIXED- IMMEDIATELY AFTER REMOVAL OF FORMWORK) 3 DAYS
- c) SOFFIT FORMWORK TO BEAMS (PROPS TO BE REFIXED IMMEDIATELY AFTER REMOVAL OF FORMWORK) 7DAYS
- d) PROPS TO SLABS:
 - 1) SPANNING UP TO 4.5M 7DAYS
 - 2) SPANNING OVER 4.5M 14 DAYS
- e) PROPS TO BEAMS & ARCHES:
 - 1) SPANNING UP TO 6M 14DAYS
 - 2) SPANNING OVER 6M 21DAYS

7. CURING FOR R.C.C. MEMBER MINIMUM 14 DAYS CONTINUOUSLY PREFERABLE - 28 DAYS.
8. START EARLY CURING TO AVOID SRINKAGE CRACKS, WHEN CONCRETE APPEARS TO HARDEN.
- 9) PROVIDE FOLLOWING SLUMP IN CONCRETE GEN-ERALLY.


- a) SHALLOW SECTIONS, PAYMENTS, MASS CONC. LIGTH REINFORCEMENT SECTION IN SLAB, BEAM, WALL, COLUMN 25-75
- b) HEAVILY REINFORCEMENT SECTION IN SLAB 50-100
- c) HEAVILY REINFORCEMENT SECTION IN BEAMS, WALLS, COLUMNS SLIPFORM, OR PUMPED CONC. 75-100
- d) TRENCH FILL, PILLING, PUMPED CONC. 100-150
- 10) PROVIDE LAP/ DEVELOPEMENT LENGTH IN REINFORCEMENT BARS GRADE OF CONC.

M20- 47Ø
M25-41Ø
M30-38Ø


- 11) REFER RELEVANT DRG. WITH THIS DRG.

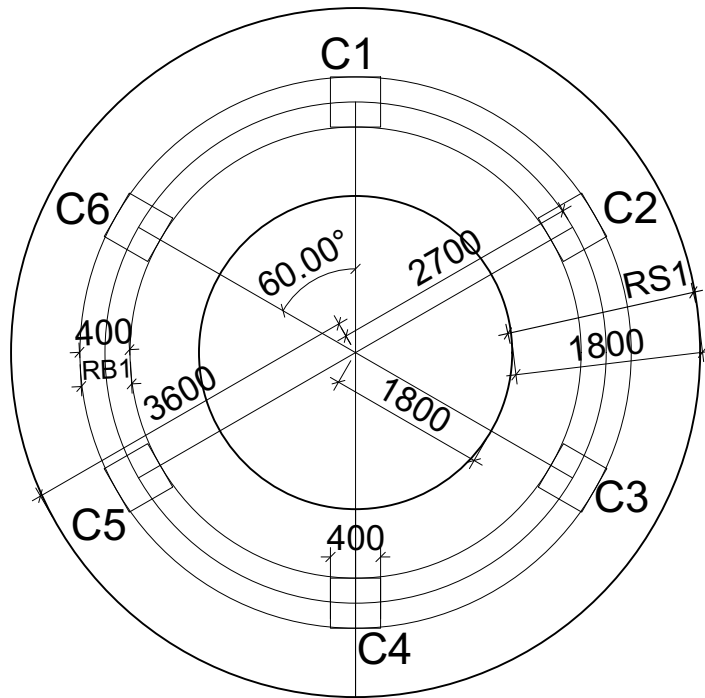

TYPICAL RAFT SLAB, RING BEAM, COLUMN PLAN
@ FOUNDATION LEVEL

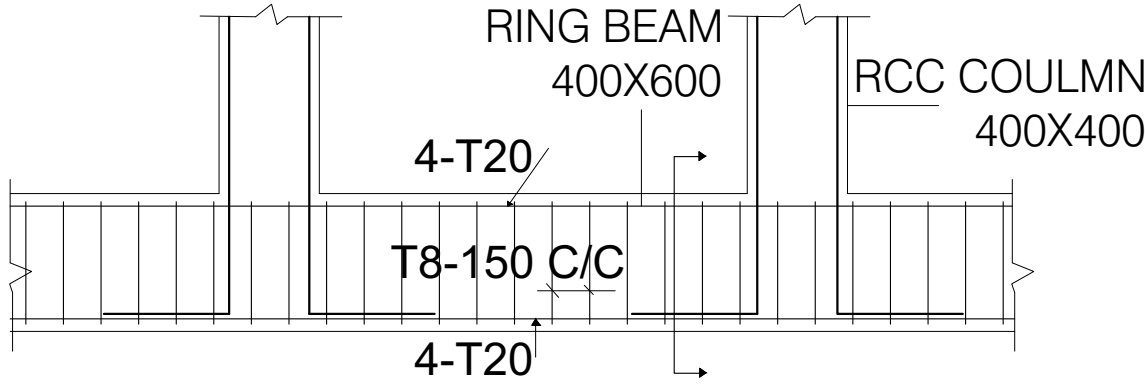

LONGITUDINAL SECTION OF RING BEAM
@FOUNDATION LEVEL

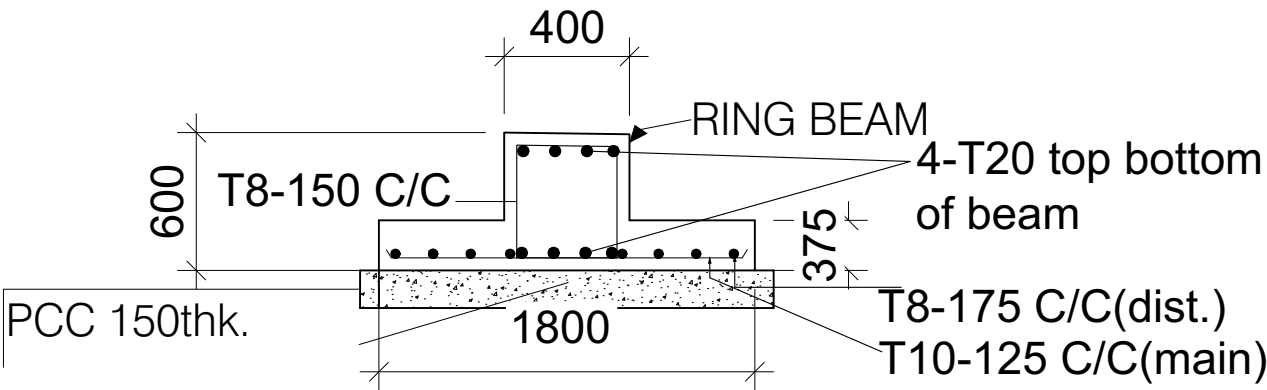

SECTION @ X-X @ FOUNDATION LEVEL

S.NO	COLUMN TYPE	GROUND FLOOR	FIRST FLOOR	SECOND FLOOR	THIRD FLOOR
1.	C1 TO C6	400 400 8-T16 8#-@ 150 TIES	400 400 8-T16 8#-@ 150 TIES	400 400 8-T16 8#-@ 150 TIES	400 400 8-T16 8#-@ 150 TIES

Footing	Column	PCC Size	Footing Size	Column size	Total	Column	Stirups
	Nos				Depth mm	Steel	
RS1	C1,C2,C3, C4,C5,C6	1800 WIDE CIRCULAR	1500 WIDE CIRCULAR	400x400 mm	375	8-T16	T8 - 150 c/c


BEAM	BEAM SIZE	BOTTOM REINFORCEMENT		TOP REINFORCEMENT			STIRUPS			REMARKS
		THROUGHTOUT	CURTAIL	TOP FULL	LEFT	RIGHT	LEFT	RIGHT	CENTER	
RB1	400X600	4-T20	-	4-T20	-	-	T8 @150C/C	T8 @150C/C	T8 @150C/C	FOUNDATION RING BEAM

DRG NO: DP0001 DRG CL 01 801		SHEET NO: 2 OF 3	REV. R0	SCALE: NTS	SWATI Architecture landscape interior ARCHITECTS PLANERS ENGINEERING INTERIOR DESIGN 282 , tulip , A block , Talpuri International colony , Bhilai , C.G. Email - swati.arch@outlook.com	
DESIGNED:	DRAWN:	CHECKED:	VERIFIED:	APPROVED:		CLIENT:
UPENDRA SINGH	SIMRAN SONI	UPENDRA SINGH	ADMIN	ADMIN		CHHATTISGARH STATE MINOR FOREST PRODUSE
ISSUED FOR: TENDOR PURPOSE		UNIT: MILIMETER	DATE: 12.05.2022	PROJECT:		INCUBATION CENTER AT DEOBHOG GARIYABAND
This drawing is the property of HUP DESIGN and is to be used only for the purpose for which it was lent and must not be in any way detrimental to the interest of the company and is subject to return on demand					TITLE: OVER HEAD WATER TANK 56	

This drawing is the property of HUP DESIGN and is to be used only for the purpose for which it was lent and must not be in any way detrimental to the interest of the company and is subject to return on demand

GENERAL NOTES





- NOTES-
- USE M-20 (1:1.5:3) GRADE OF CONC.AS/ IS 456-2000
 - USE - FE 500 GRADE OF REINF. AS/ IS-1786/TMT BARS
 - PROVIDE CLEAR COVER TO MAIN REINF.
- FOUNDATION- 50MM
 COLUMN - 40MM
 BEAM - 25MM
 SLAB - 15MM OR DIA OF BAR, WHICHEVER IS MORE,
 R.C.C. WALL - 25MM
- 4.TIES SHOULD BE BEND INSIDE WITH 10# LENGTH IN BEAM & COLUMN

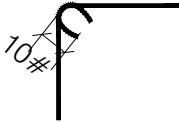


- 5.FOLLOW - IS-456-2000 FOR R.C.C. WORK
- 6.STRIPPING TIME FOR SHUTTERING / FORMWORK UNDER NORMAL CONDITION.

TYPE OF WORK	MINIMUM PERIOD BEFORE STRIKING FORM WORK
a) VERTICAL FORMWORK TO COLUMN, WALLS, BEAM	16-24 HOUR
b) SOFFITS FORMWORK TO SLABS (PROPS TO BE REFIXED- IMMEDIATELY AFTER REMOVAL OF FORMWORK)	3 DAYS
c) SOFFIT FORMWORK TO BEAMS (PROPS TO BE REFIXED IMMEDIATELY AFTER REMOVAL OF FORMWORK)	7DAYS
d) PROPS TO SLABS:	
1) SPANNING UP TO 4.5M	7DAYS
2) SPANNING OVER 4.5M	14 DAYS
e) PROPS TO BEAMS & ARCHES:	
1) SPANNING UP TO 6M	14DAYS
2) SPANNING OVER 6M	21DAYS

7. CURING FOR R.C.C. MEMBER MINIMUM 14 DAYS CONTINOUSELY PREFERABLE - 28 DAYS.
8. START EARLY CURING TO AVOID SRINKAGE CRACKS, WHEN CONCRETE APPEARS TO HARDEN.
- 9) PROVIDE FOLLOWING SLUMP IN CONCRETE GEN-ERALLY.
- | | |
|---|---------|
| a) SHALLOW SECTIONS, PAVMENTS, MASS CONC. LIGTH REINFORCEMENT | 25-75 |
| SECTION IN SLAB, BEAM, WALL, COLUMN | 50-100 |
| b) HEAVILY REINFORCEMENT SECTION IN SLAB | 75-100 |
| c) HEAVILY REINFORCEMENT SECTION IN BEAMS, WALLS, COLUMNS SLIPFORM, OR PUMPED CONC. | 100-150 |
| d) TRENCH FILL, PILLING, PUMPED CONC. | 100-150 |
- 10) PROVIDE LAP/ DEVELOPEMENT LENGTH IN REINFORCEMENT BARS GRADE OF CONC.
- 11) REFER RELEVANT DRG. WITH THIS DRG.

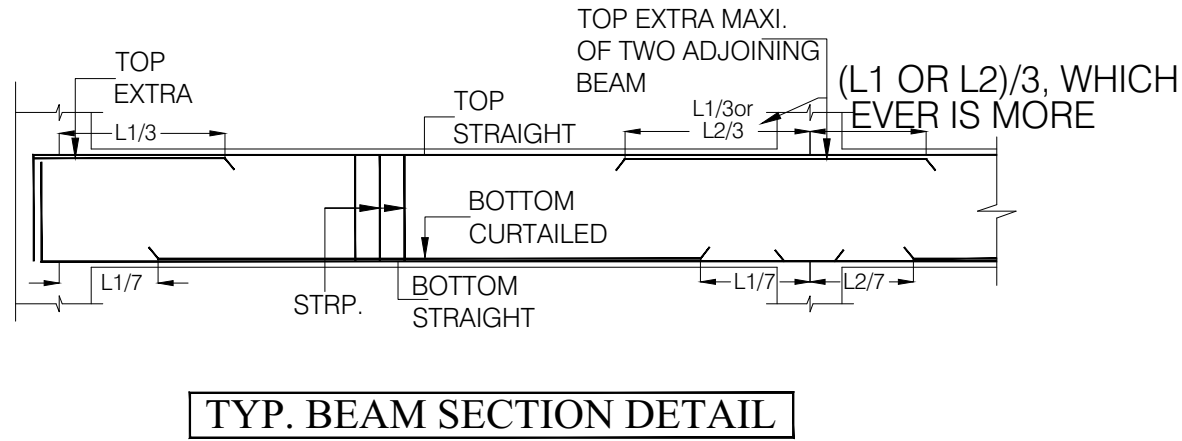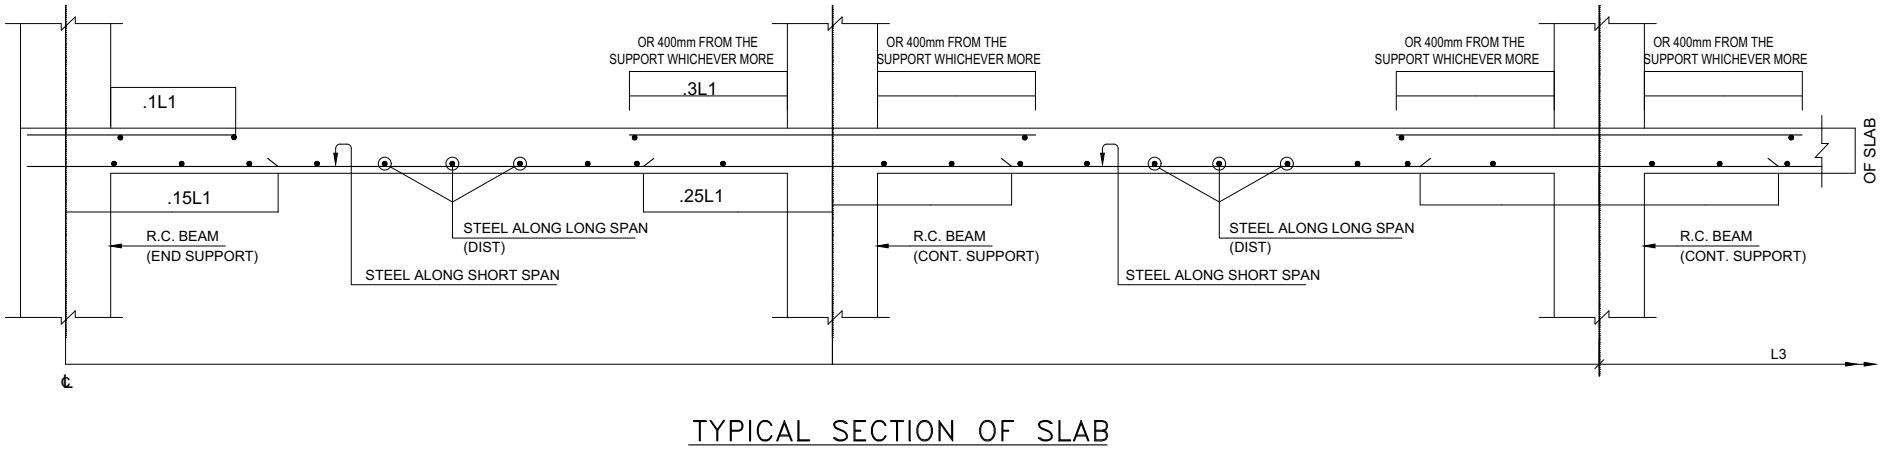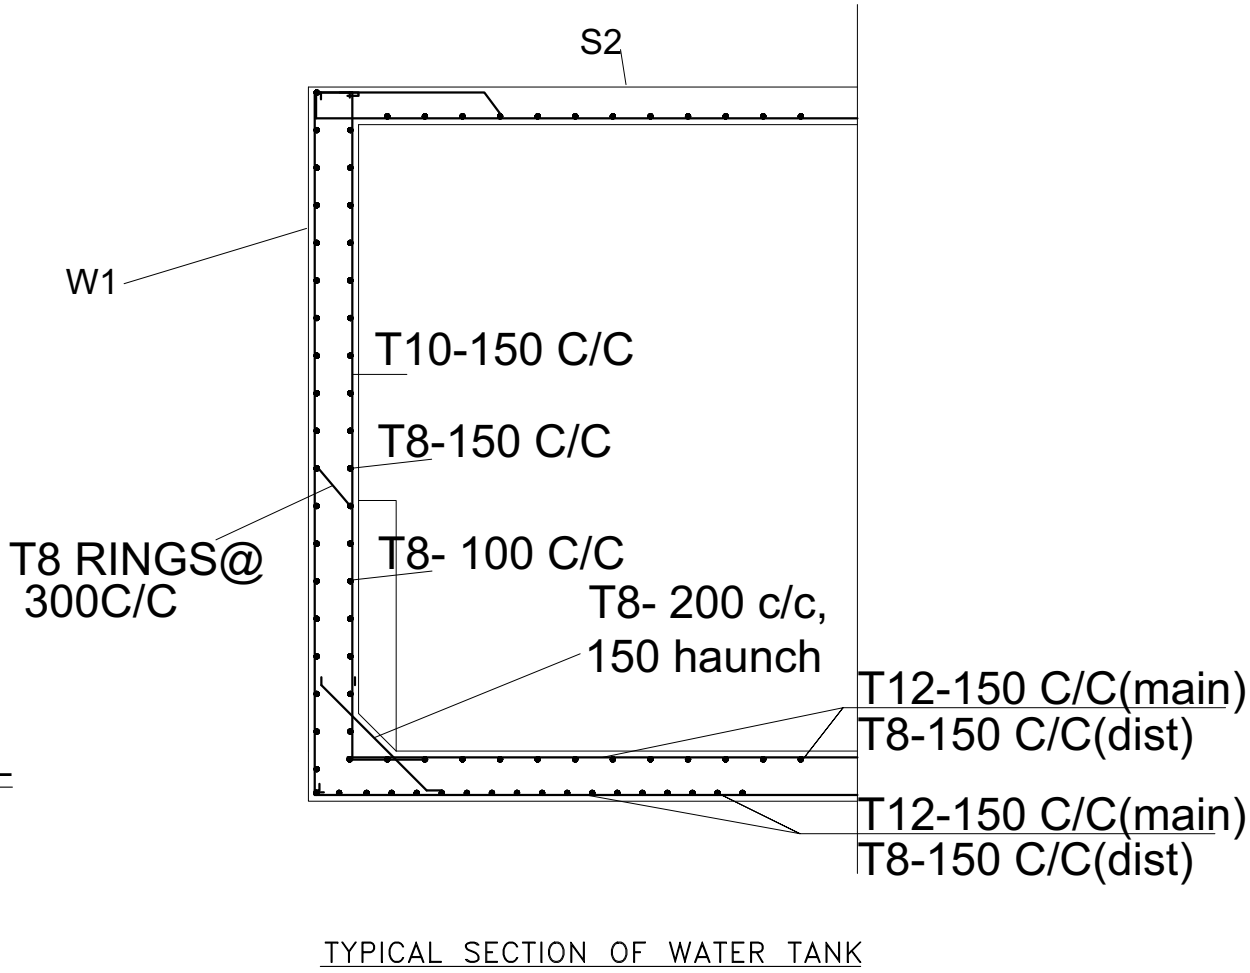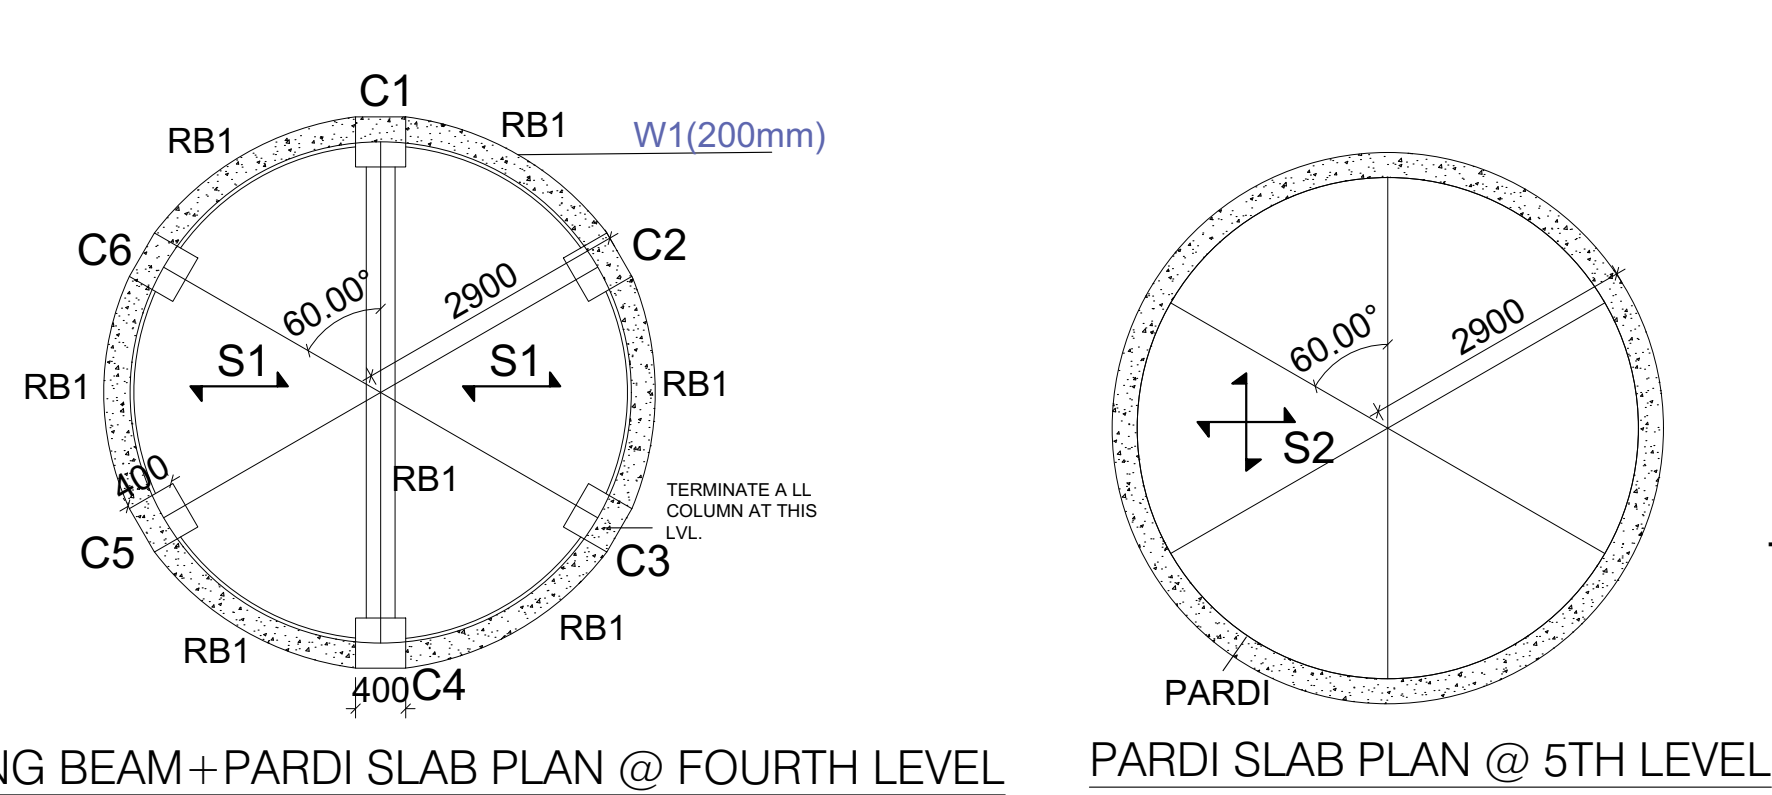

BEAM	BEAM SIZE	BOTTOM REINFORCEMENT		TOP REINFORCEMENT			STIRUPS			REMARKS
		BOTTOM STRAIGHT	CURTAIL	TOP STRAIGHT	LEFT EXTRA	RIGHT EXTRA	LEFT	RIGHT	CENTER	
RB1	230X600	3-T20	2-T16	3-T16	2-T16	2-T16	T8 @125C/C	T8 @125C/C	T8 @150C/C	SLAB THK. INCLUDED

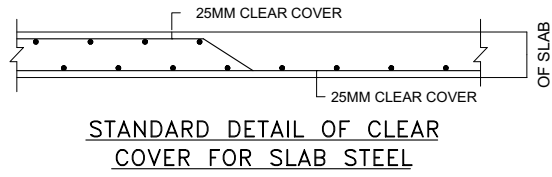


GENERAL NOTES	
NOTES-	
1. USE M-20 (1:1.5:3) GRADE OF CONC.AS/ IS 456-2000	
2. USE - FE 500 GRADE OF REINF. AS/ IS-1786/TMT BARS	
3. PROVIDE CLEAR COVER TO MAIN REINF.	
FOUNDATION- 50MM	
COLUMN - 40MM	
BEAM - 25MM	
SLAB - 15MM OR DIA OF BAR, WHICHEVER IS MORE,	
R.C.C. WALL - 25MM	
4.TIES SHOULD BE BEND INSIDE WITH 10# LENGTH IN BEAM & COLUMN	
5.FOLLOW - IS-456-2000 FOR R.C.C. WORK	
6.STRIPPING TIME FOR SHUTTERING / FORMWORK UNDER NORMAL CONDITION.	
TYPE OF WORK	MINIMUM PERIOD BEFORE STRIKING FORM WORK
a) VERTICAL FORMWORK TO COLUMN, WALLS, BEAM	16-24 HOUR
b) SOFFITS FORMWORK TO SLABS (PROPS TO BE REFIXED- IMMEDIATELY AFTER REMOVAL OF FORMWORK)	3 DAYS
c) SOFFIT FORMWORK TO BEAMS (PROPS TO BE REFIXED IMMEDIATELY AFTER REMOVAL OF FORMWORK)	7DAYS
d) PROPS TO SLABS:	
1) SPANNING UP TO 4.5M	7DAYS
2) SPANNING OVER 4.5M	14 DAYS
e) PROPS TO BEAMS & ARCHES:	
1) SPANNING UP TO 6M	14DAYS
2) SPANNING OVER 6M	21DAYS
7. CURING FOR R.C.C. MEMBER MINIMUM 14 DAYS CONTINOUSELY PREFERABLE - 28 DAYS.	
8. START EARLY CURING TO AVOID SRINKAGE CRACKS, WHEN CONCRETE APPEARS TO HARDEN.	
9) PROVIDE FOLLOWING SLUMP IN CONCRETE GEN-ERALLY.	
a) SHALLOW SECTIONS, PAVMENTS, MASS CONC. LIGTH REINFORCEMENT	25-75
b) HEAVILY REINFORCEMENT SECTION IN SLAB	50-100
c) HEAVILY REINFORCEMENT SECTION IN BEAMS, WALLS, COLUMNS SLIPFORM, OR PUMPED CONC.	75-100
d) TRENCH FILL, PILLING, PUMPED CONC.	100-150
10) PROVIDE LAP/ DEVELOPEMENT LENGTH IN REINFORCEMENT BARS GRADE OF CONC.	
	M20- 47Ø
	M25-41Ø
	M30-38Ø
11) REFER RELEVANT DRG. WITH THIS DRG.	

SLAB NAME	THICKNESS (mm)	SLAB REINFORCEMENT BOTTOM		SLAB REINFORCEMENT TOP		remarks
		Main Steel	Other Steel	Main Steel	Other Steel	
S1	200 Thk. one Way	T12 @ 150 c/c	T8 @ 150 c/c	T10 @ 150 c/c	T8 @ 150 c/c	provide 2 layer
S2	150 Thk. 2 WAY	T10 @ 100 c/c	T10 @ 100 c/c			ALTERNATE BENTUP
PARDI	W1(200mm Thk.)	T10 @ 150 c/c	T8 @ 100,150 c/c	T10 @ 150 c/c	T8 @ 100,150 c/c	VERTICAL IS MAIN STEEL

DRG NO: DP0001 DRG CL 01 801		SHEET NO: 3 OF 3	REV. R0	SCALE: NTS	SWATI Architecture landscape interior ARCHITECTS PLANERS ENGINEERING INTERIOR DESIGN 282 , tulip , A block , Talpuri International colony , Bhilai , C.G. Email - swati.arch@outlook.com
DESIGNED:	DRAWN:	CHECKED:	VERIFIED:	APPROVED:	
UPENDRA SINGH	SIMRAN SONI	UPENDRA SINGH	ADMIN	ADMIN	CHHATTISGARH STATE MINOR FOREST PRODUSE
ISSUED FOR:			UNIT:	DATE:	PROJECT:
TENDOR PURPOSE			MILIMETER	12.05.2022	INCUBATION CENTER AT DEOBHOG GARIYABAND
This drawing is the property of HUP DESIGN and is to be used only for the purpose for which it was lent and must not be in any way detrimental to the interest of the company and is subject to return on demand					TITLE:
					OVER HEAD WATER TANK

57

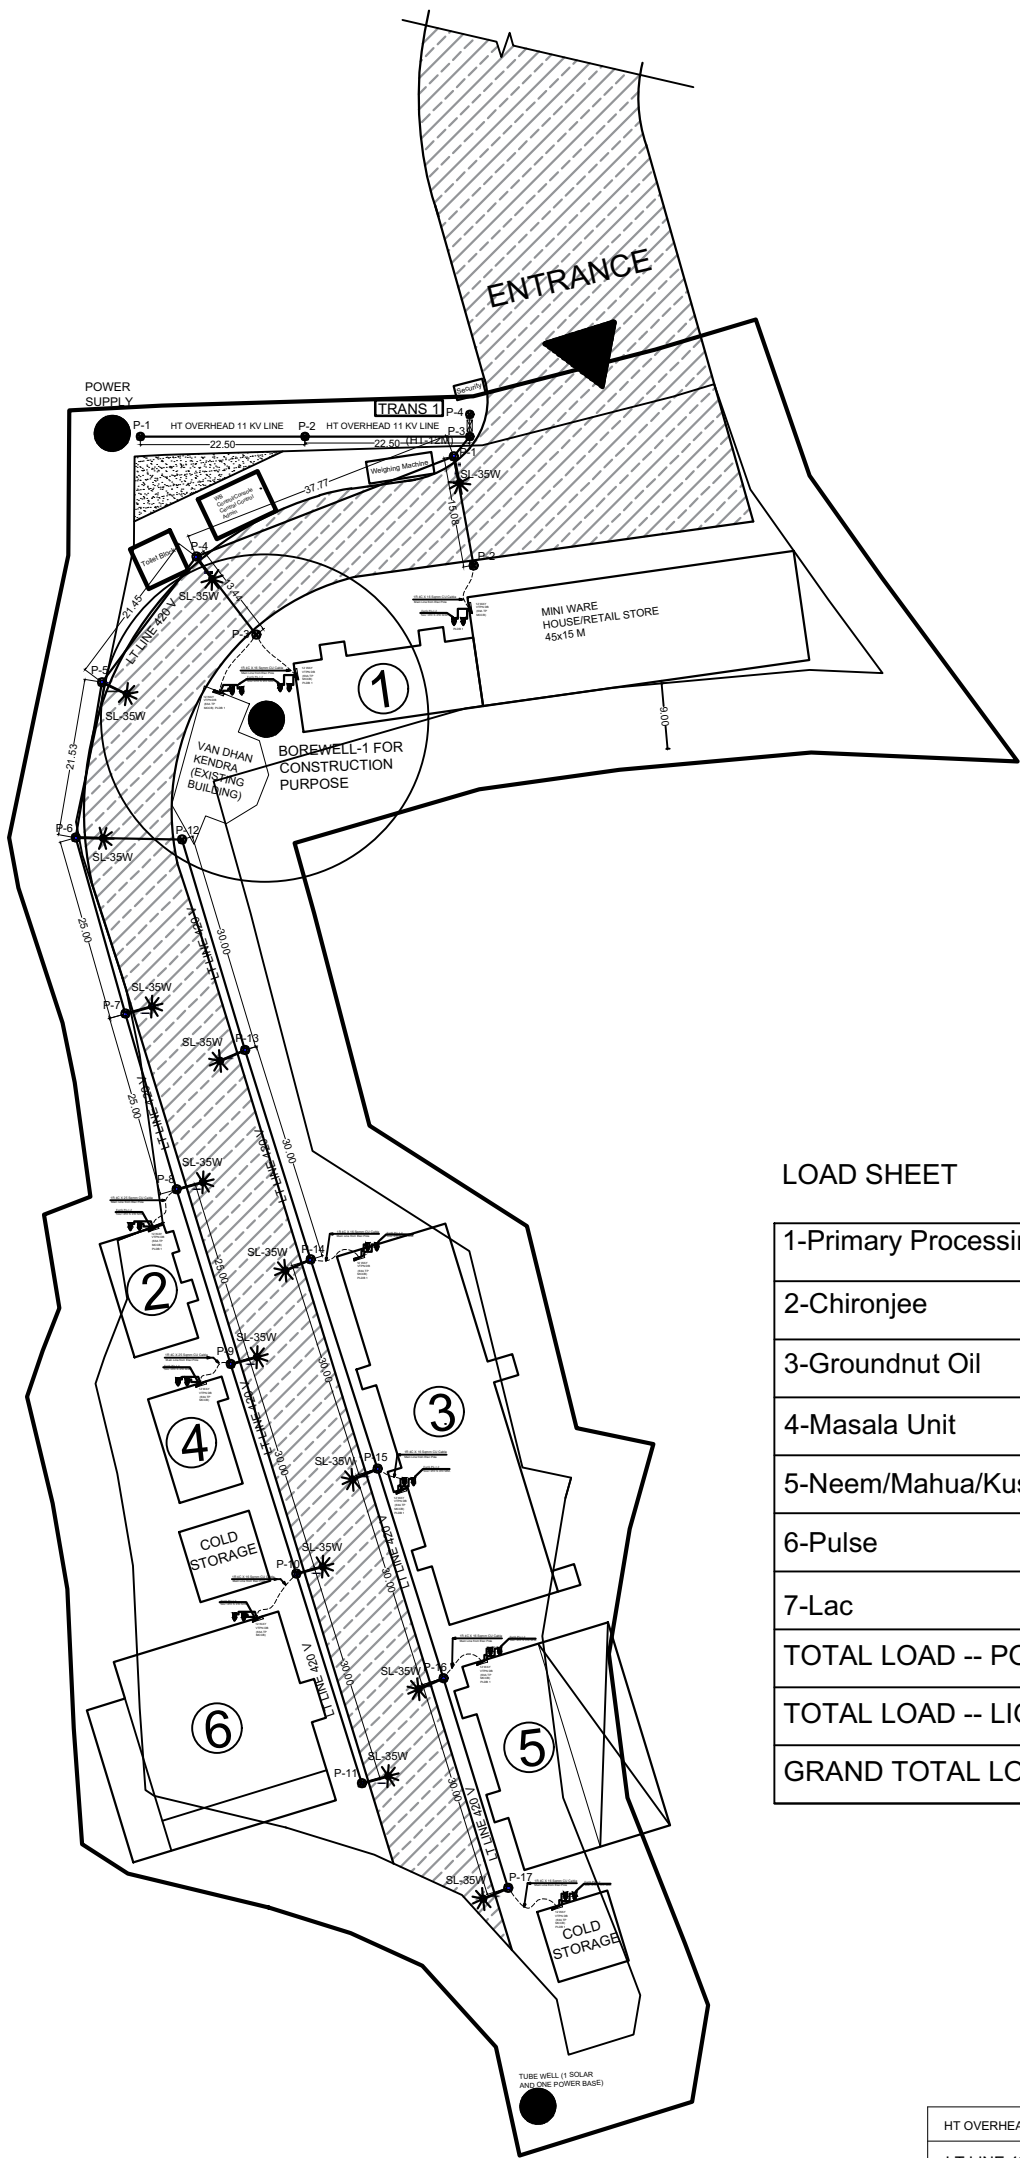


LOAD SHEET

1-Primary Processing Unit	1R 4C 16 Sqmm Ar. CU Cable 3P MCCB 100A (17 KW) 22 HP (40 AMP)
2-Chironjee	1R 4C 25 Sqmm Ar. CU Cable 3P MCCB 125A (32 KW) 43 HP (83 AMP)
3-Groundnut Oil	1R 4C 50 Sqmm Ar. CU Cable 3P MCCB 160A (53 KW) 71 HP (138 AMP)
4-Masala Unit	1R 4C 25 Sqmm Ar. CU Cable 3P MCCB 125A (25 KW) 33 HP (64 AMP)
5-Neem/Mahua/Kusum Oil	1R 4C 50 Sqmm Ar. CU Cable 3P MCCB 160A (50 KW) 66 HP (128 AMP)
6-Pulse	1R 4C 25 Sqmm Ar. CU Cable 3P MCCB 100A (27 KW) 36 HP (70 AMP)
7-Lac	1R 4C 16 Sqmm Ar. CU Cable 3P MCCB 100A (15 KW) 20 HP (40 AMP)
TOTAL LOAD -- POWER (219 KW)	
TOTAL LOAD -- LIGHT & FAN (20 KW)	
GRAND TOTAL LOAD (239 KW) (300 KVA)	

ELECTRICAL SYMBOLS LIST

HT OVERHEAD 11 KV LINE		50 MTR
LT LINE 420 V		400 MTR
SERVICE CABLE		100 MTR
	STREET LIGHT 35W	14 NO.
	LT LINE POLE 7.5 MTR. HEIGHT	17 NO.
	HT LINE POLE 12 MTR. HEIGHT	04 NO.
TRANSFORMER POLE MOUNTED TYPE	TR	Pole Mounted Sub Station 11/.433 KV Oil Immersed Transformer 315 KVA Capacity

DRG NO: DP0001 DRG CL 01 100		SHEET NO: 2 OF 2	REV. R0	SCALE: NTS	SWATI Architecture landscape interior ARCHITECTS PLANERS ENGINEERING INTERIOR DESIGN 282 , tulip , A block , Talpuri International colony , Bhilai , C.G. Email - swati.arch@outlook.com	
DESIGNED:	DRAWN:	CHECKED:	VERIFIED:	APPROVED:	CLIENT:	CHHATTISGARH STATE MINOR FOREST PRODUSE
UPENDRA SINGH	SIMRAN SONI	UPENDRA SINGH	ADMIN	ADMIN		
ISSUED FOR: TENDOR PURPOSE			UNIT: MILIMETER	DATE: 12.05.2022	PROJECT:	INCUBATION CENTER AT DEOBHOG GARIYABAND
This drawing is the property of HUP DESIGN and is to be used only for the purpose for which it was lent and must not be in any way detrimental to the interest of the company and is subject to return on demand					TITLE:	MASTER PLAN ELECTRICAL LAYOUT
					58	

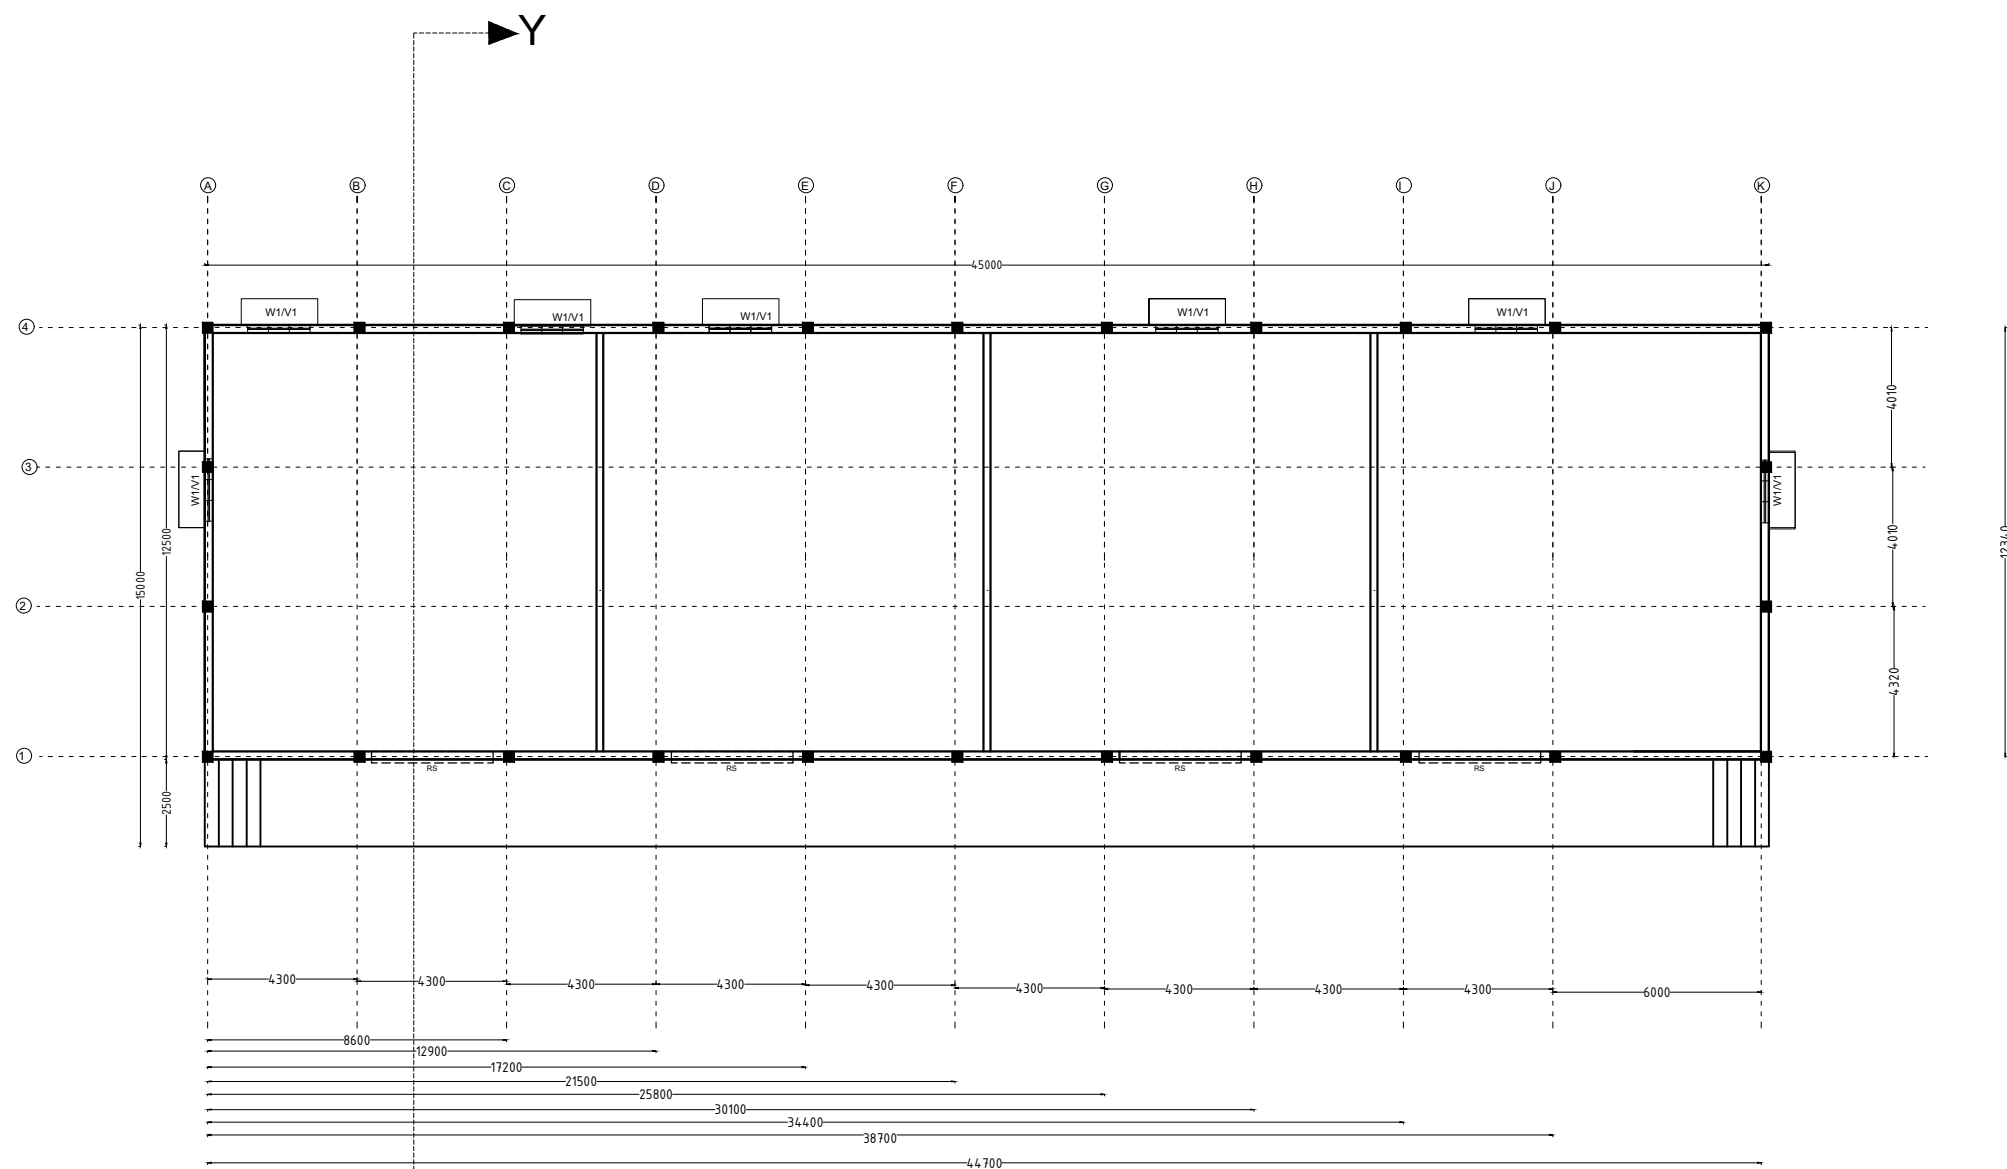

PLAN OF WAREHOUSE


- LIST OF DRAWING**
WARE HOUSE
DP0001 DRG CL 01 108
1 - PLAN LAYOUT
2 - SECTION / ELEVATION
3 - COLUMN LAYOUT
4 - FOOTING LAYOUT
5 - GROUND BEAM LAYOUT
6 - BEAM LAYOUT(2.5 M ABOVE)
7 - BEAM LAYOUT (4.5 M ABOVE)
8 - TRUSS DETAIL
9 - ELECTRICAL LAYOUT

OPENING SCHEDULE


NAME	SAYMBOL
WINDOW	- W1
VENTILATOR	- V1
ROLLING SHUTTER	- R1
DOOR	- D1

SN	SAYMBOL	NOS	SIZE
01	W1	07	1.8M X 1.5M
02	V1	07	1.8 M X 1 M
03	R1	04	2.5M X 2.4 M

DRG NO: DP0001 DRG CL 01 108	SHEET NO: 1 OF 9	REV. R0	SCALE: NTS	SWATI Architecture landscape interior ARCHITECTS PLANERS ENGINEERING INTERIOR DESIGN 282 , tulip , A block , Talpuri International colony , Bhilai , C.G. Email - swati.arch@outlook.com	
DESIGNED: UPENDRA SINGH	DRAWN: SIMRAN SONI	CHECKED: UPENDRA SINGH	VERIFIED: ADMIN	APPROVED: ADMIN	CLIENT: CHHATTISGARH STATE MINOR FOREST PRODUCE
ISSUED FOR: TENDOR PURPOSE		UNIT: MILIMETER	DATE: 12.05.2022	PROJECT: INCUBATION CENTER AT DEOBHOG GARIYABAND	TITLE: WAREHOUSE UNIT PLAN LAYOUT
This drawing is the property of HUP DESIGN and is to be used only for the purpose for which it was lent and must not be in any way detrimental to the interest of the company and is subject to return on demand					59

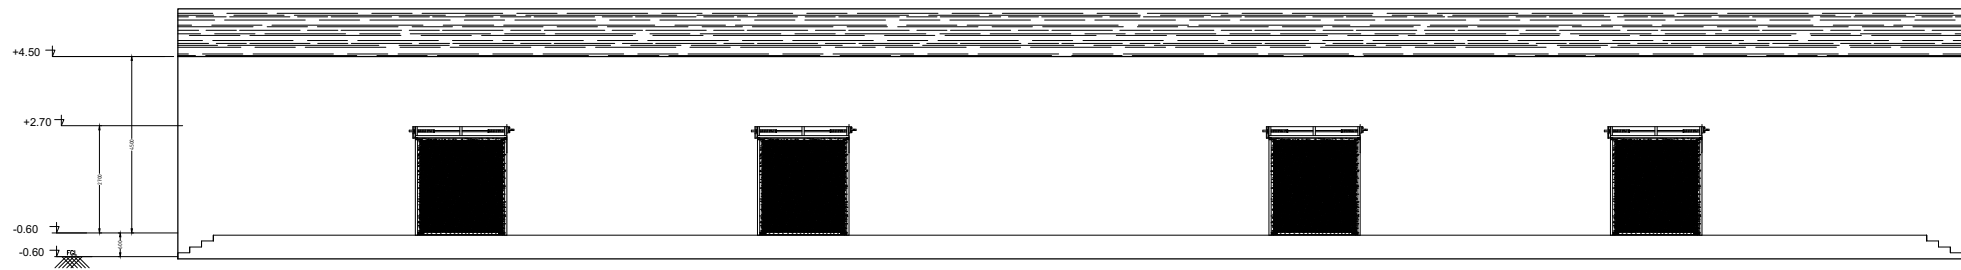


FRONT ELEVATION .

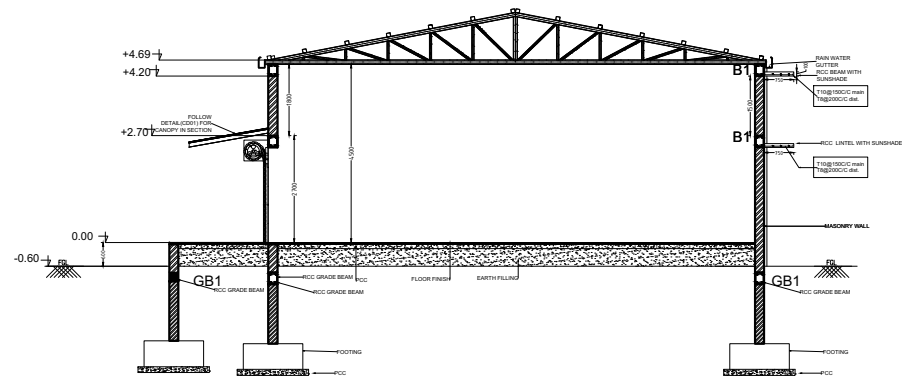


SECTION YY'.

DRG NO:DP0001 DRG CL 01 108 SHEET NO:2 OF 9 REV:R0 SCALE:NTS					SWATI Architecture landscape interior ARCHITECTS PLANERS ENGINEERING INTERIOR DESIGN 282 , tulip , A block , Talpuri International colony , Bhilai , C.G. Email - swati.arch@outlook.com						
DESIGNED:		DRAWN:		CHECKED:	VERIFIED:	APPROVED:		CLIENT:	CHHATTISGARH STATE MINOR FOREST PRODUCE		
UPENDRA SINGH		SIMRAN SONI		UPENDRA SINGH		ADMIN		ADMIN			
ISSUED FOR:					UNIT:		DATE:		PROJECT:	INCUBATION CENTER AT DEOBHOG GARIYABAND	
TENDOR PURPOSE					MILIMETER		12.05.2022				
This drawing is the property of HUP.DESIGN and is to be used only for the purpose for which it was lent and must not be in any way detrimental to the interest of the company and is subject to return on demand								TITLE:			WAREHOUSE UNIT SECTION / ELEVATION 60

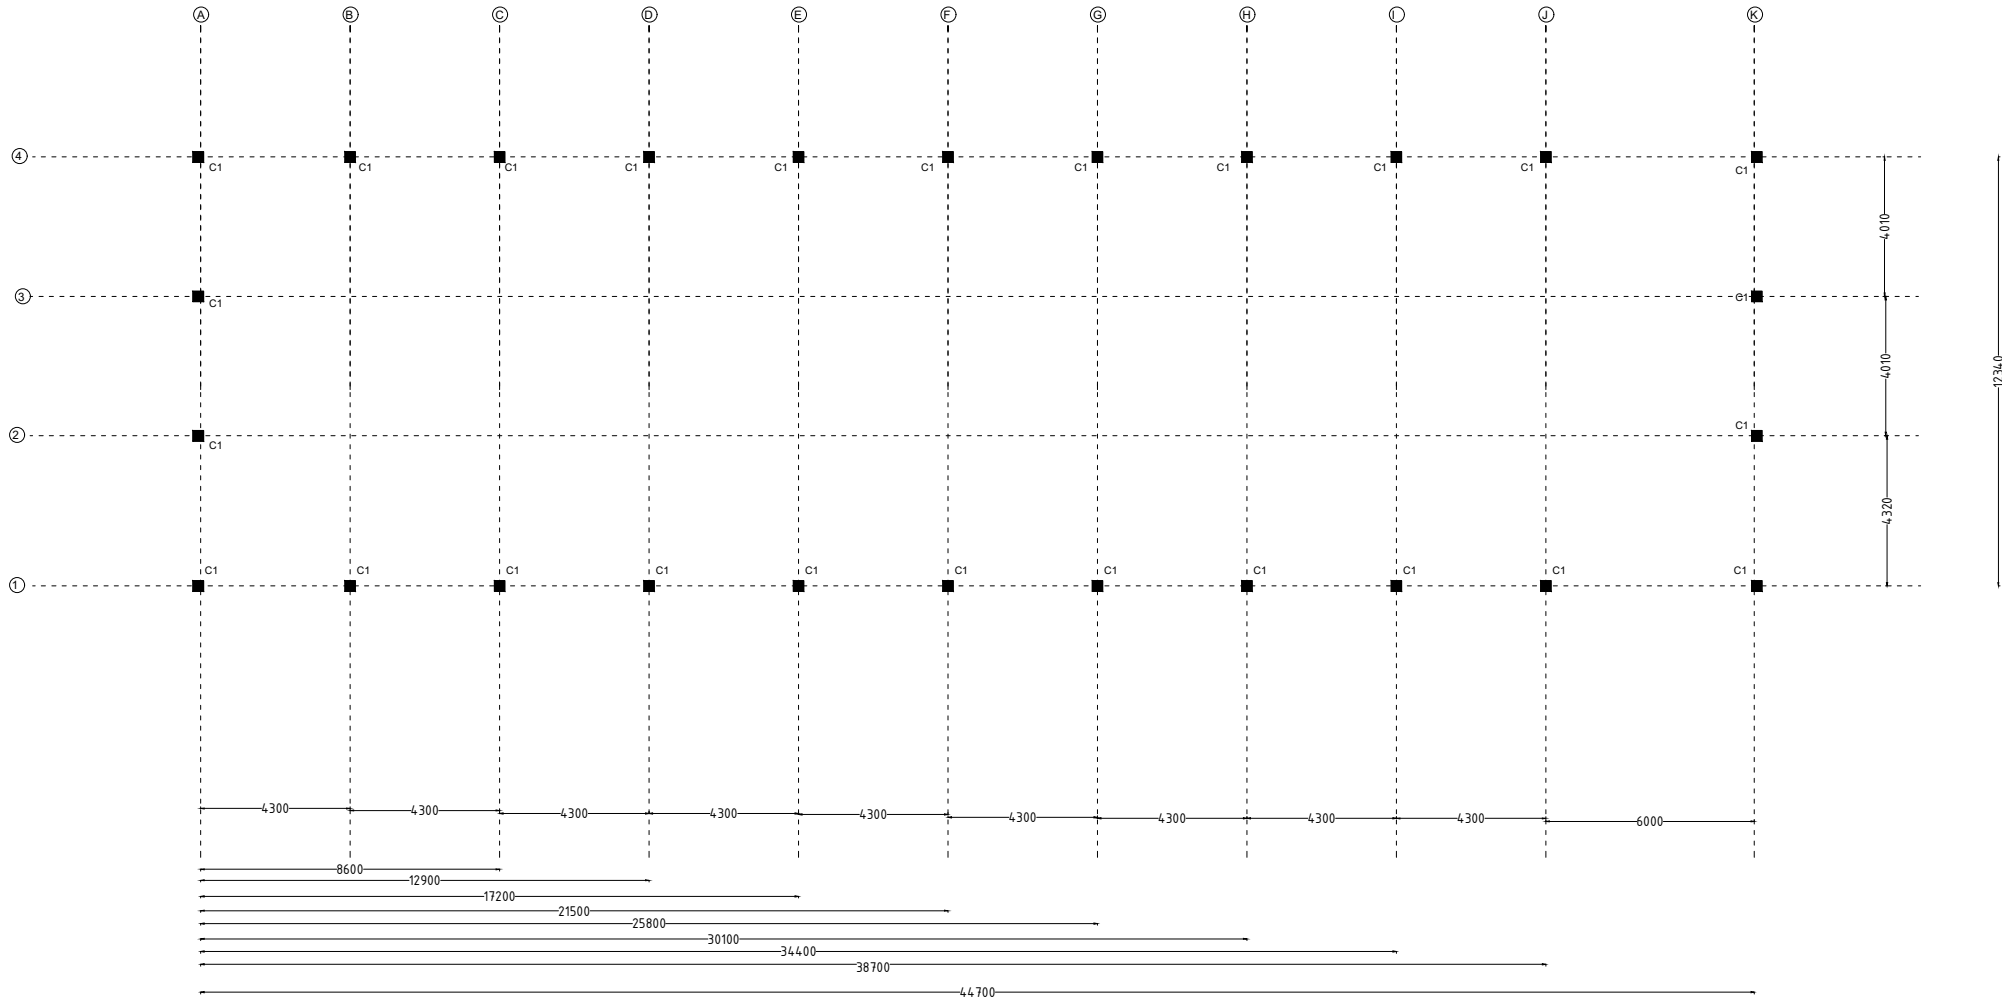

COLUMN LAYOUT

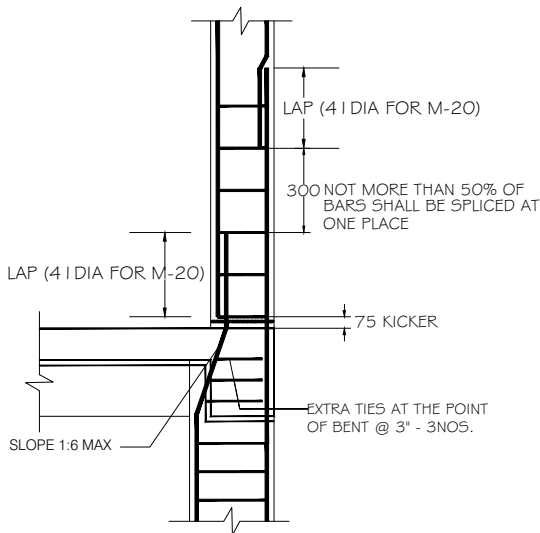

COLUMN DETAIL


TYPICAL COLUMN DETAIL'S

COLUMN NAME	Pile/col detail	STIRRUPS	REMARKS
C1	 8-T12 T8@ 200 c/c 2-T16		FOUNDATION TO TERRACE
C1	 4-T12 T8@ 200 c/c 1-T16		TERMINATE AT GROUND LVL

GENERAL NOTES

NOTES-

 
- USE - M 20 GRADE OF CONC. AS/IS 426-5000
 - USE - FE 500 GRADE OF REINF. BY CLIENT
 - PROVIDE CLEAR COVER TO MAIN REINF.
- FOUNDATION- 50MM
COLUMN - 40MM
BEAM - 25MM
SLAB - 20MM OR DIA OF BAR, WHICHEVER IS MORE,
R.C.C. WALL - 25MM
- 4.TIES SHOULD BE BEND INSIDE WITH 10# LENGTH IN BEAM & COLUMN




- FOLLOW - IS-456-2000 FOR R.C.C. WORK
- STRIPPING TIME FOR SHUTTERING / FORMWORK UNDER NORMAL CONDITION.

TYPE OF WORK	MINIMUM PERIOD BEFORE STRIKING FORM WORK
a) VERTICAL FORMWORK TO COLUMN, WALLS, BEAM	16-24 HOUR
b) SOFFITS FORMWORK TO SLABS (PROPS TO BE REFIXED- IMMEDIATELY AFTER REMOVAL OF FORMWORK)	3 DAYS
c) SOFFIT FORMWORK TO BEAMS (PROPS TO BE REFIXED IMMEDIATELY AFTER REMOVAL OF FORMWORK)	7DAYS
d) PROPS TO SLABS:	
1) SPANNING UP TO 4.5M	7DAYS
2) SPANNING OVER 4.5M	14 DAYS
e) PROPS TO BEAMS & ARCHES:	
1) SPANNING UP TO 6M	14DAYS
2) SPANNING OVER 6M	21DAYS
7. CURING FOR R.C.C. MEMBER MINIMUM 14 DAYS CONTINOUSELY PREFERABLE - 28 DAYS.	
8. START EARLY CURING TO AVOID SRINKAGE CRACKS, WHEN CONCRETE APPEARS TO HARDEN.	
9) PROVIDE FOLLOWING SLUMP IN CONCRETE GEN-ERALLY.	
a) SHALLOW SECTIONS, PAYMENTS, MASS CONC. LIGTH REINFORCEMENT	
SECTION IN SLAB, BEAM, WALL, COLUMN	25-75
b) HEAVILY REINFORCEMENT SECTION IN SLAB	50-100
c) HEAVILY REINFORCEMENT SECTION IN BEAMS, WALLS, COLUMNS SLIPFORM, OR PUMPED CONC.	75-100
d) TRENCH FILL, PILLING, PUMPED CONC.	100-150
10) PROVIDE LAP/ DEVELOPEMENT LENGTH IN REINFORCEMENT BARS GRADE OF CONC.	
	M20- 47Ø
	M25-41Ø
	M30-38Ø
11) REFER RELEVANT DRG. WITH THIS DRG.	
12) AVOID CORE CUTING.	

DRG NO:		SHEET NO:	REV.	SCALE:	SWATI Architecture landscape interior ARCHITECTS PLANERS ENGINEERING INTERIOR DESIGN 282 , tulip , A block , Talpuri International colony , Bhilai , C.G. Email - swati.arch@outlook.com		
DP0001 DRG CL 01 108		3 OF 9	R0	NTS			
DESIGNED:	DRAWN:	CHECKED:	VERIFIED:	APPROVED:	CLIENT:	CHHATTISGARH STATE MINOR FOREST PRODUSE	
UPENDRA SINGH	SIMRAN SONI	UPENDRA SINGH	ADMIN	ADMIN			
ISSUED FOR:		UNIT:		DATE:	PROJECT:	INCUBATION CENTER AT DEOBHOG GARIYABAND	
TENDOR PURPOSE		MILIMETER		12.05.2022			
This drawing is the property of HUP DESIGN and is to be used only for the purpose for which it was lent and rust not be in any way detrimental to the interest of the company and is subject to return on demand					TITLE:	WAREHOUSE UNIT COLUMN LAYOUT	61

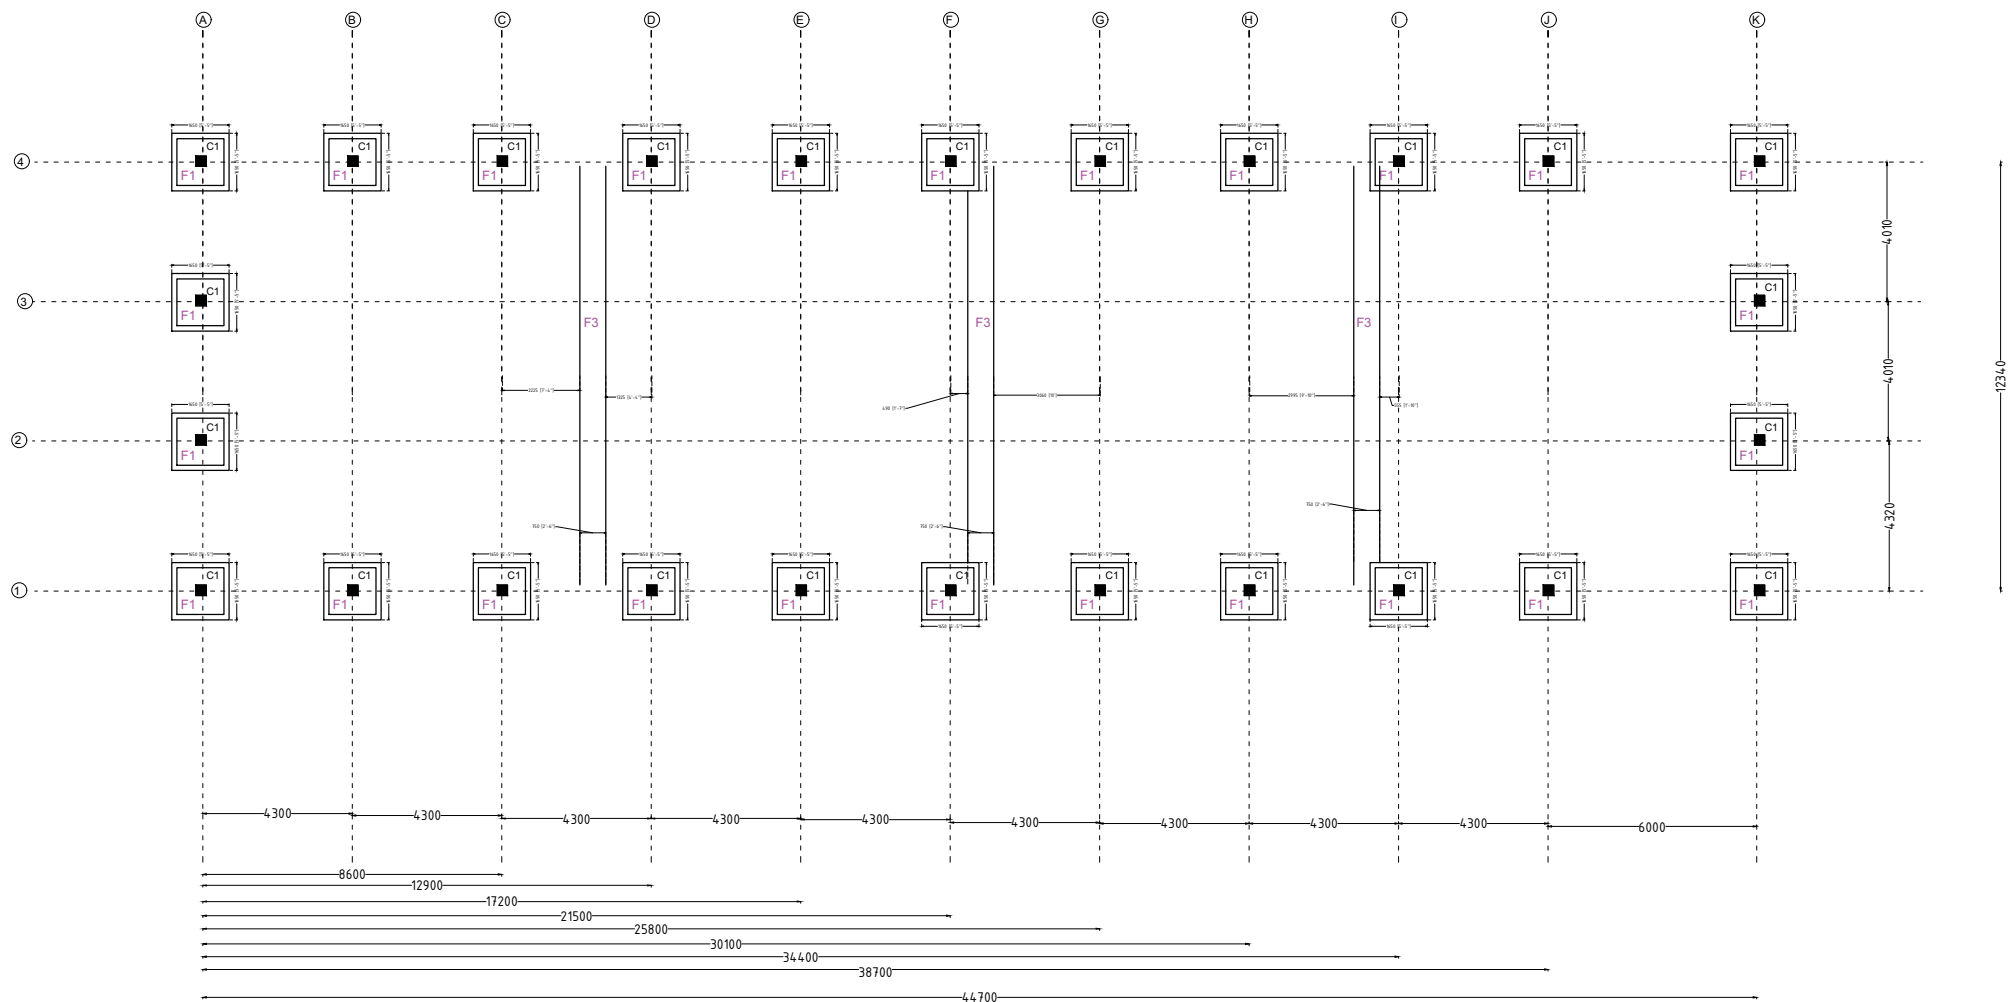

FOOTING LAYOUT

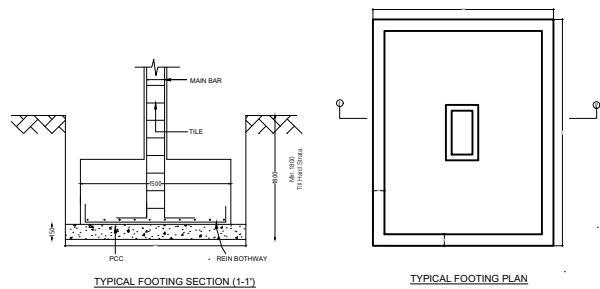


FOOTING SCHEDULE						
FE500 AND M20						
Footings	Column	PCC Size	Footings Size	Total	Steel	Steel
	Nos	X - Y mm	X - Y mm	Depth mm	to X mm	to Y mm
F1	C1	1650 X 1650	1350 X 1350	400	T10@ 175C/C	T10@ 175 C/C
F2	C2	1200 X 1200	900 X 900	230	T8@200C/C	T8@ 200 C/C
						Bottom bars only

GENERAL NOTES

NOTES-

 
- USE - M 20 GRADE OF CONC. AS/IS 426-5000
 - USE - FE 500 GRADE OF REINF. BY CLIENT
 - PROVIDE CLEAR COVER TO MAIN REINF.
- FOUNDATION- 50MM
COLUMN - 40MM
BEAM - 25MM
SLAB - 20MM OR DIA OF BAR, WHICHEVER IS MORE,
R.C.C. WALL - 25MM
- 4.TIES SHOULD BE BEND INSIDE WITH 10# LENGTH
IN BEAM & COLUMN




- FOLLOW - IS-456-2000 FOR R.C.C. WORK
- STRIPPING TIME FOR SHUTTERING / FORMWORK UNDER NORMAL CONDITION.

TYPE OF WORK	MINIMUM PERIOD BEFORE STRIKING FORM WORK
a) VERTICAL FORMWORK TO COLUMN, WALLS, BEAM	16-24 HOUR
b) SOFFITS FORMWORK TO SLABS (PROPS TO BE REFIXED- IMMEDIATELY AFTER REMOVAL OF FORMWORK)	3 DAYS
c) SOFFIT FORMWORK TO BEAMS (PROPS TO BE REFIXED IMMEDIATELY AFTER REMOVAL OF FORMWORK)	7DAYS
d) PROPS TO SLABS:	
1) SPANNING UP TO 4.5M	7DAYS
2) SPANNING OVER 4.5M	14 DAYS
e) PROPS TO BEAMS & ARCHES:	
1) SPANNING UP TO 6M	14DAYS
2) SPANNING OVER 6M	21DAYS
7. CURING FOR R.C.C. MEMBER MINIMUM 14 DAYS CONTINUOUSLY PREFERABLE - 28 DAYS.	
8. START EARLY CURING TO AVOID SRINKAGE CRACKS, WHEN CONCRETE APPEARS TO HARDEN.	
9) PROVIDE FOLLOWING SLUMP IN CONCRETE GENERALLY.	
a) SHALLOW SECTIONS, PAYMENTS, MASS CONC. LIGHT REINFORCEMENT	25-75
b) HEAVILY REINFORCEMENT SECTION IN SLAB	50-100
c) HEAVILY REINFORCEMENT SECTION IN BEAMS, WALLS, COLUMNS SLIPFORM, OR PUMPED CONC.	75-100
d) TRENCH FILL, PILLING, PUMPED CONC.	100-150
10) PROVIDE LAP/ DEVELOPEMENT LENGTH IN REINFORCEMENT BARS GRADE OF CONC.	
	M20- 47Ø
	M25-41Ø
	M30-38Ø
11) REFER RELEVANT DRG. WITH THIS DRG.	
12) AVOID CORE CUTING.	

DRG NO:		SHEET NO:	REV.	SCALE:	SWATI Architecture landscape interior ARCHITECTS PLANERS ENGINEERING INTERIOR DESIGN 282 , tulip , A block , Talpuri International colony , Bhilai , C.G. Email - swati.arch@outlook.com
DP0001 DRG CL 01 108		4 OF 9	R0	NTS	
DESIGNED:	DRAWN:	CHECKED:	VERIFIED:	APPROVED:	CLIENT:
UPENDRA SINGH	SIMRAN SONI	UPENDRA SINGH	ADMIN	ADMIN	CHHATTISGARH STATE MINOR FOREST PRODUCE
ISSUED FOR:			UNIT:	DATE:	PROJECT:
TENDOR PURPOSE			MILIMETER	12.05.2022	INCUBATION CENTER AT DEOBHOG GARIYABAND
This drawing is the property of HUP DESIGN and is to be used only for the purpose for which it was lent and must not be in any way detrimental to the interest of the company and is subject to return on demand					TITLE:
					WAREHOUSE UNIT FOOTING LAYOUT 62

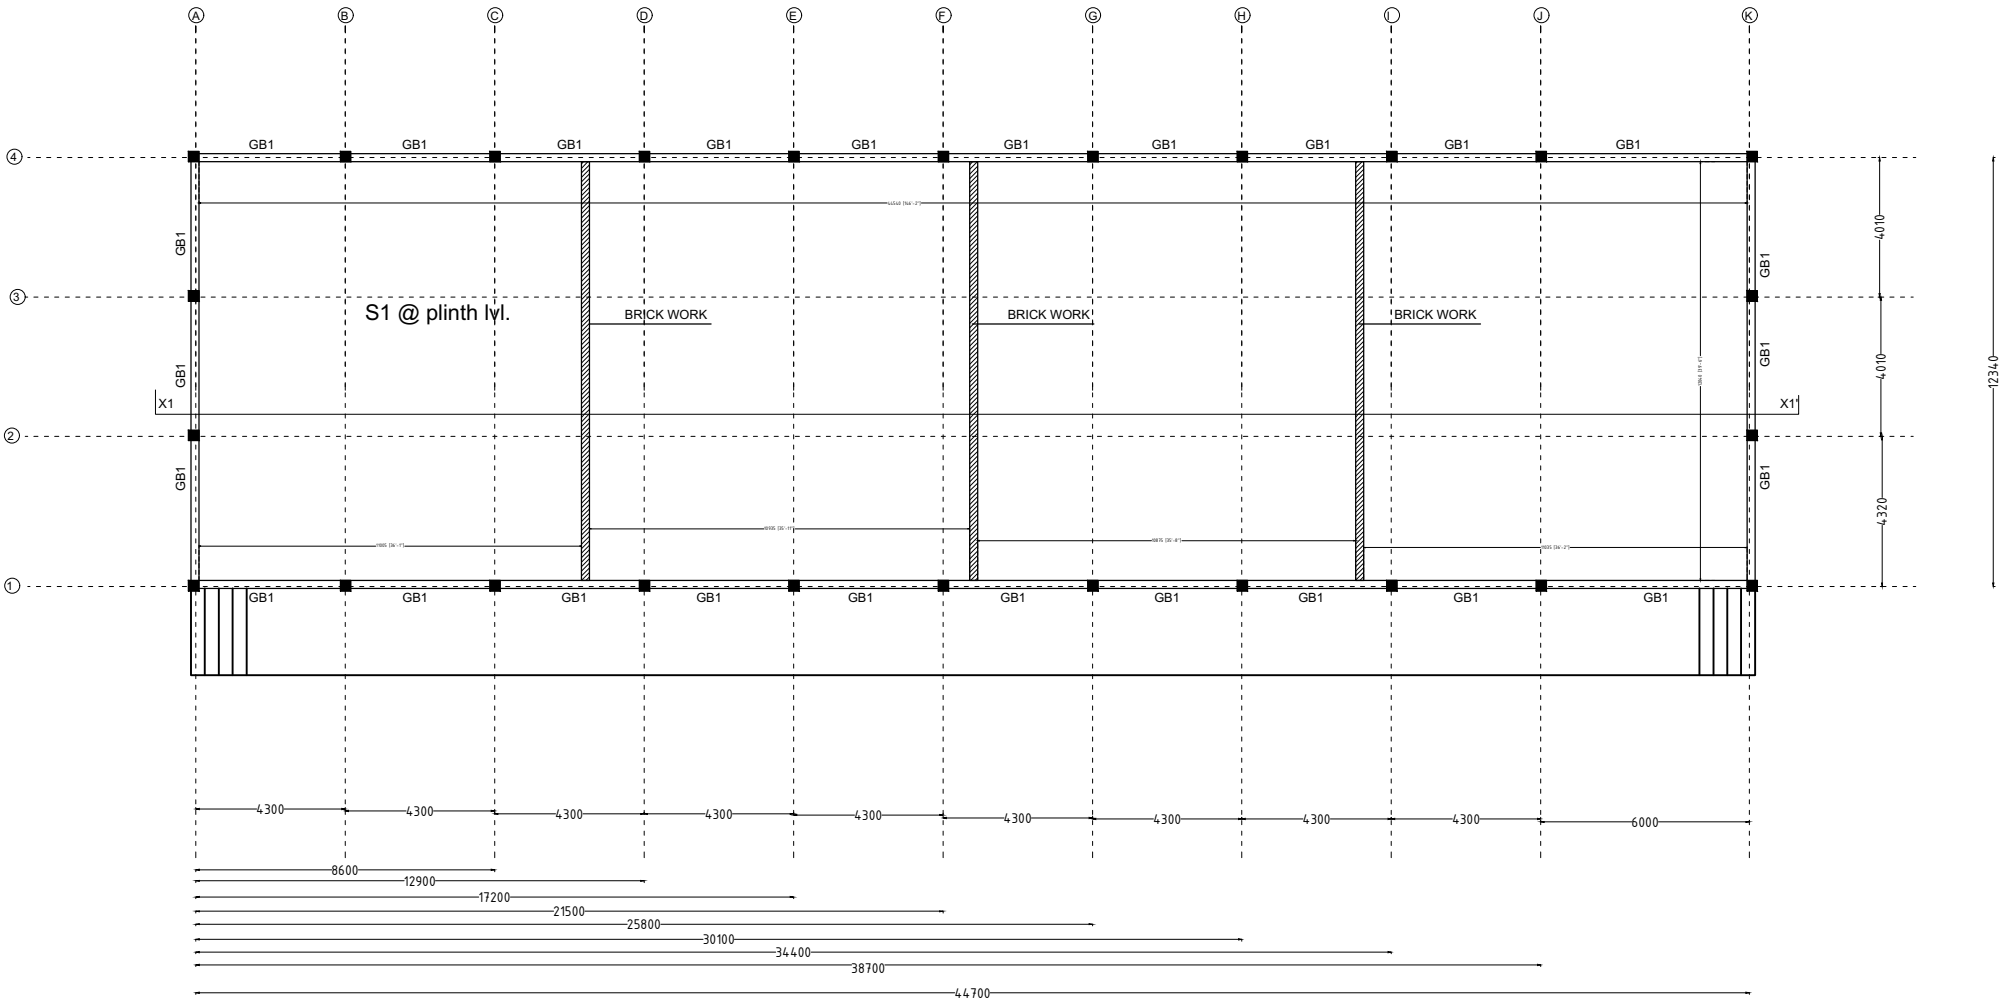

GROUND BEAM PLAN

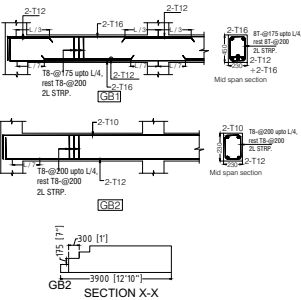

GROUND BEAM SECTIONAL DETAIL

BEAM SCHEDULE FOR GROUND/ PLINTH LVL.

Beam	Size	Top	Bottom	Top	Bottom	Top	Bottom	Top	Bottom	Remarks
GB1	230x375	2-T16	2-T12	2-T16	2-T12	2-T12	T8 @200C/C	T8 @175C/C	T8 @175C/C	SLAB THK. INCLUDED
GB2	230x230	2-T12	-	2-T10	-	-	T8 @200C/C	T8 @200C/C	T8 @200C/C	SLAB THK. INCLUDED


SLAB SCHEDULE FOR GROUND FLOOR LVL.

Slab Name	Thickness (mm)	Main Steel		Other Steel	Remarks
S1	150 (MESH)	T8 @ 200 c/c	T8 @ 200 c/c		All straight

GENERAL NOTES

NOTES-

 - USE - M 20 GRADE OF CONC. AS/IS 426-5000
 - USE - FE 500 GRADE OF REINF. BY CLIENT
 - PROVIDE CLEAR COVER TO MAIN REINF.
- FOUNDATION- 50MM
COLUMN - 40MM
BEAM - 25MM
SLAB - 20MM OR DIA OF BAR, WHICHEVER IS MORE,
R.C.C. WALL - 25MM
- 4.TIES SHOULD BE BEND INSIDE WITH 10# LENGTH IN BEAM & COLUMN




- FOLLOW - IS-456-2000 FOR R.C.C. WORK
- STRIPPING TIME FOR SHUTTERING / FORMWORK UNDER NORMAL CONDITION.

TYPE OF WORK	MINIMUM PERIOD BEFORE STRIKING FORM WORK
--------------	--

- VERTICAL FORMWORK TO COLUMN, WALLS, BEAM 16-24 HOUR
- SOFFITS FORMWORK TO SLABS (PROPS TO BE REFIXED- IMMEDIATELY AFTER REMOVAL OF FORMWORK) 3 DAYS
- SOFFIT FORMWORK TO BEAMS (PROPS TO BE REFIXED IMMEDIATELY AFTER REMOVAL OF FORMWORK) 7DAYS
- PROPS TO SLABS:
 - 1) SPANNING UP TO 4.5M 7DAYS
 - 2) SPANNING OVER 4.5M 14 DAYS
- PROPS TO BEAMS & ARCHES:
 - 1) SPANNING UP TO 6M 14DAYS
 - 2) SPANNING OVER 6M 21DAYS

- CURING FOR R.C.C. MEMBER MINIMUM 14 DAYS CONTINUOUSLY PREFERABLE - 28 DAYS.
- START EARLY CURING TO AVOID SRINKAGE CRACKS, WHEN CONCRETE APPEARS TO HARDEN.
- PROVIDE FOLLOWING SLUMP IN CONCRETE GENERALLY.
 - SHALLOW SECTIONS, PAYMENTS, MASS CONC. LIGTH REINFORCEMENT SECTION IN SLAB, BEAM, WALL, COLUMN 25-75
 - HEAVILY REINFORCEMENT SECTION IN SLAB 50-100
 - HEAVILY REINFORCEMENT SECTION IN BEAMS, WALLS, COLUMNS SLIPFORM, OR PUMPED CONC. 75-100
 - TRENCH FILL, PILLING, PUMPED CONC. 100-150
- PROVIDE LAP/ DEVELOPEMENT LENGTH IN REINFORCEMENT BARS GRADE OF CONC.
 - M20- 47Ø
 - M25-41Ø
 - M30-38Ø
- REFER RELEVANT DRG. WITH THIS DRG.
- AVOID CORE CUTING.


DRG NO:	SHEET NO:	REV.	SCALE:	SWATI Architecture landscape interior ARCHITECTS PLANERS ENGINEERING INTERIOR DESIGN 282 , tulip , A block , Talpuri International colony , Bhilai , C.G. Email - swati.arch@outlook.com	
DP0001 DRG CL 01 108	5 OF 9	R0	NTS		
DESIGNED:	DRAWN:	CHECKED:	VERIFIED:	APPROVED:	CLIENT:
UPENDRA SINGH	SIMRAN SONI	UPENDRA SINGH	ADMIN	ADMIN	CHHATTISGARH STATE MINOR FOREST PRODUSE
ISSUED FOR:		UNIT:	DATE:	PROJECT:	
TENDOR PURPOSE		MILIMETER	12.05.2022	INCUBATION CENTER AT DEOBHOG GARIYABAND	
This drawing is the property of HUP DESIGN and is to be used only for the purpose for which it was lent and must not be in any way detrimental to the interest of the company and is subject to return on demand				TITLE:	
				WAREHOUSE UNIT BEAM LAYOUT	63

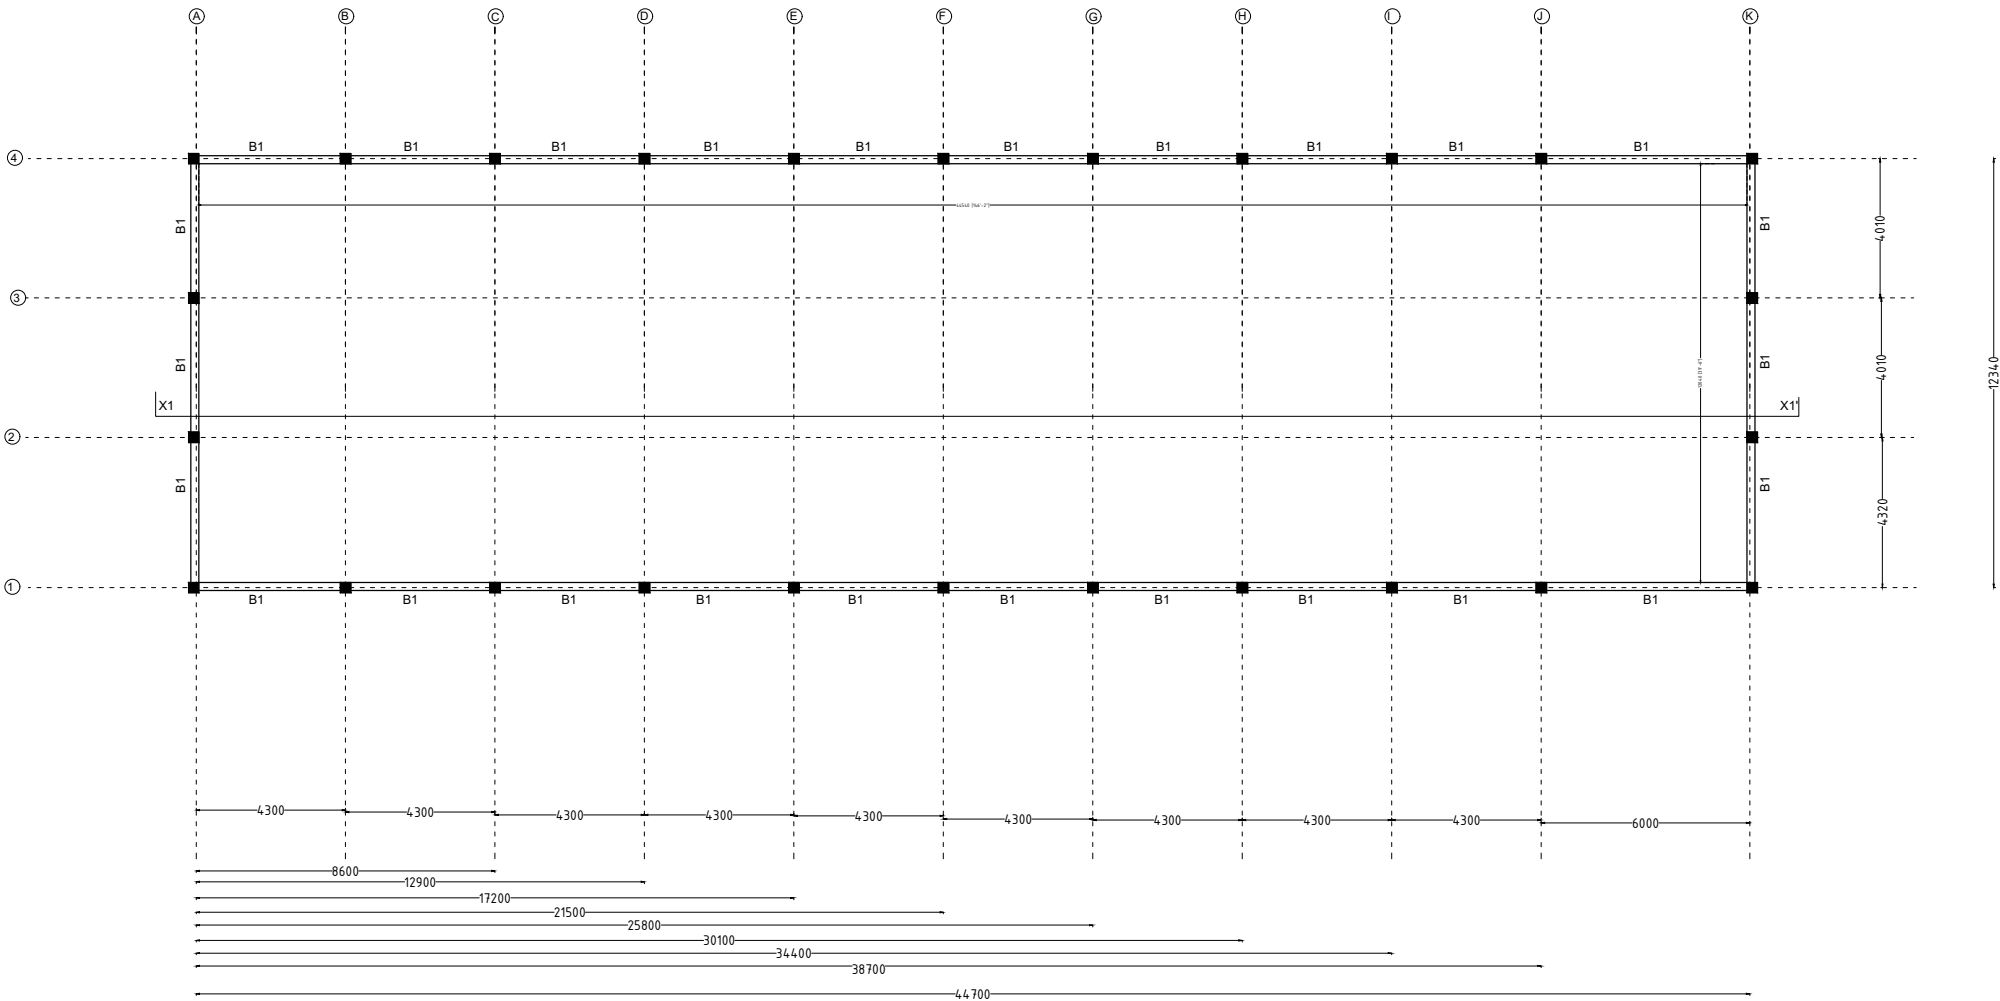

BEAM PLAN(2.4 m ABOVE PLINTH LVL)

BEAM SCHEDULE FOR 2.4m LVL. ABOVE PLINTH


Beam ID	Size	Reinforcement					Notes		
		Top	Bottom	Top	Bottom	Top	Other	Other	Other
B1	230x300	2-T12	2-T12	2-T12	2-T12	2-T12	T8 @200C/C	T8 @175C/C	T8 @175C/C

 

GENERAL NOTES

NOTES-

 1. USE - M 20 GRADE OF CONC. AS/IS 426-5000
2. USE - FE 500 GRADE OF REINF. BY CLIENT
3. PROVIDE CLEAR COVER TO MAIN REINF.
- FOUNDATION- 50MM
- COLUMN - 40MM
- BEAM - 25MM
- SLAB - 20MM OR DIA OF BAR, WHICHEVER IS MORE,
- R.C.C. WALL - 25MM
- 4.TIES SHOULD BE BEND INSIDE WITH 10# LENGTH IN BEAM & COLUMN



- 5.FOLLOW - IS-456-2000 FOR R.C.C. WORK
- 6.STRIPPING TIME FOR SHUTTERING / FORMWORK UNDER NORMAL CONDITION.

TYPE OF WORK	MINIMUM PERIOD BEFORE STRIKING FORM WORK
a) VERTICAL FORMWORK TO COLUMN, WALLS, BEAM	16-24 HOUR
b) SOFFITS FORMWORK TO SLABS (PROPS TO BE REFIXED- IMMEDIATELY AFTER REMOVAL OF FORMWORK)	3 DAYS
c) SOFFIT FORMWORK TO BEAMS (PROPS TO BE REFIXED IMMEDIATELY AFTER REMOVAL OF FORMWORK)	7DAYS
d) PROPS TO SLABS:	
1) SPANNING UP TO 4.5M	7DAYS
2) SPANNING OVER 4.5M	14 DAYS
e) PROPS TO BEAMS & ARCHES:	
1) SPANNING UP TO 6M	14DAYS
2) SPANNING OVER 6M	21DAYS

7. CURING FOR R.C.C. MEMBER MINIMUM 14 DAYS CONTINOUSELY PREFERABLE - 28 DAYS.
8. START EARLY CURING TO AVOID SRINKAGE CRACKS, WHEN CONCRETE APPEARS TO HARDEN.
- 9) PROVIDE FOLLOWING SLUMP IN CONCRETE GEN-ERALLY.
- a) SHALLOW SECTIONS, PAYMENTS, MASS CONC. LIGTH REINFORCEMENT SECTION IN SLAB, BEAM, WALL, COLUMN
- b) HEAVILY REINFORCEMENT SECTION IN SLAB
- c) HEAVILY REINFORCEMENT SECTION IN BEAMS, WALLS, COLUMNS SLIPFORM, OR PUMPED CONC.
- d) TRENCH FILL, PILLING, PUMPED CONC.
- 10) PROVIDE LAP/ DEVELOPEMENT LENGTH IN REINFORCEMENT BARS GRADE OF CONC.
- 11) REFER RELEVANT DRG. WITH THIS DRG.
- 12) AVOID CORE CUTING.

M20- 47Ø
M25-41Ø
M30-38Ø

DRG NO:
DP0001 DRG CL 01 108

SHEET NO:
6 OF 9

REV.
R0

SCALE:
NTS

DESIGNED:
UPENDRA SINGH

DRAWN:
SIMRAN SONI

CHECKED:
UPENDRA SINGH

VERIFIED:
ADMIN

APPROVED:
ADMIN

ISSUED FOR:
TENDOR PURPOSE

UNIT:
MILIMETER

DATE:
12.05.2022

CLIENT:
CHHATTISGARH STATE MINOR FOREST PRODUSE

PROJECT:
INCUBATION CENTER AT DEOBHOG GARIYABAND


TITLE:
WAREHOUSE UNIT
BEAM LAYOUT

SWATI Architecture landscape interior


ARCHITECTS | PLANERS | ENGINEERING | INTERIOR DESIGN

282 , tulip , A block , Talpuri International colony , Bhilai , C.G. Email - swati.arch@outlook.com

64

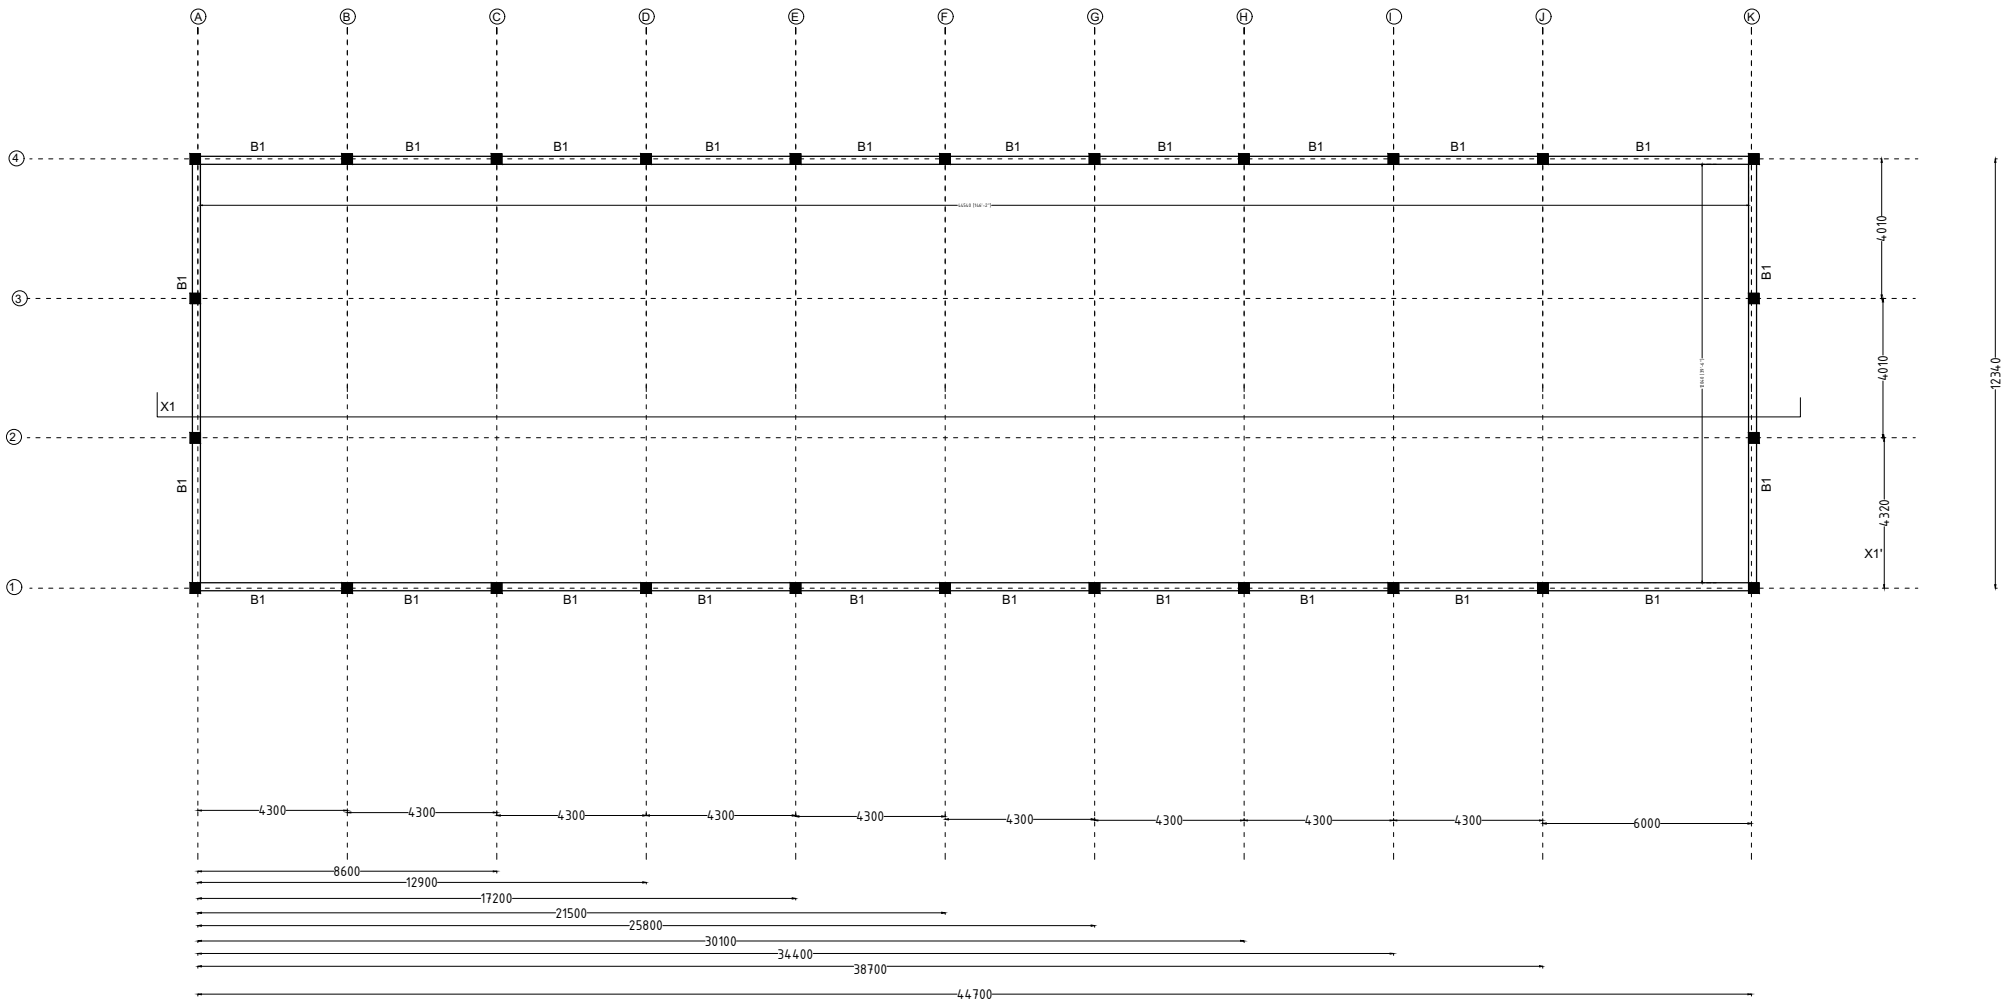

BEAM PLAN (4.5 ABOVE PLINTH LVL)

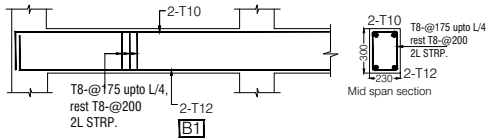


BEAM SCHEDULE FOR 4.5m LVL. ABOVE PLINTH

Beam ID	Size	Top Bar	Bottom Bar	Stirrups	Notes
B1	230X300	2-T12	2-T10	-	T8 @200C/C, T8 @175C/C, T8 @175C/C, SLAB THK. INCLUDED

GENERAL NOTES

NOTES-

 - USE - M 20 GRADE OF CONC. AS/IS 426-5000
- USE - FE 500 GRADE OF REINF. BY CLIENT
- PROVIDE CLEAR COVER TO MAIN REINF.
- FOUNDATION- 50MM
COLUMN - 40MM
BEAM - 25MM
SLAB - 20MM OR DIA OF BAR, WHICHEVER IS MORE,
R.C.C. WALL - 25MM
- TIES SHOULD BE BEND INSIDE WITH 10# LENGTH IN BEAM & COLUMN



- FOLLOW - IS-456-2000 FOR R.C.C. WORK
- STRIPPING TIME FOR SHUTTERING / FORMWORK UNDER NORMAL CONDITION.

TYPE OF WORK	MINIMUM PERIOD BEFORE STRIKING FORM WORK
a) VERTICAL FORMWORK TO COLUMN, WALLS, BEAM	16-24 HOUR
b) SOFFITS FORMWORK TO SLABS (PROPS TO BE REFIXED- IMMEDIATELY AFTER REMOVAL OF FORMWORK)	3 DAYS
c) SOFFIT FORMWORK TO BEAMS (PROPS TO BE REFIXED IMMEDIATELY AFTER REMOVAL OF FORMWORK)	7DAYS
d) PROPS TO SLABS:	
1) SPANNING UP TO 4.5M	7DAYS
2) SPANNING OVER 4.5M	14 DAYS
e) PROPS TO BEAMS & ARCHES:	
1) SPANNING UP TO 6M	14DAYS
2) SPANNING OVER 6M	21DAYS
7. CURING FOR R.C.C. MEMBER MINIMUM 14 DAYS CONTINUOUSLY PREFERABLE - 28 DAYS.	
8. START EARLY CURING TO AVOID SRINKAGE CRACKS, WHEN CONCRETE APPEARS TO HARDEN.	
9) PROVIDE FOLLOWING SLUMP IN CONCRETE GENERALLY.	
a) SHALLOW SECTIONS, PAYMENTS, MASS CONC. LIGTH REINFORCEMENT SECTION IN SLAB, BEAM, WALL, COLUMN	25-75
b) HEAVILY REINFORCEMENT SECTION IN SLAB	50-100
c) HEAVILY REINFORCEMENT SECTION IN BEAMS, WALLS, COLUMNS SLIPFORM, OR PUMPED CONC.	75-100
d) TRENCH FILL, PILLING, PUMPED CONC.	100-150
10) PROVIDE LAP/ DEVELOPEMENT LENGTH IN REINFORCEMENT BARS GRADE OF CONC.	M20- 47Ø M25-41Ø M30-38Ø
11) REFER RELEVANT DRG. WITH THIS DRG.	
12) AVOID CORE CUTING.	

DRG NO:
DP0001 DRG CL 01 108

SHEET NO:
7 OF 9

REV.
R0

SCALE:
NTS

DESIGNED:
UPENDRA SINGH

DRAWN:
SIMRAN SONI

CHECKED:
UPENDRA SINGH

VERIFIED:
ADMIN

APPROVED:
ADMIN

ISSUED FOR:
TENDOR PURPOSE

UNIT:
MILIMETER

DATE:
12.05.2022


CLIENT:
CHHATTISGARH STATE MINOR FOREST PRODUSE

PROJECT:
INCUBATION CENTER AT DEOBHOG GARIYABAND


TITLE:
**WAREHOUSE UNIT
BEAM LAYOUT**

This drawing is the property of HUP DESIGN and is to be used only for the purpose for which it was lent and must not be in any way detrimental to the interest of the company and is subject to return on demand


65

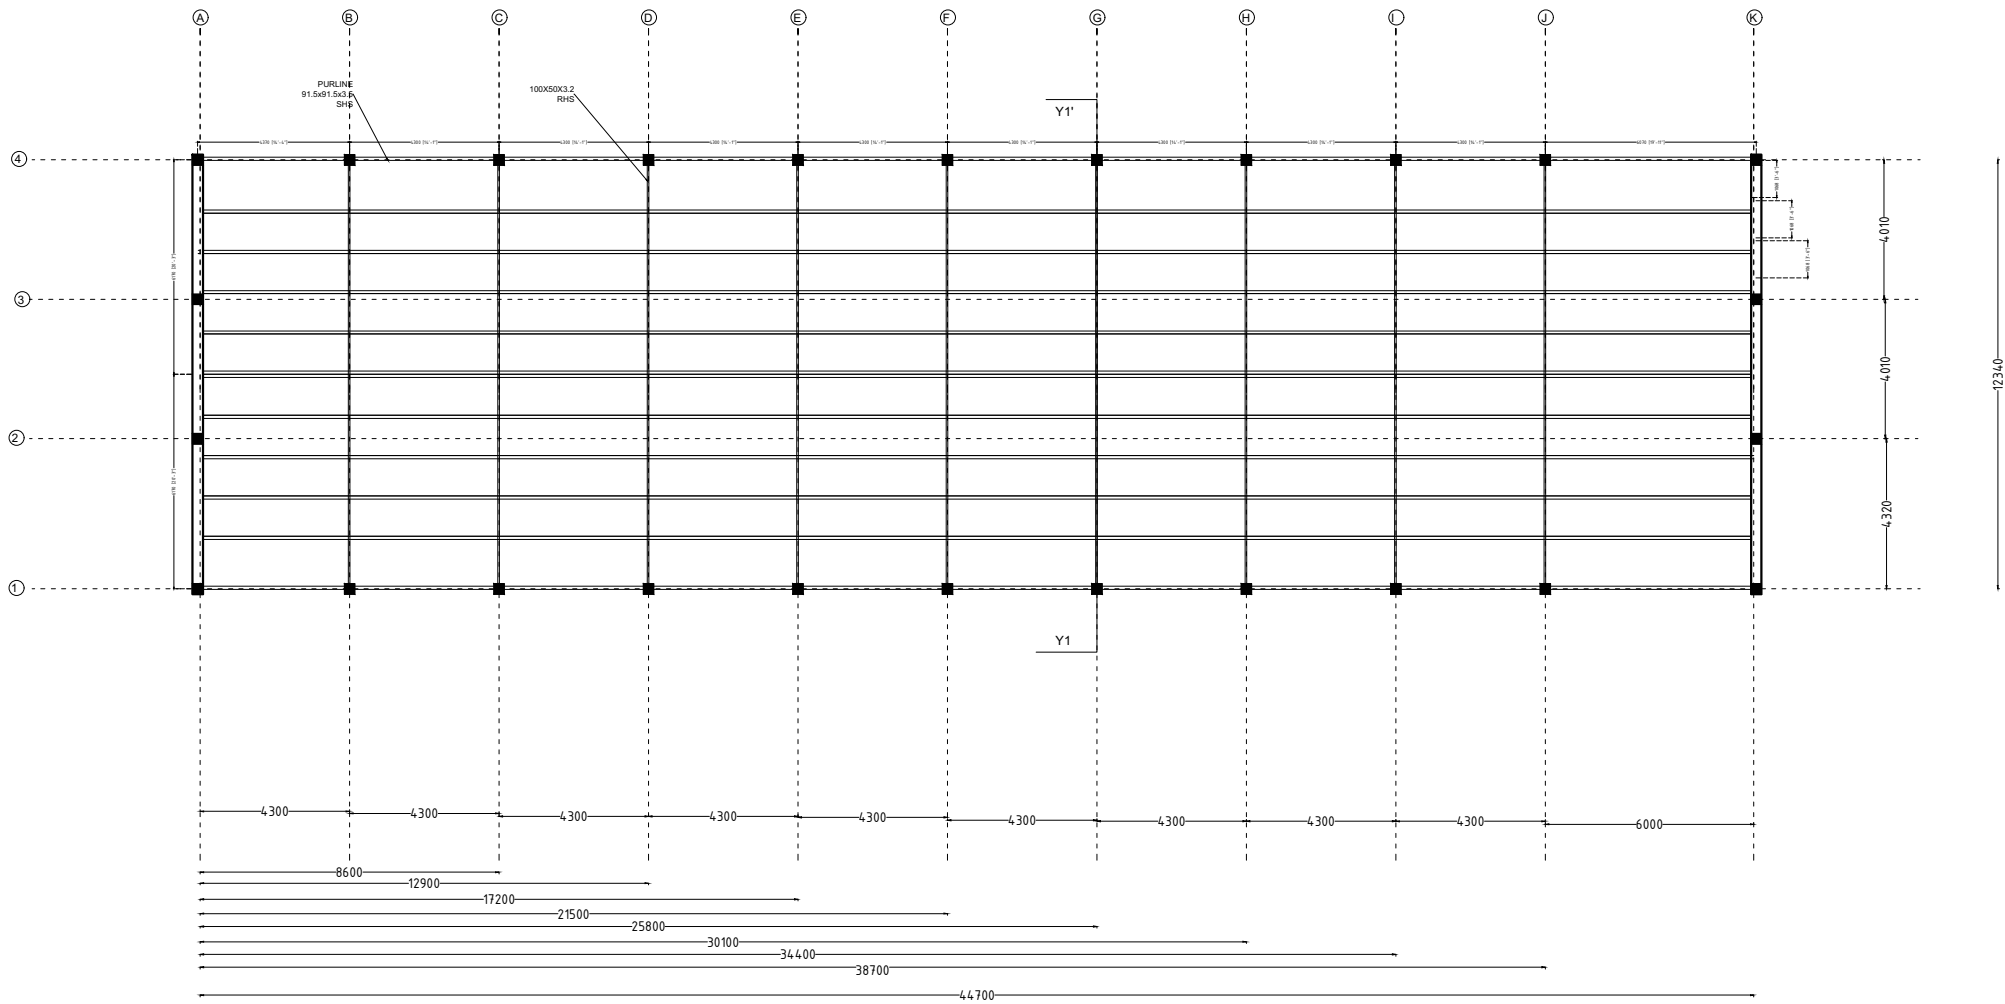


PLAN OF ROOF LVL.

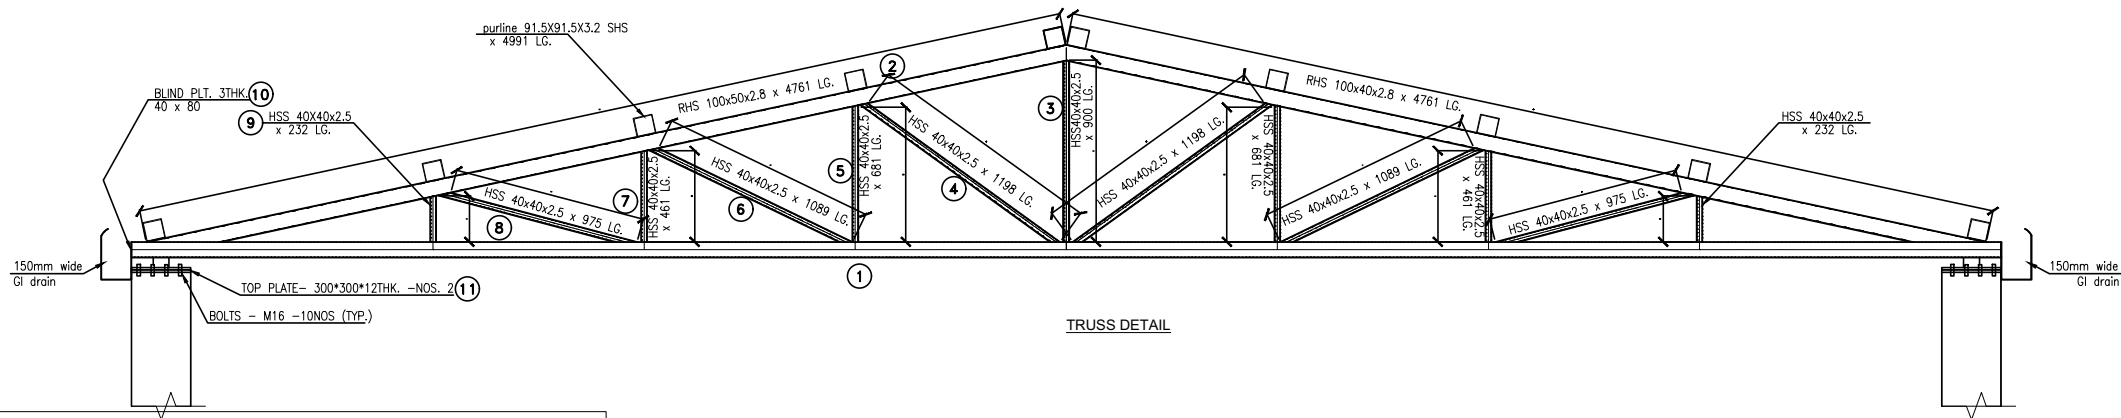

TRUSS DETAIL

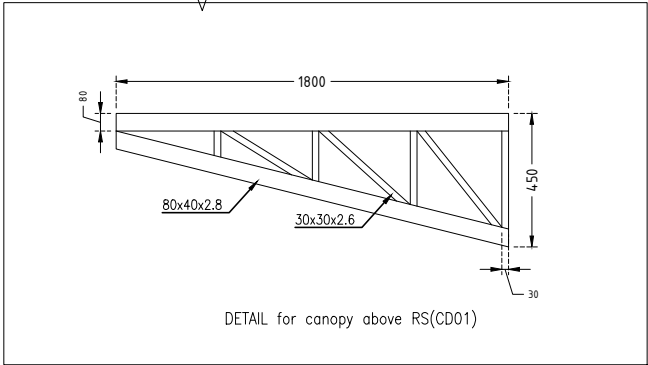

DETAIL for canopy above RS(CD01)

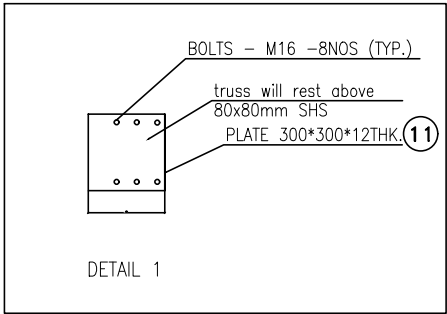


DETAIL 1

GENERAL NOTES

NOTES-

 1. USE - M 20 GRADE OF CONC. AS/IS 426-5000
 2. USE - FE 500 GRADE OF REINF. BY CLIENT
 3. PROVIDE CLEAR COVER TO MAIN REINF.
- FOUNDATION- 50MM
COLUMN - 40MM
BEAM - 25MM
SLAB - 20MM OR DIA OF BAR, WHICHEVER IS MORE,
R.C.C. WALL - 25MM
- 4.TIES SHOULD BE BEND INSIDE WITH 10# LENGTH IN BEAM & COLUMN



- 5.FOLLOW - IS-456-2000 FOR R.C.C. WORK
- 6.STRIPPING TIME FOR SHUTTERING / FORMWORK UNDER NORMAL CONDITION.

TYPE OF WORK	MINIMUM PERIOD BEFORE STRIKING FORM WORK
--------------	--

- | | |
|--|------------|
| a) VERTICAL FORMWORK TO COLUMN, WALLS, BEAM | 16-24 HOUR |
| b) SOFFITS FORMWORK TO SLABS (PROPS TO BE REFIXED- IMMEDIATELY AFTER REMOVAL OF FORMWORK) | 3 DAYS |
| c) SOFFIT FORMWORK TO BEAMS (PROPS TO BE REFIXED IMMEDIATELY AFTER REMOVAL OF FORMWORK) | 7DAYS |
| d) PROPS TO SLABS: | |
| 1) SPANNING UP TO 4.5M | 7DAYS |
| 2) SPANNING OVER 4.5M | 14 DAYS |
| e) PROPS TO BEAMS & ARCHES: | |
| 1) SPANNING UP TO 6M | 14DAYS |
| 2) SPANNING OVER 6M | 21DAYS |

7. CURING FOR R.C.C. MEMBER MINIMUM 14 DAYS CONTINUOUSLY PREFERABLE - 28 DAYS.
8. START EARLY CURING TO AVOID SRINKAGE CRACKS, WHEN CONCRETE APPEARS TO HARDEN.
- 9) PROVIDE FOLLOWING SLUMP IN CONCRETE GENERALLY.

- | | |
|---|---------|
| a) SHALLOW SECTIONS, PAYMENTS, MASS CONC. LIGTH REINFORCEMENT SECTION IN SLAB, BEAM, WALL, COLUMN | 25-75 |
| b) HEAVILY REINFORCEMENT SECTION IN SLAB | 50-100 |
| c) HEAVILY REINFORCEMENT SECTION IN BEAMS, WALLS, COLUMNS SLIPFORM, OR PUMPED CONC. | 75-100 |
| d) TRENCH FILL, PILLING, PUMPED CONC. | 100-150 |
- 10) PROVIDE LAP/ DEVELOPEMENT LENGTH IN REINFORCEMENT BARS GRADE OF CONC.

M20- 47Ø
M25-41Ø
M30-38Ø

- 11) REFER RELEVANT DRG. WITH THIS DRG.
- 12) AVOID CORE CUTING.

DRG NO:	SHEET NO:	REV.	SCALE:
DP0001 DRG CL 01 108	8 OF 9	R0	NTS
DESIGNED:	DRAWN:	CHECKED:	VERIFIED:
UPENDRA SINGH	SIMRAN SONI	UPENDRA SINGH	ADMIN
ISSUED FOR:	UNIT:	DATE:	
TENDOR PURPOSE	MILIMETER	12.05.2022	


This drawing is the property of HUP DESIGN and is to be used only for the purpose for which it was lent and must not be in any way detrimental to the interest of the company and is subject to return on demand

SWATI Architecture landscape interior
ARCHITECTS | PLANERS | ENGINEERING | INTERIOR DESIGN
282 , tulip , A block , Talpuri International colony , Bhilai , C.G. Email - swati.arch@outlook.com

CHHATTISGARH STATE MINOR FOREST PRODUSE

INCUBATION CENTER AT DEOBHOG GARIYABAND


WAREHOUSE UNIT
TRUSS DETAIL

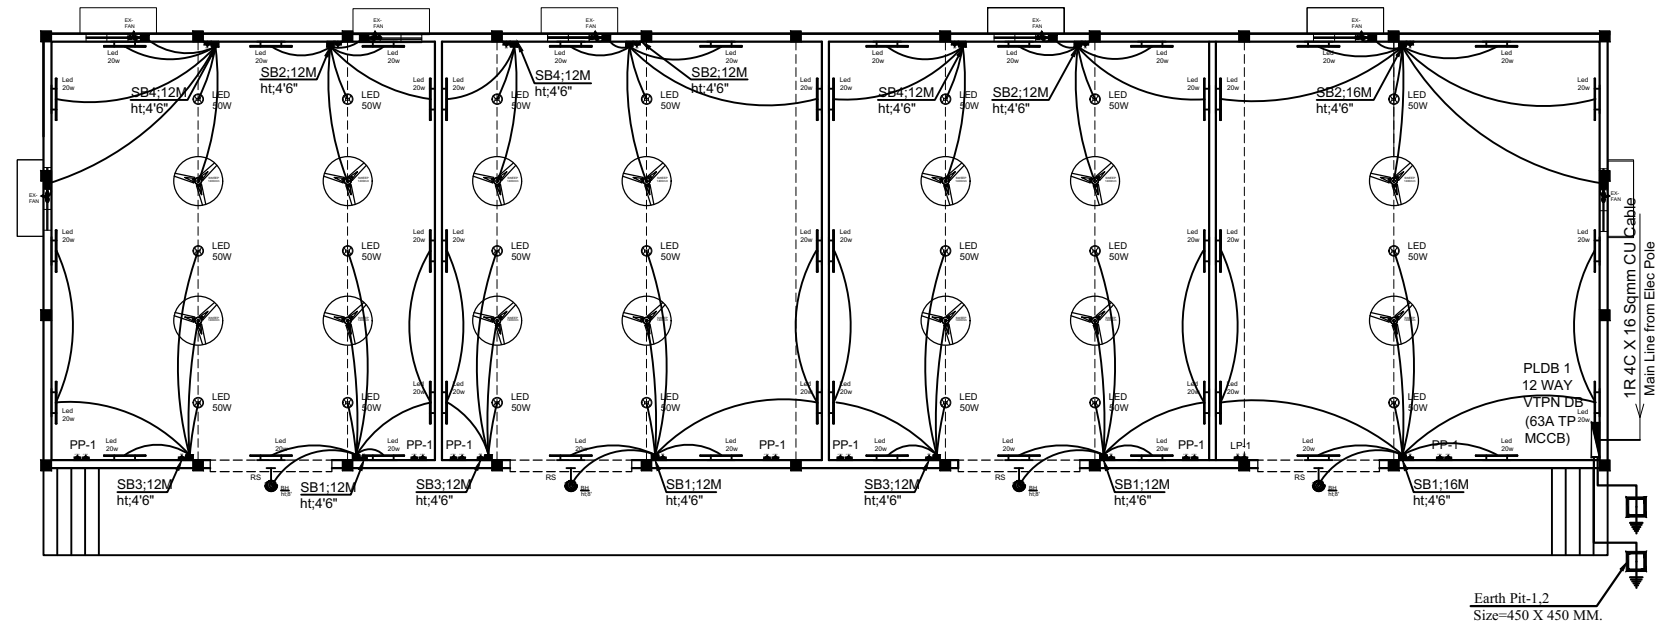


ELECTRICAL LAYOUT OF WAREHOUSE

01	LED 50W	50W FLOOD LIGHT (HIGH BAY)	21 No.
02	WALL LIGHT	WALL LIGHT	04 No.
03	PP-1	16A SWITCH SOCKET	14 No.
04	LP-1	6A SWITCH SOCKET	02 No.
05	4WAY SPN DB	4WAY SPN DB	00 No.
06	PLDB 1	12 WAY VTPN DB	01 No.
07	1400 mm Ceiling Fan	1400 mm Ceiling Fan	14 No.
08	20w Led Tube Light	20w Led Tube Light	44 No.
09	450 mm Ex Fan	450 mm Ex Fan	08 No.
10	LP-1	6A SWITCH SOCKET	14 No.
11	SB1	SWITCH BOARD	14 No.
12	6 X 6 SQMM CU WIRE	6 X 6 SQMM CU WIRE	
13	3 X 1.5 SQMM CU WIRE	3 X 1.5 SQMM CU WIRE	
14	Earth Pit-1	Size=450 X 450 MM.	2 SET

DRG NO:		SHEET NO:	REV.	SCALE:	SWATI Architecture landscape interior ARCHITECTS PLANERS ENGINEERING INTERIOR DESIGN 282 , tulip , A block , Talpuri International colony , Bhilai , C.G. Email - swati.arch@outlook.com
DP0001 DRG CL 01 108		9 OF 9	R0	NTS	
DESIGNED:	DRAWN:	CHECKED:	VERIFIED:	APPROVED:	CLIENT:
UPENDRA SINGH	SIMRAN SONI	UPENDRA SINGH	ADMIN	ADMIN	CHHATTISGARH STATE MINOR FOREST PRODUCE
ISSUED FOR:			UNIT:	DATE:	PROJECT:
TENDOR PURPOSE			MILIMETER	12.05.2022	INCUBATION CENTER AT DEOBHOG GARIYABAND
This drawing is the property of HUP DESIGN and is to be used only for the purpose for which it was lent and must not be in any way detrimental to the interest of the company and is subject to return on demand					TITLE:
					WAREHOUSE UNIT ELECTRICAL LAYOUT 67

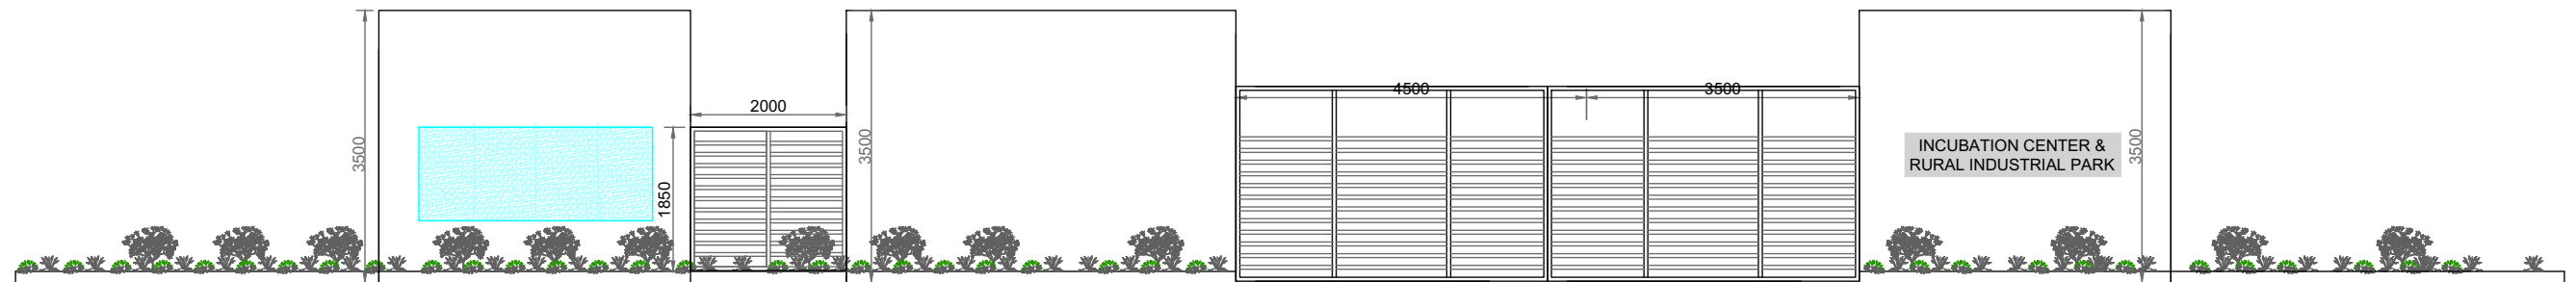


ELEVATION

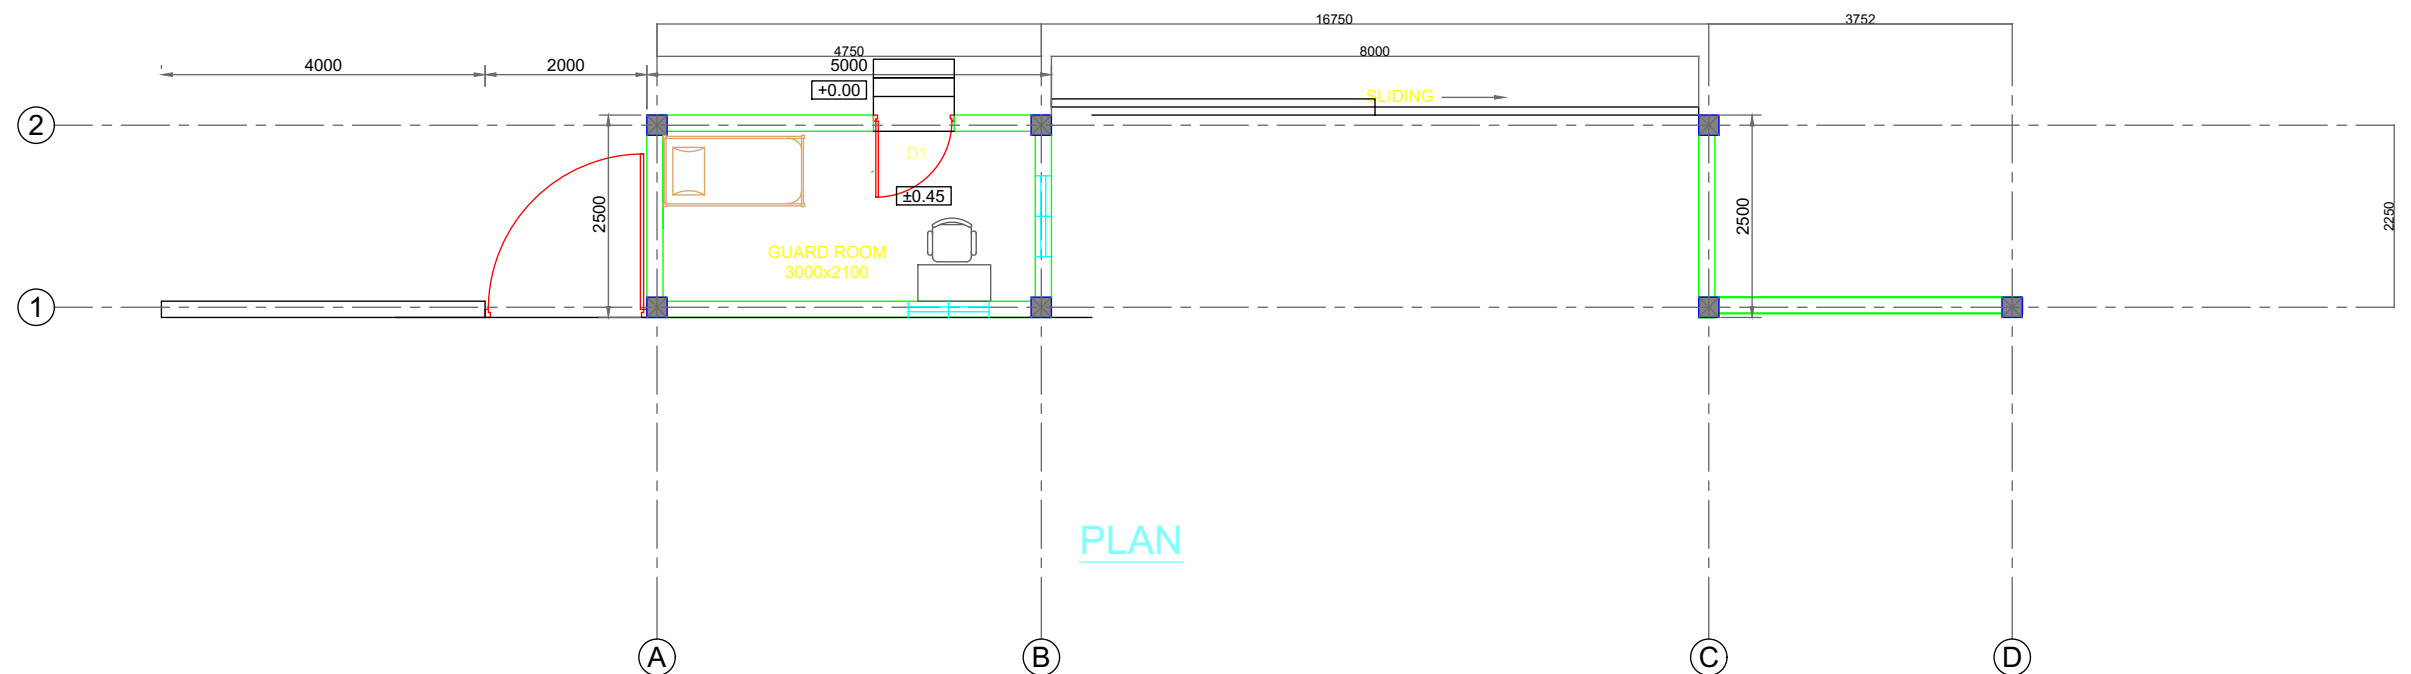


PLAN

DRG NO: SHEET NO: REV. SCALE:					SWATI Architecture landscape interior ARCHITECTS PLANERS ENGINEERING INTERIOR DESIGN 282 , tulip , A block , Talpuri International colony , Bhilai , C.G. Email - swati.arch@outlook.com			
DP0001 DRG CL 03 101 1 OF1 R0 NTS								
DESIGNED:		DRAWN:		CHECKED:	VERIFIED:	APPROVED:	CLIENT: CHHATTISGARH STATE MINOR FOREST PRODUSE	
UPENDRA SINGH SIMRAN SONI		UPENDRA SINGH		ADMIN		ADMIN		
ISSUED FOR:			TENDOR PURPOSE		UNIT:	DATE:	PROJECT:	INCUBATION CENTER AT DEOBHOG GARIYABAND
					MILIMETER	12.05.2022		
This drawing is the property of HUP DESIGN and is to be used only for the purpose for which it was lent and must not be in any way detrimental to the interest of the company and is subject to return on demand							TITLE:	ENTRY GATE UNIT PLAN

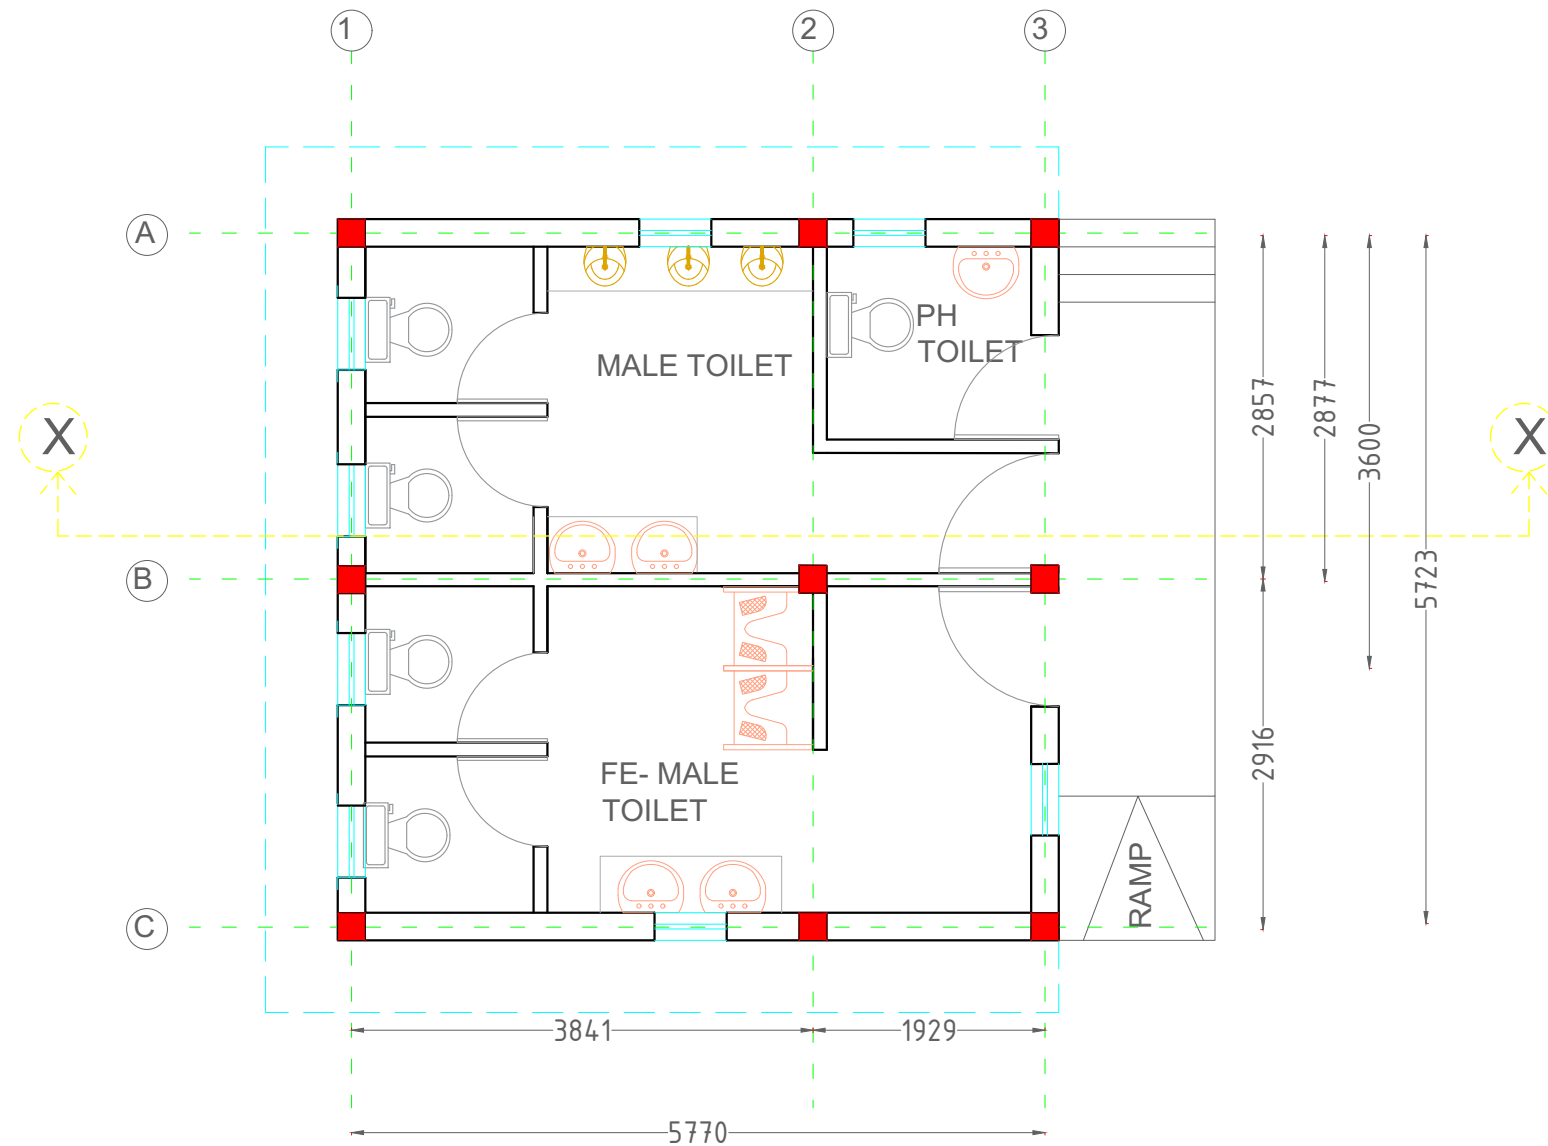


TOILET BLOCK

DRG NO: DP0001 DRG CL 02 202	SHEET NO: 1 OF 7	REV. R0	SCALE: NTS	SWATI Architecture landscape interior ARCHITECTS PLANERS ENGINEERING INTERIOR DESIGN 282 , tulip , A block , Talpuri International colony , Bhubai , C.G. Email - swati.arch@outlook.com	
DESIGNED: UPENDRA SINGH	DRAWN: SIMRAN SONI	CHECKED: UPENDRA SINGH	VERIFIED: ADMIN	APPROVED: ADMIN	CLIENT: CHHATTISGARH STATE MINOR FOREST PRODUCE
ISSUED FOR: TENDOR PURPOSE	UNIT: MILIMETER	DATE: 12.05.2022	PROJECT: INCUBATION CENTER AT DEOBHOG GARIYABAND		
This drawing is the property of HUP DESIGN and is to be used only for the purpose for which it was lent and must not be in any way detrimental to the interest of the company and is subject to return on demand				TITLE: TOILET UNIT PLAN LAYOUT	

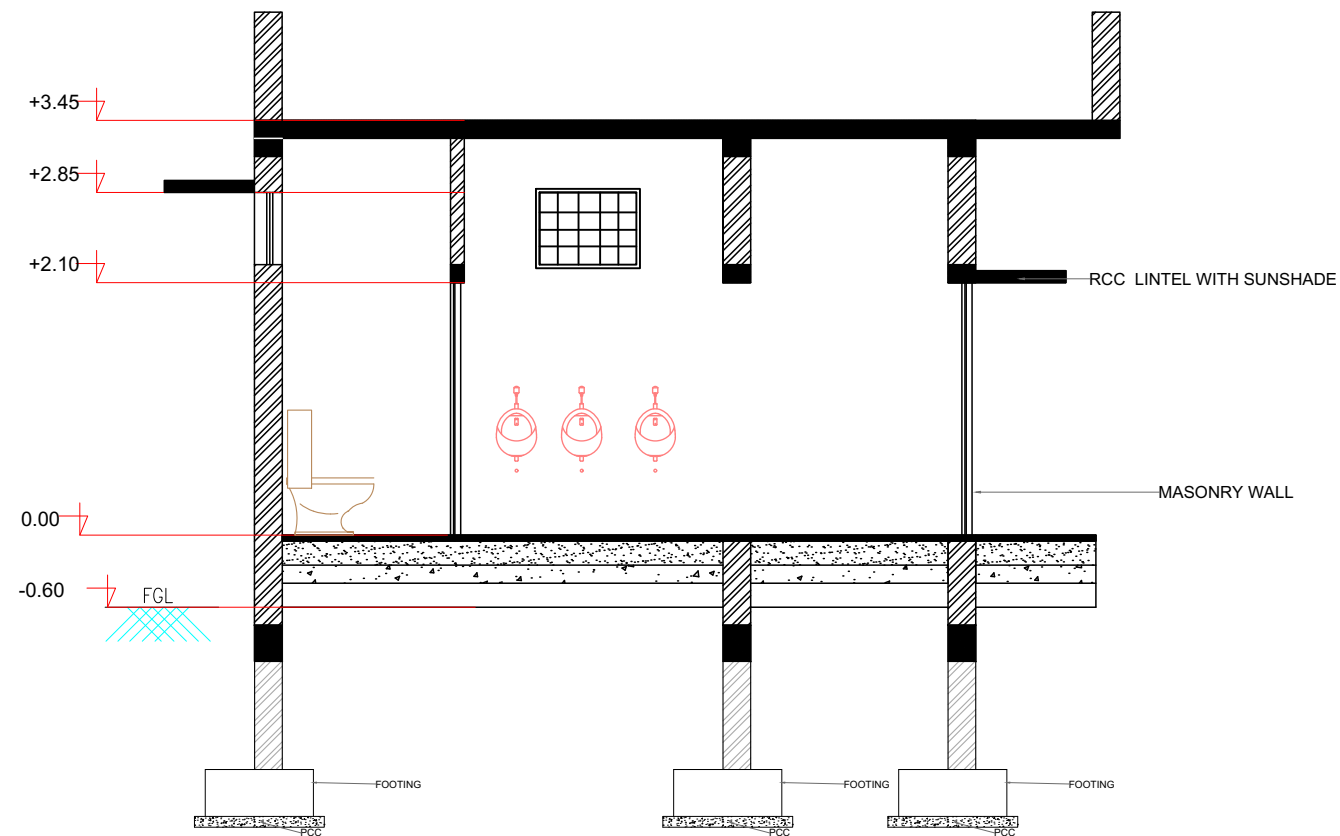


SECTION - XX'

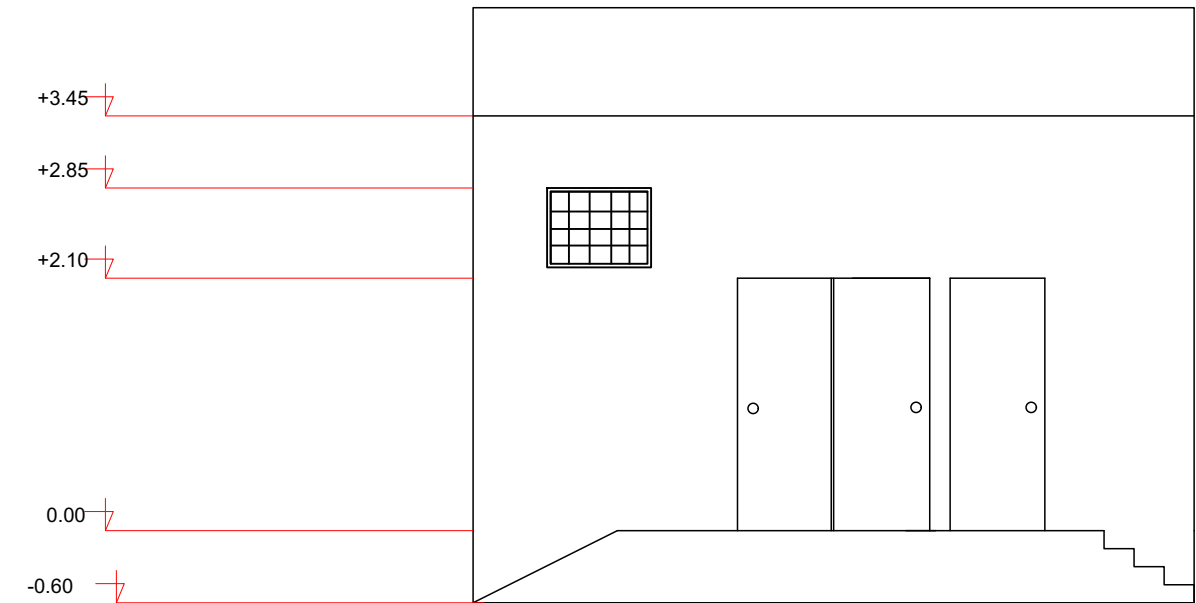


ELEVATION

DRG NO: DP0001 DRG CL 02 202	SHEET NO: 2 OF 7	REV. R0	SCALE: NTS	SWATI Architecture landscape interior ARCHITECTS PLANERS ENGINEERING INTERIOR DESIGN 282 , tulip , A block , Talpuri International colony , Bhilai , C.G. Email - swati.arch@outlook.com	
DESIGNED: UPENDRA SINGH	DRAWN: SIMRAN SONI	CHECKED: UPENDRA SINGH	VERIFIED: ADMIN	APPROVED: ADMIN	CLIENT: CHHATTISGARH STATE MINOR FOREST PRODUCE
ISSUED FOR: TENDOR PURPOSE		UNIT: MILIMETER	DATE: 12.05.2022	PROJECT: INCUBATION CENTER AT DEOBHOG GARIYABAND	
This drawing is the property of HUP DESIGN and is to be used only for the purpose for which it was lent and must not be in any way detrimental to the interest of the company and is subject to return on demand				TITLE: TOILET UNIT SECTION / ELEVATION	

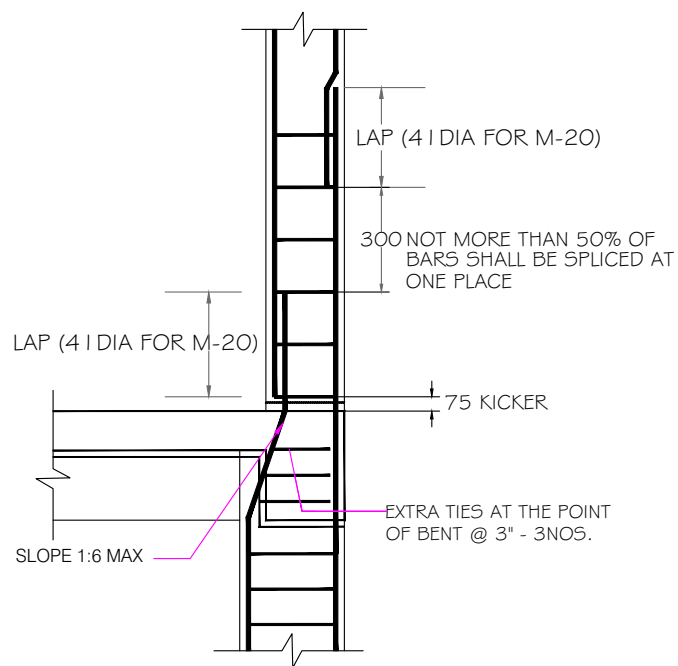

COLUMN DETAIL

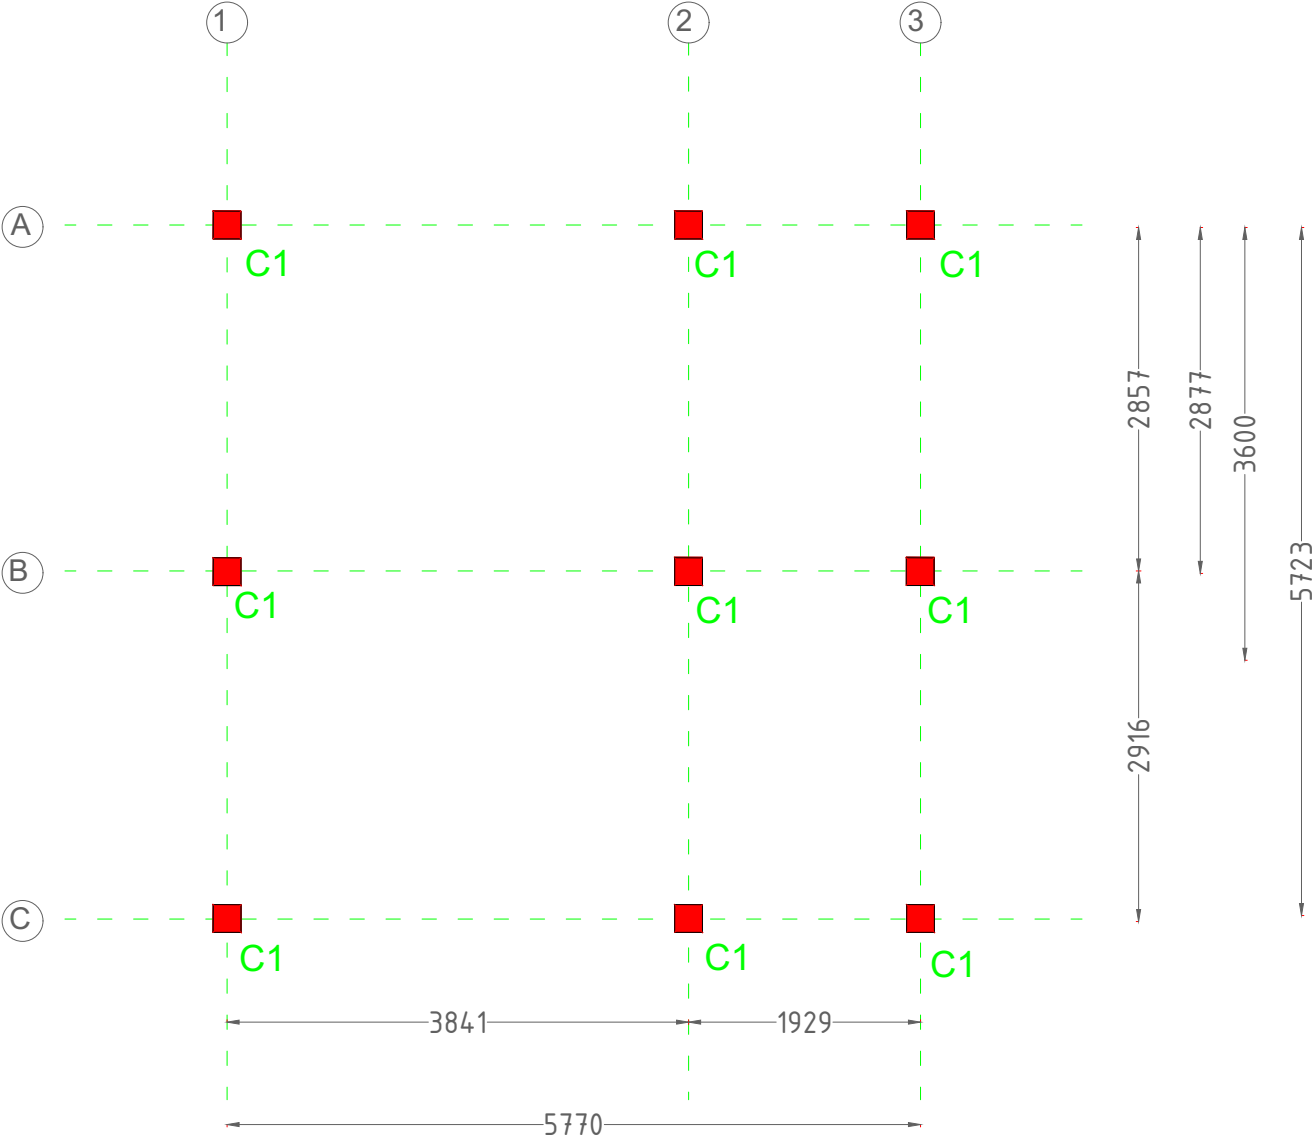


COLUMN LAYOUT


TYPICAL COLUMN DETAIL'S

COLUMN NAME	Pile/col detail	STIRRUPS	REMARKS
C1	230 230 4-T12 T8@ 200 c/c 1-Tie TERMINATE AT GROUND LVL		


DRG NO: DP0001 DRG CL 02 202	SHEET NO: 3 OF7	REV: R0	SCALE: NTS	SWATI Architecture landscape interior ARCHITECTS PLANERS ENGINEERING INTERIOR DESIGN 282 , tulip , A block , Talpuri International colony , Bhubai , C.G. Email - swati.arch@outlook.com	
DESIGNED: UPENDRA SINGH	DRAWN: SIMRAN SONI	CHECKED: UPENDRA SINGH	VERIFIED: ADMIN	APPROVED: ADMIN	CLIENT: CHHATTISGARH STATE MINOR FOREST PRODUSE
ISSUED FOR: TENDOR PURPOSE		UNIT: MILIMETER	DATE: 12.05.2022	PROJECT: INCUBATION CENTER AT DEOBHOG GARIYABAND	
This drawing is the property of HUP DESIGN and is to be used only for the purpose for which it was lent and must not be in any way detrimental to the interest of the company and is subject to return on demand				TITLE: TOILET UNIT COLUMN LAYOUT	

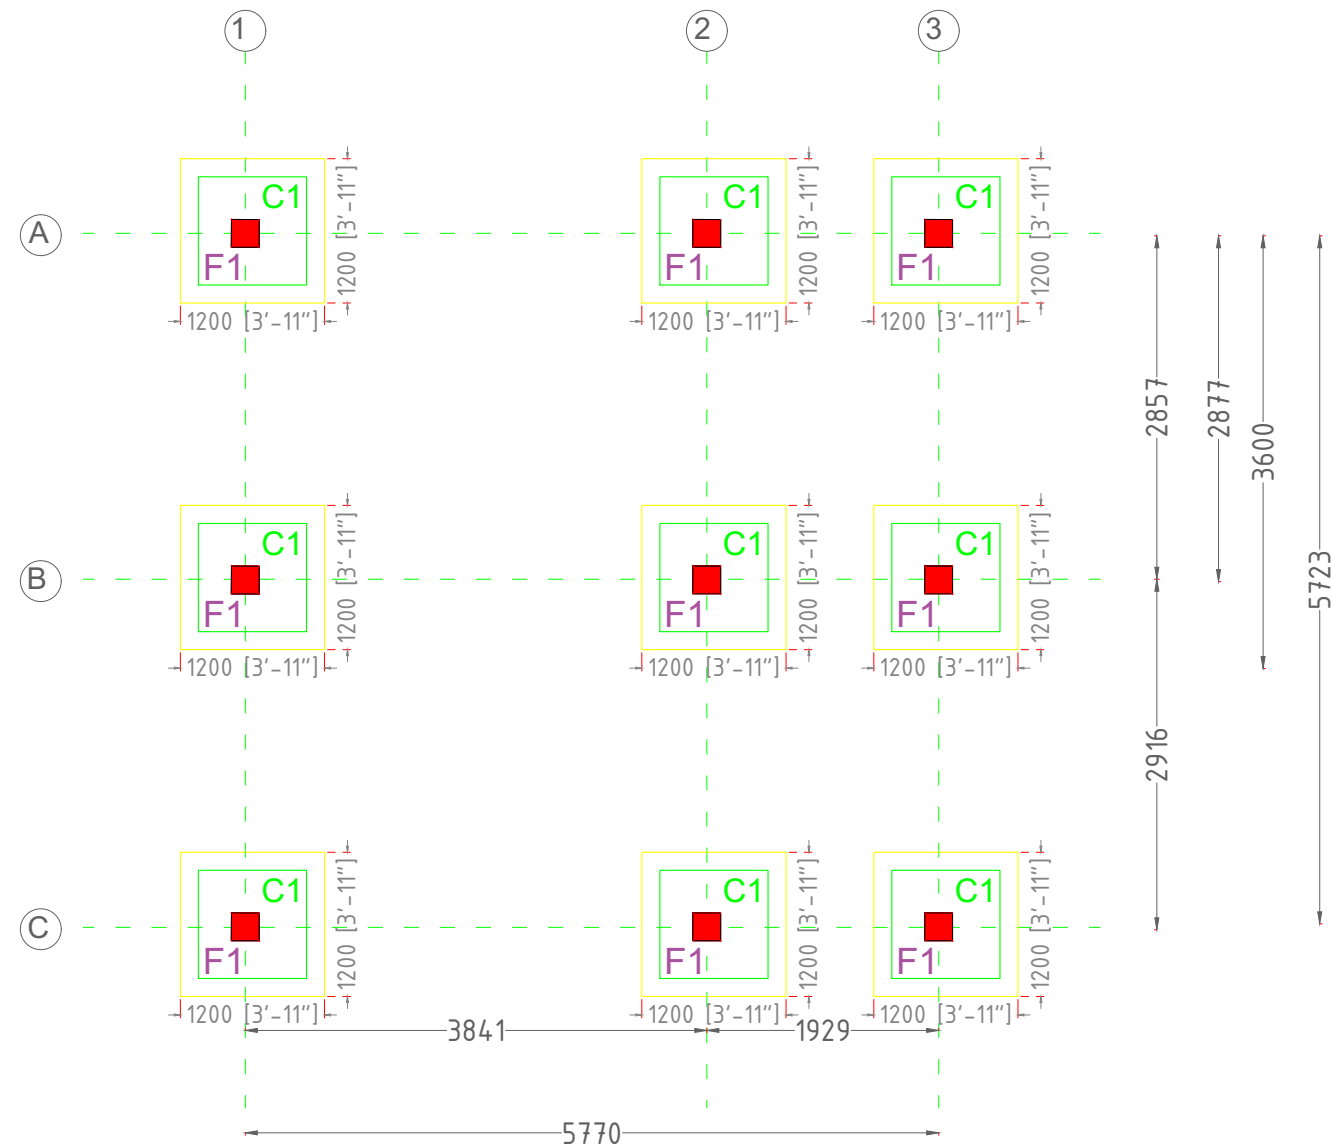

FOOTING LAYOUT

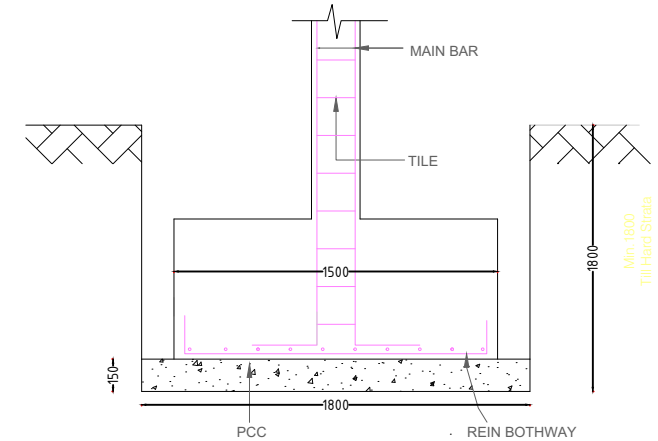


TYPICAL FOOTING SECTION (1-1')

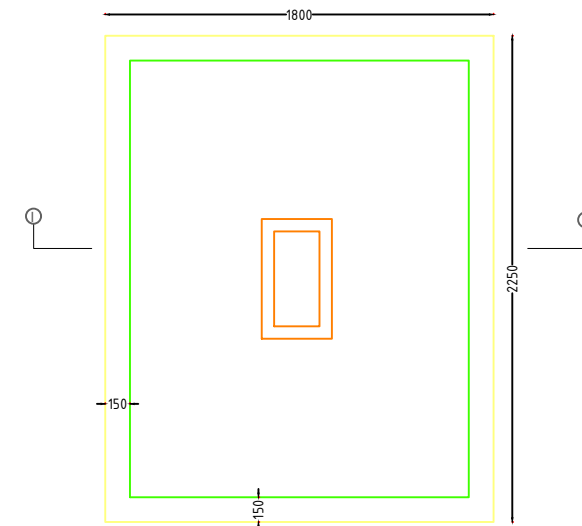


TYPICAL FOOTING PLAN

FOOTING SCHEDULE FE500 AND M20							
Footings	Column	PCC Size	Footing Size	Total	Steel	Steel	Remarks
	Nos	X - Y mm	X - Y mm	Depth mm	to X mm	to Y mm	
F1	C1	1200 X 1200	900 X 900	230	T8@200C/C	T8@ 200 C/C	Bottom bars only

DRG NO: DP0001 DRG CL 02 202	SHEET NO: 4 OF 7	REV. R0	SCALE: NTS	SWATI Architecture landscape interior ARCHITECTS PLANERS ENGINEERING INTERIOR DESIGN 282 , tulip , A block , Talpuri International colony , Bhilai , C.G. Email - swati.arch@outlook.com			
DESIGNED: UPENDRA SINGH	DRAWN: SIMRAN SONI	CHECKED: UPENDRA SINGH	VERIFIED: ADMIN	APPROVED: ADMIN	CLIENT:	CHHATTISGARH STATE MINOR FOREST PRODUSE	
ISSUED FOR: TENDOR PURPOSE			UNIT: MILIMETER	DATE: 12.05.2022	PROJECT:	INCUBATION CENTER AT DEOBHOG GARIYABAND	
This drawing is the property of HUP DESIGN and is to be used only for the purpose for which it was lent and must not be in any way detrimental to the interest of the company and is subject to return on demand					TITLE:	TOILET UNIT FOOTING LAYOUT	

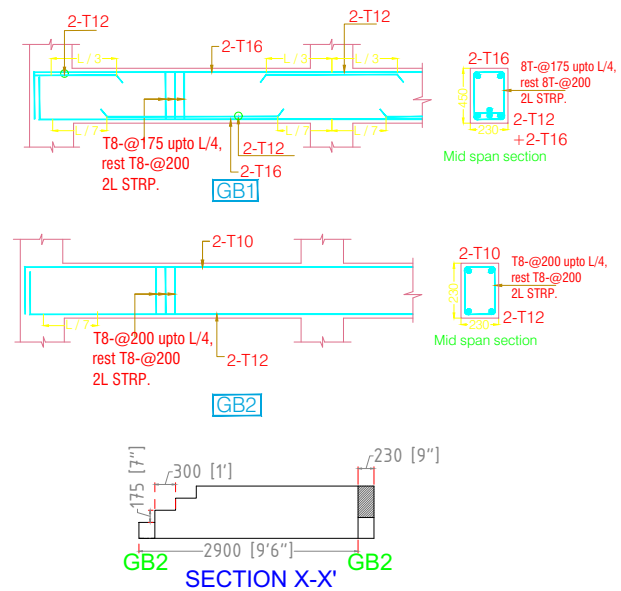

GROUND BEAM SECTIONAL DETAIL

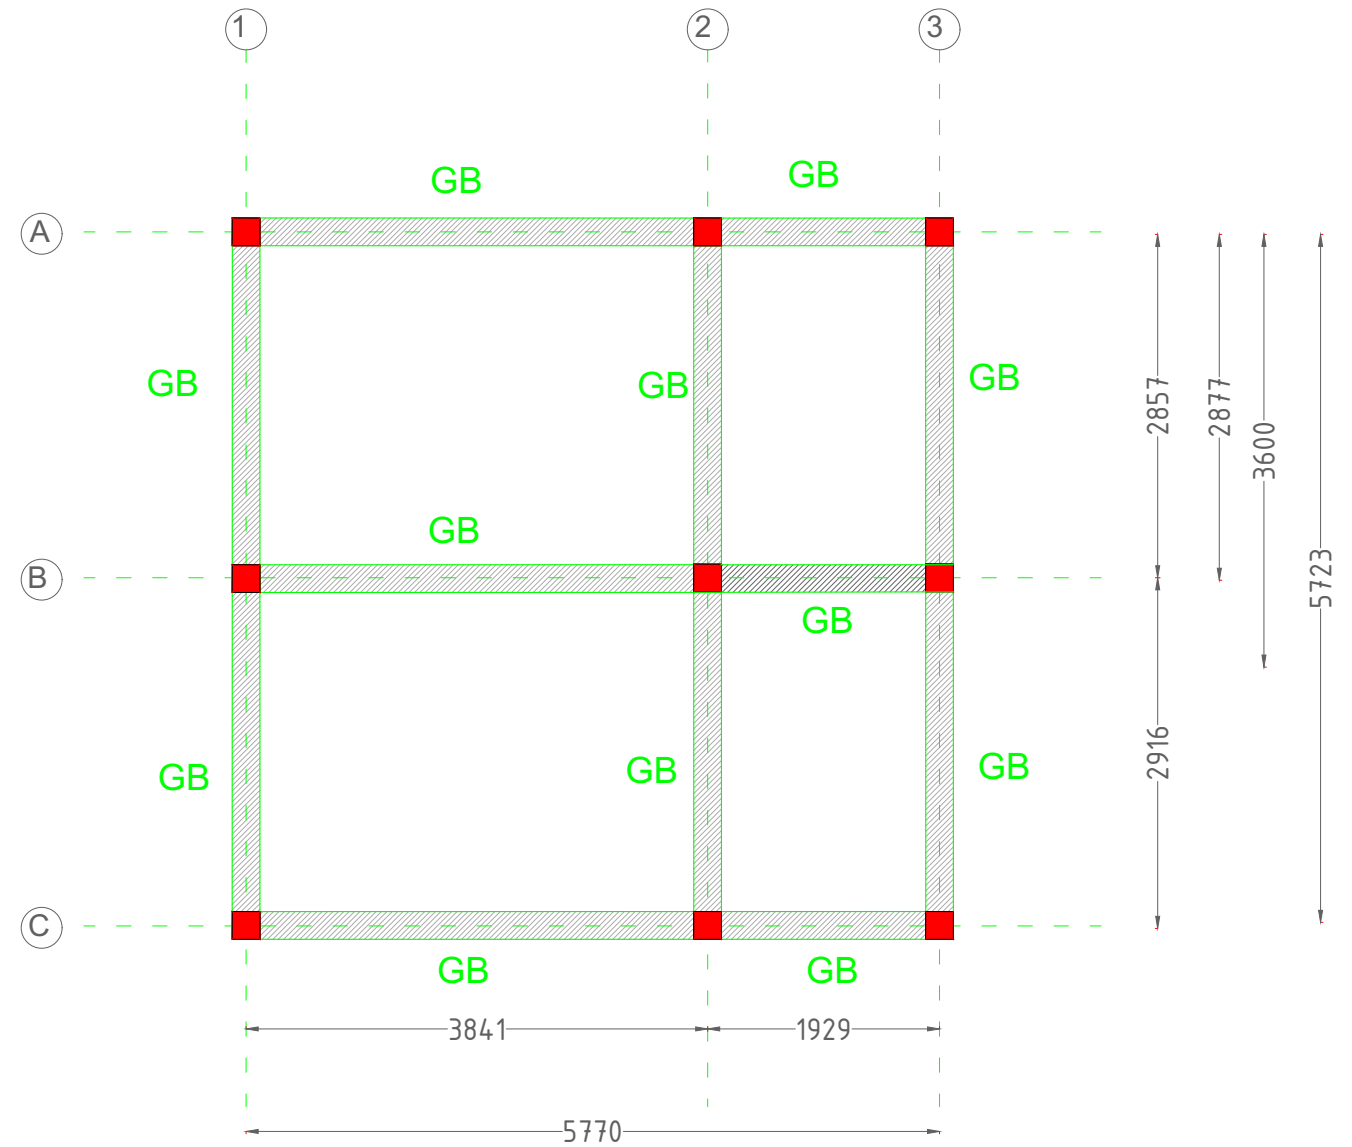

GROUND BEAM LAYOUT

BEAM SCHEDULE FOR GROUND/ PLINTH LVL.


Beam ID	Beam Size	Top Reinforcement	Bottom Reinforcement	Notes
GB1	230X230	2-T12	2-T10	T8 @200C/C T8 @200C/C T8 @200C/C SLAB THK. INCLUDED

SLAB SCHEDULE FOR GROUND FLOOR LVL.


Slab Name	Thickness (mm)	Reinforcement		Remarks
		Main Steel	Other Steel	
S1	150 (MESH)	T8 @ 200 c/c	T8 @ 200 c/c	All straight

DRG NO: DP0001 DRG CL 02 202	SHEET NO: 4 OF 7	REV. R0	SCALE: NTS	SWATI Architecture landscape interior ARCHITECTS PLANERS ENGINEERING INTERIOR DESIGN 282, tulip, A block, Talpuri International colony, Bhubaneswar, C.G. Email - swati.arch@outlook.com	
DESIGNED: UPENDRA SINGH	DRAWN: SIMRAN SONI	CHECKED: UPENDRA SINGH	VERIFIED: ADMIN	APPROVED: ADMIN	CLIENT: CHHATTISGARH STATE MINOR FOREST PRODUCE
ISSUED FOR: TENDOR PURPOSE		UNIT: MILIMETER	DATE: 12.05.2022	PROJECT: INCUBATION CENTER AT DEOBHOG GARIYABAND	TITLE: TOILET UNIT GROUND BEAM LAYOUT

This drawing is the property of HUP DESIGN and is to be used only for the purpose for which it was lent and must not be in any way detrimental to the interest of the company and is subject to return on demand

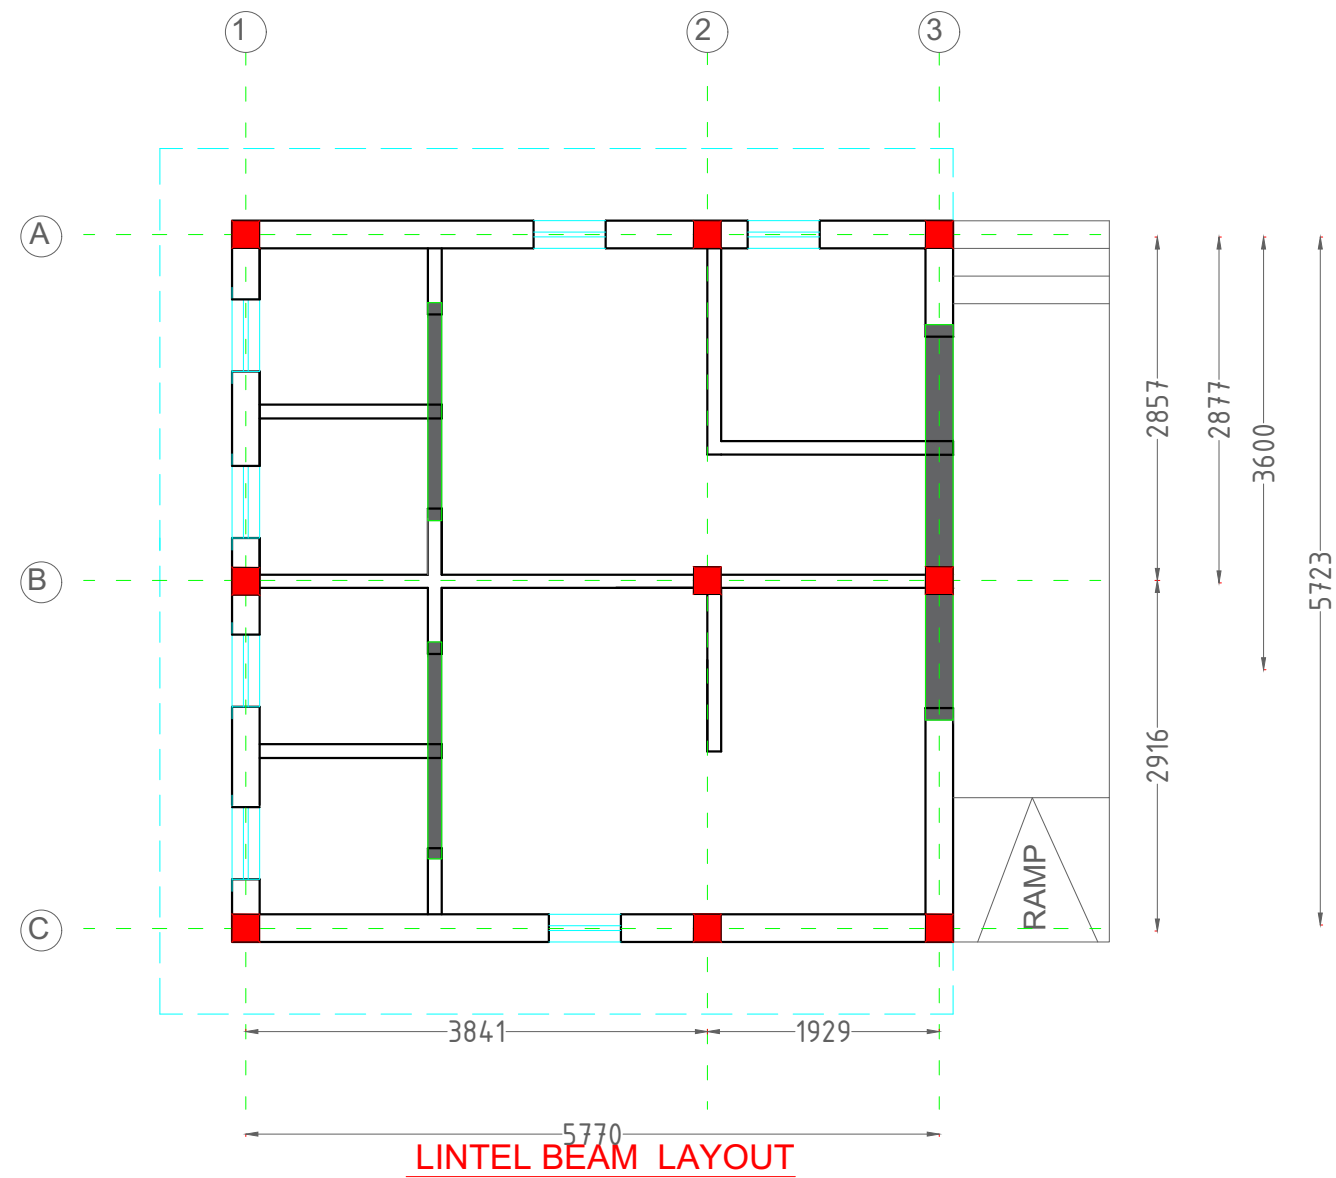


DRG NO: DP0001 DRG CL 02 202	SHEET NO: 6 OF 7	REV. R0	SCALE: NTS	SWATI Architecture landscape interior ARCHITECTS PLANERS ENGINEERING INTERIOR DESIGN 282 , tulip , A block , Talpuri International colony , Bhubaneswar , C.G. Email - swati.arch@outlook.com	
DESIGNED: UPENDRA SINGH	DRAWN: SIMRAN SONI	CHECKED: UPENDRA SINGH	VERIFIED: ADMIN	APPROVED: ADMIN	CLIENT: CHHATTISGARH STATE MINOR FOREST PRODUCE
ISSUED FOR: TENDOR PURPOSE		UNIT: MILIMETER	DATE: 12.05.2022	PROJECT: INCUBATION CENTER AT DEOBHOG GARIYABAND	
This drawing is the property of HUP DESIGN and is to be used only for the purpose for which it was lent and must not be in any way detrimental to the interest of the company and is subject to return on demand				TITLE: TOILET UNIT LINTEL BEAM	

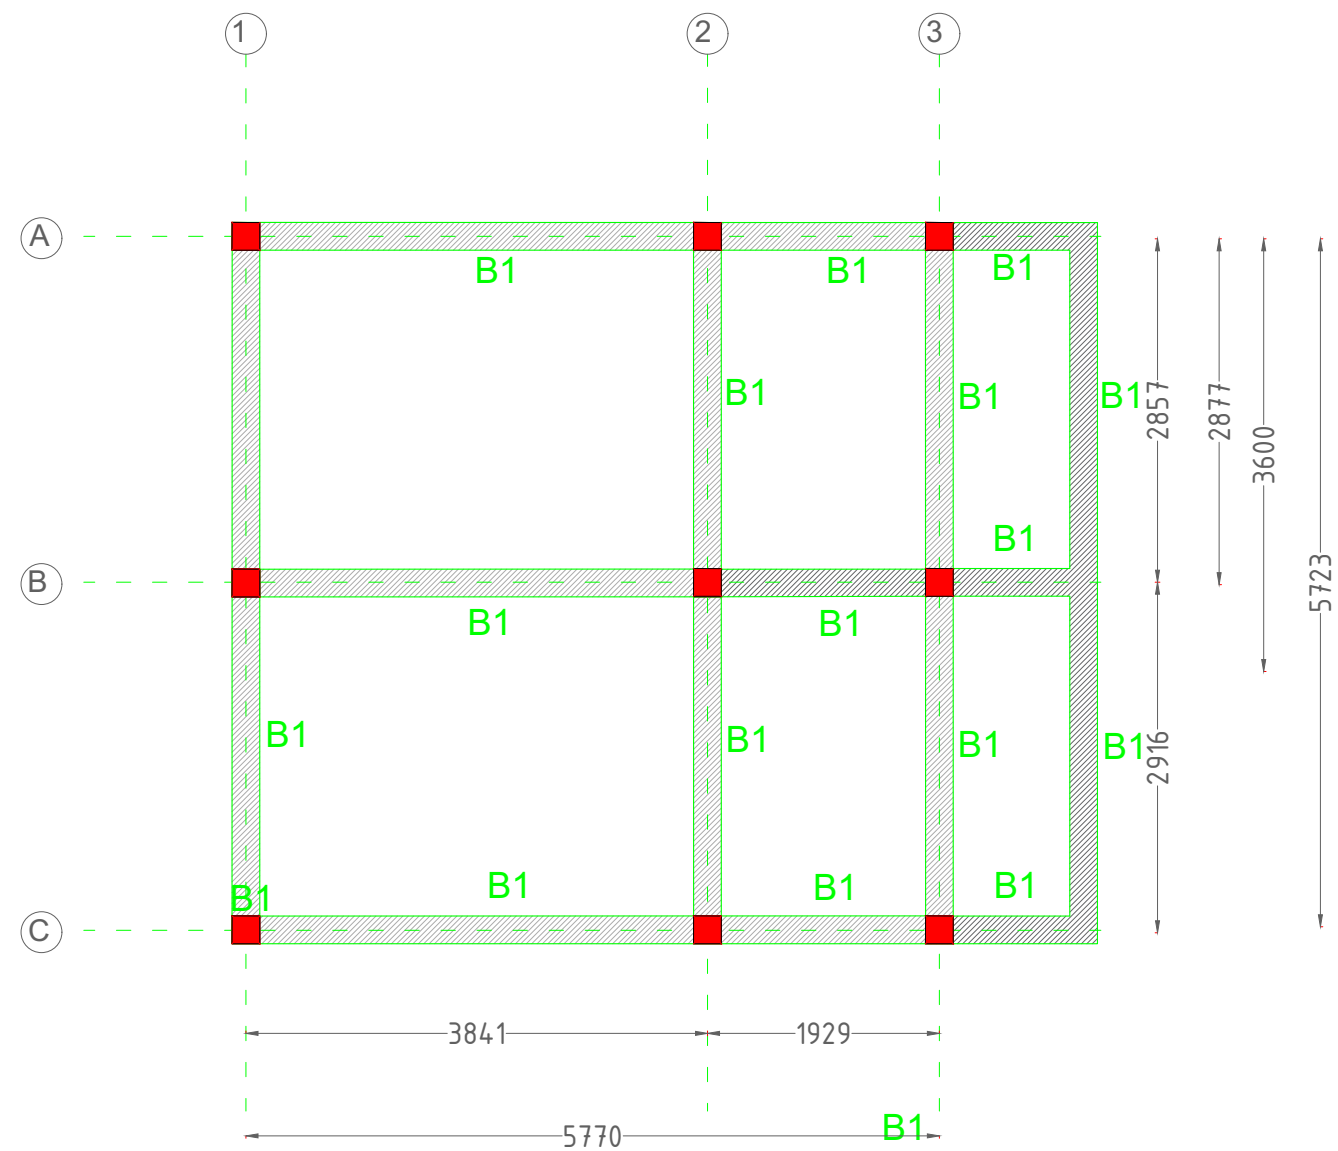

BEAM LAYOUT(TOP LEVEL)









DRG NO: DP0001 DRG CL 02 202	SHEET NO: 7 OF 7	REV. R0	SCALE: NTS	SWATI Architecture landscape interior ARCHITECTS PLANERS ENGINEERING INTERIOR DESIGN 282 , tulip , A block , Talpuri International colony , Bhubai , C.G. Email - swati.arch@outlook.com	
DESIGNED: UPENDRA SINGH	DRAWN: SIMRAN SONI	CHECKED: UPENDRA SINGH	VERIFIED: ADMIN	APPROVED: ADMIN	CLIENT: CHHATTISGARH STATE MINOR FOREST PRODUCE
ISSUED FOR: TENDOR PURPOSE		UNIT: MILIMETER	DATE: 12.05.2022	PROJECT: INCUBATION CENTER AT DEOBHOG GARIYABAND	
This drawing is the property of HUP DESIGN and is to be used only for the purpose for which it was lent and must not be in any way detrimental to the interest of the company and is subject to return on demand				TITLE: TOILET UNIT BEAM TOP LEVEL LAYOUT	

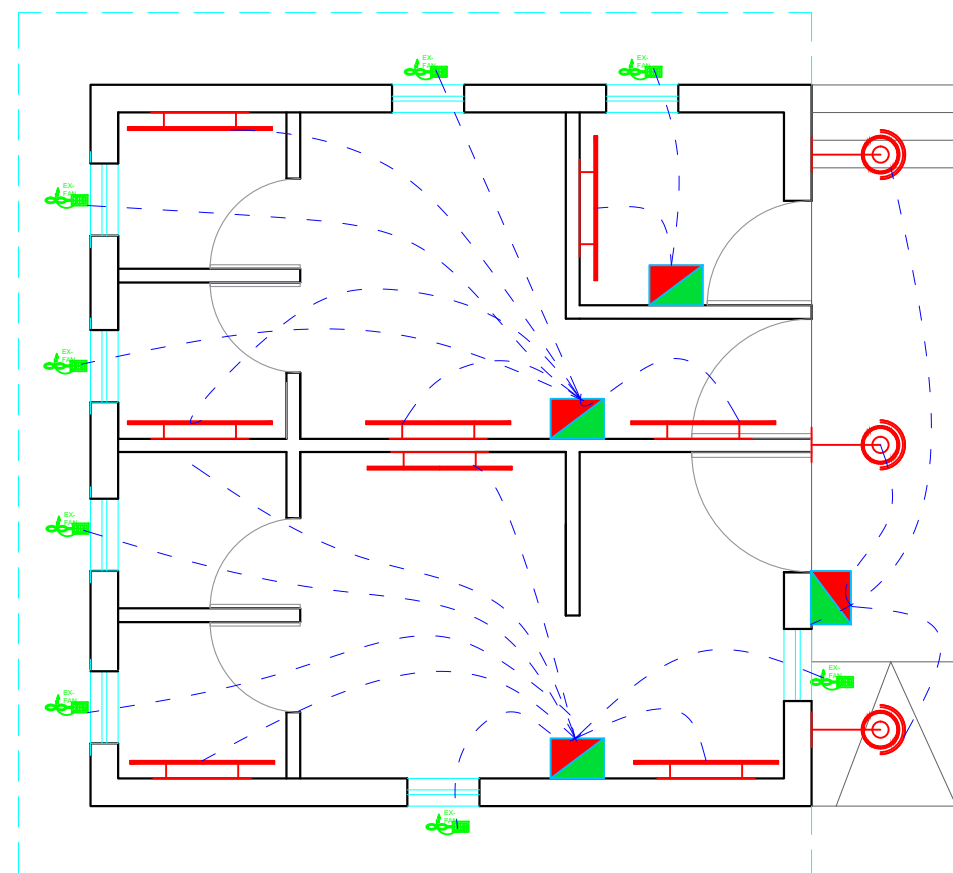

	WALL LIGHT
	20w Led Tube Light
	450 mm Ex Fan
	SWITCH BOARD

ELECTRICAL LAYOUT

DRG NO: DP0001 DRG CL 02 202	SHEET NO: 7 OF 7	REV. R0	SCALE: NTS	SWATI Architecture landscape interior ARCHITECTS PLANERS ENGINEERING INTERIOR DESIGN 282 , tulip , A block , Talpuri International colony , Bhubai , C.G. Email - swati.arch@outlook.com	
DESIGNED: UPENDRA SINGH	DRAWN: SIMRAN SONI	CHECKED: UPENDRA SINGH	VERIFIED: ADMIN	APPROVED: ADMIN	CLIENT: CHHATTISGARH STATE MINOR FOREST PRODUCE
ISSUED FOR: TENDOR PURPOSE		UNIT: MILIMETER	DATE: 12.05.2022	PROJECT: INCUBATION CENTER AT DEOBHOG GARIYABAND	TITLE: TOILET UNIT ELECTRICAL LAYOUT
This drawing is the property of HUP DESIGN and is to be used only for the purpose for which it was lent and must not be in any way detrimental to the interest of the company and is subject to return on demand					

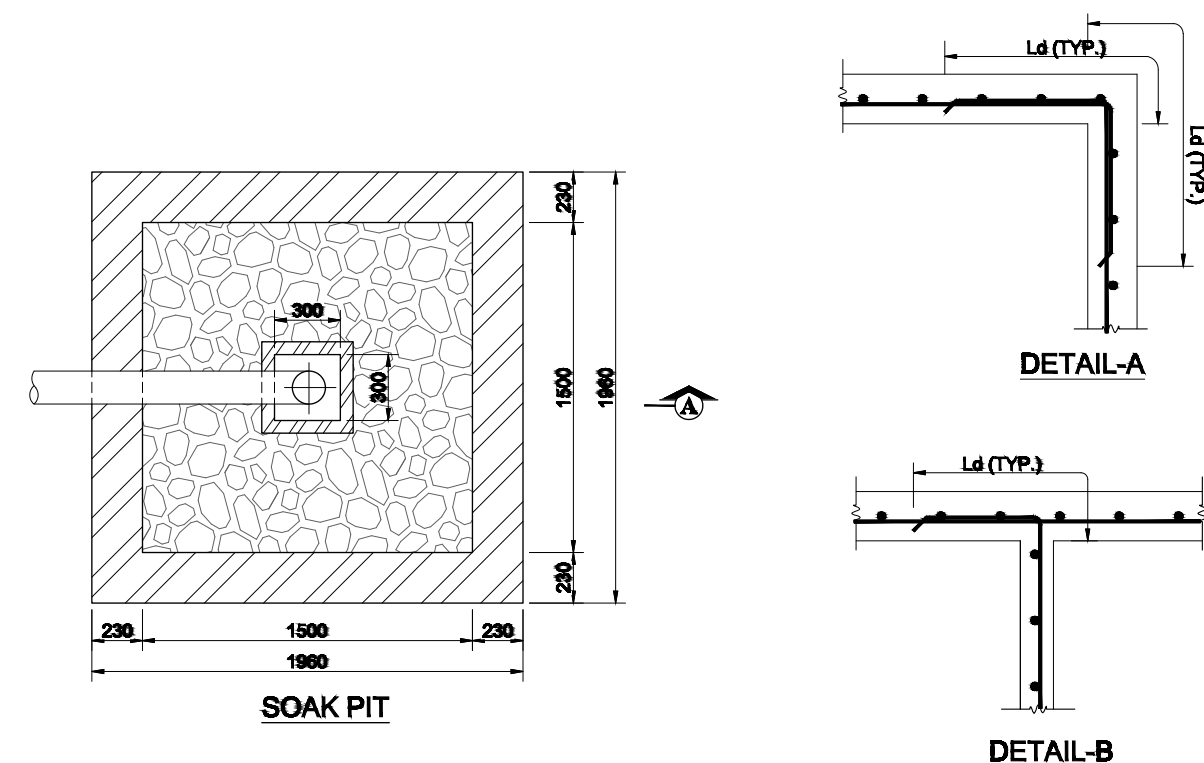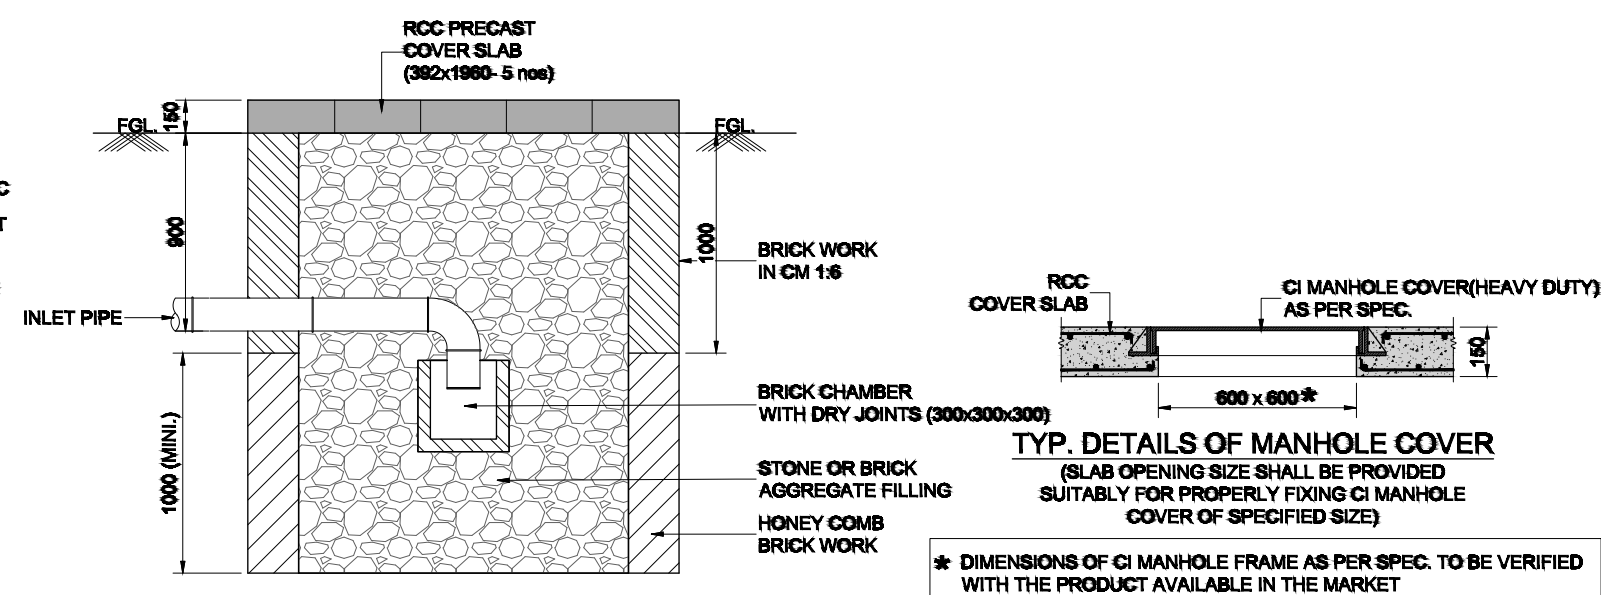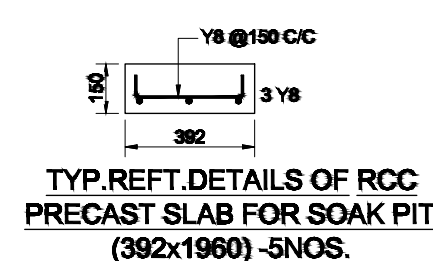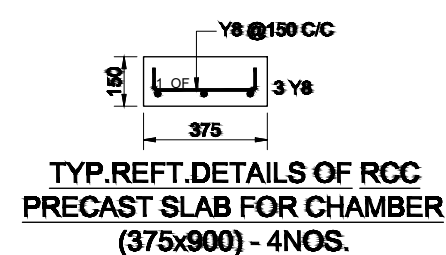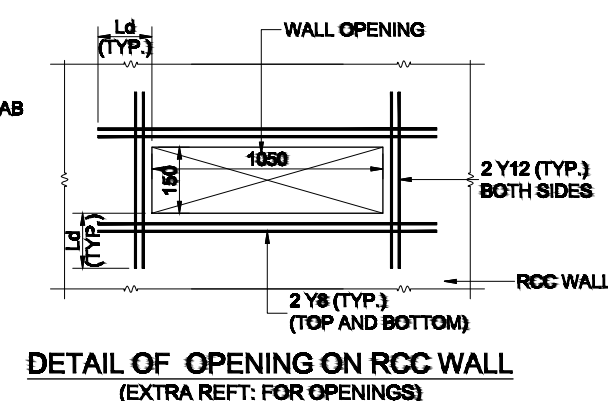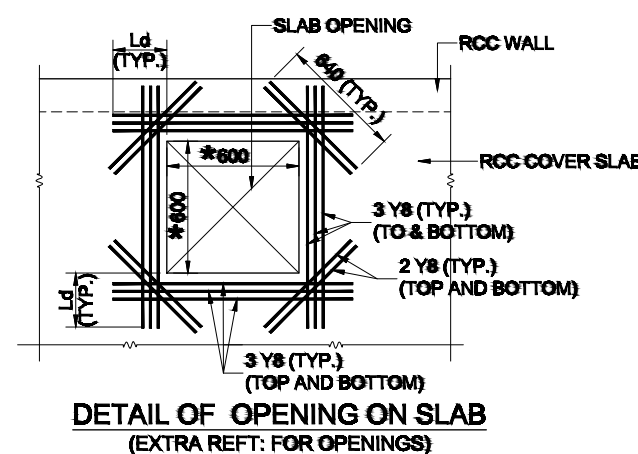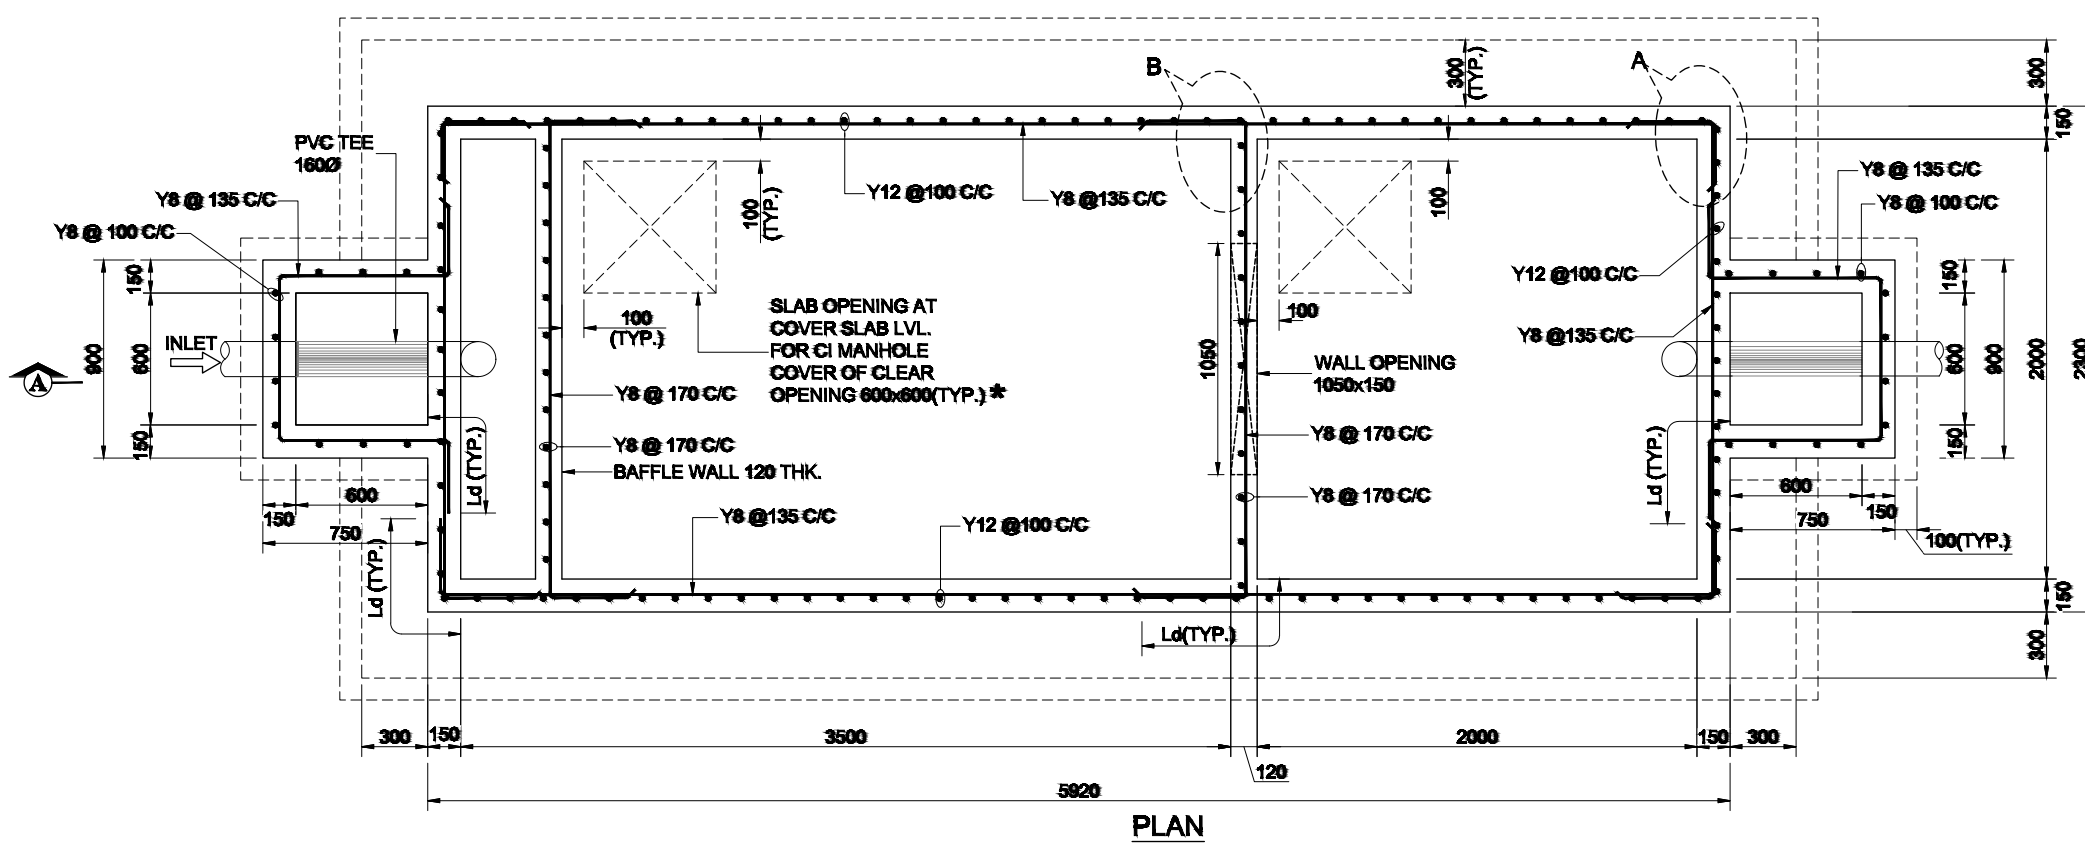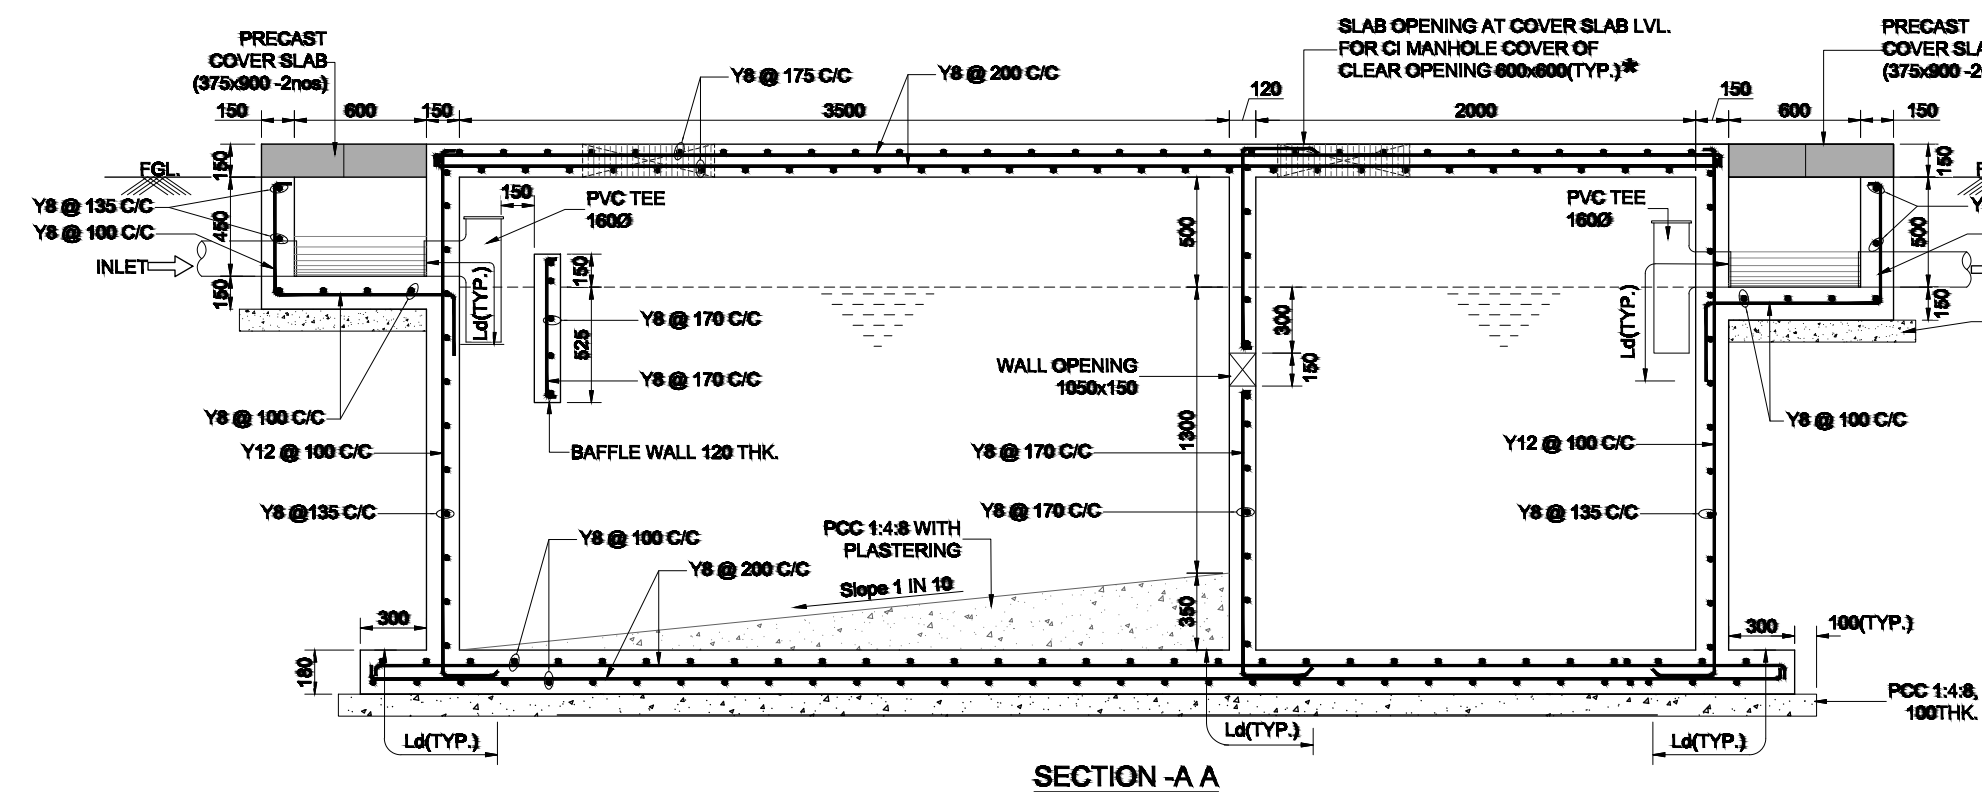

DRG NO: SHEET NO: REV. SCALE:					SWATI Architecture landscape interior ARCHITECTS PLANERS ENGINEERING INTERIOR DESIGN 282 , tulip , A block , Talpuri International colony , Bhilai , C.G. Email - swati.arch@outlook.com	
DP0001 DRG CL 01 701		1 OF 1	R0	NTS		
DESIGNED:		DRAWN:	CHECKED:	VERIFIED:	APPROVED:	CLIENT: CHHATTISGARH STATE MINOR FOREST PRODUCE
UPENDRA SINGH		SIMRAN SONI	UPENDRA SINGH	ADMIN	ADMIN	
ISSUED FOR:			UNIT:	DATE:	PROJECT: INCUBATION CENTER AT DEOBHOG GARIYABAND	
TENDOR PURPOSE			MILIMETER	12.05.2022		
This drawing is the property of HUP DESIGN and is to be used only for the purpose for which it was lent and must not be in any way detrimental to the interest of the company and is subject to return on demand					TITLE:	
					SEPTIC TANK	